
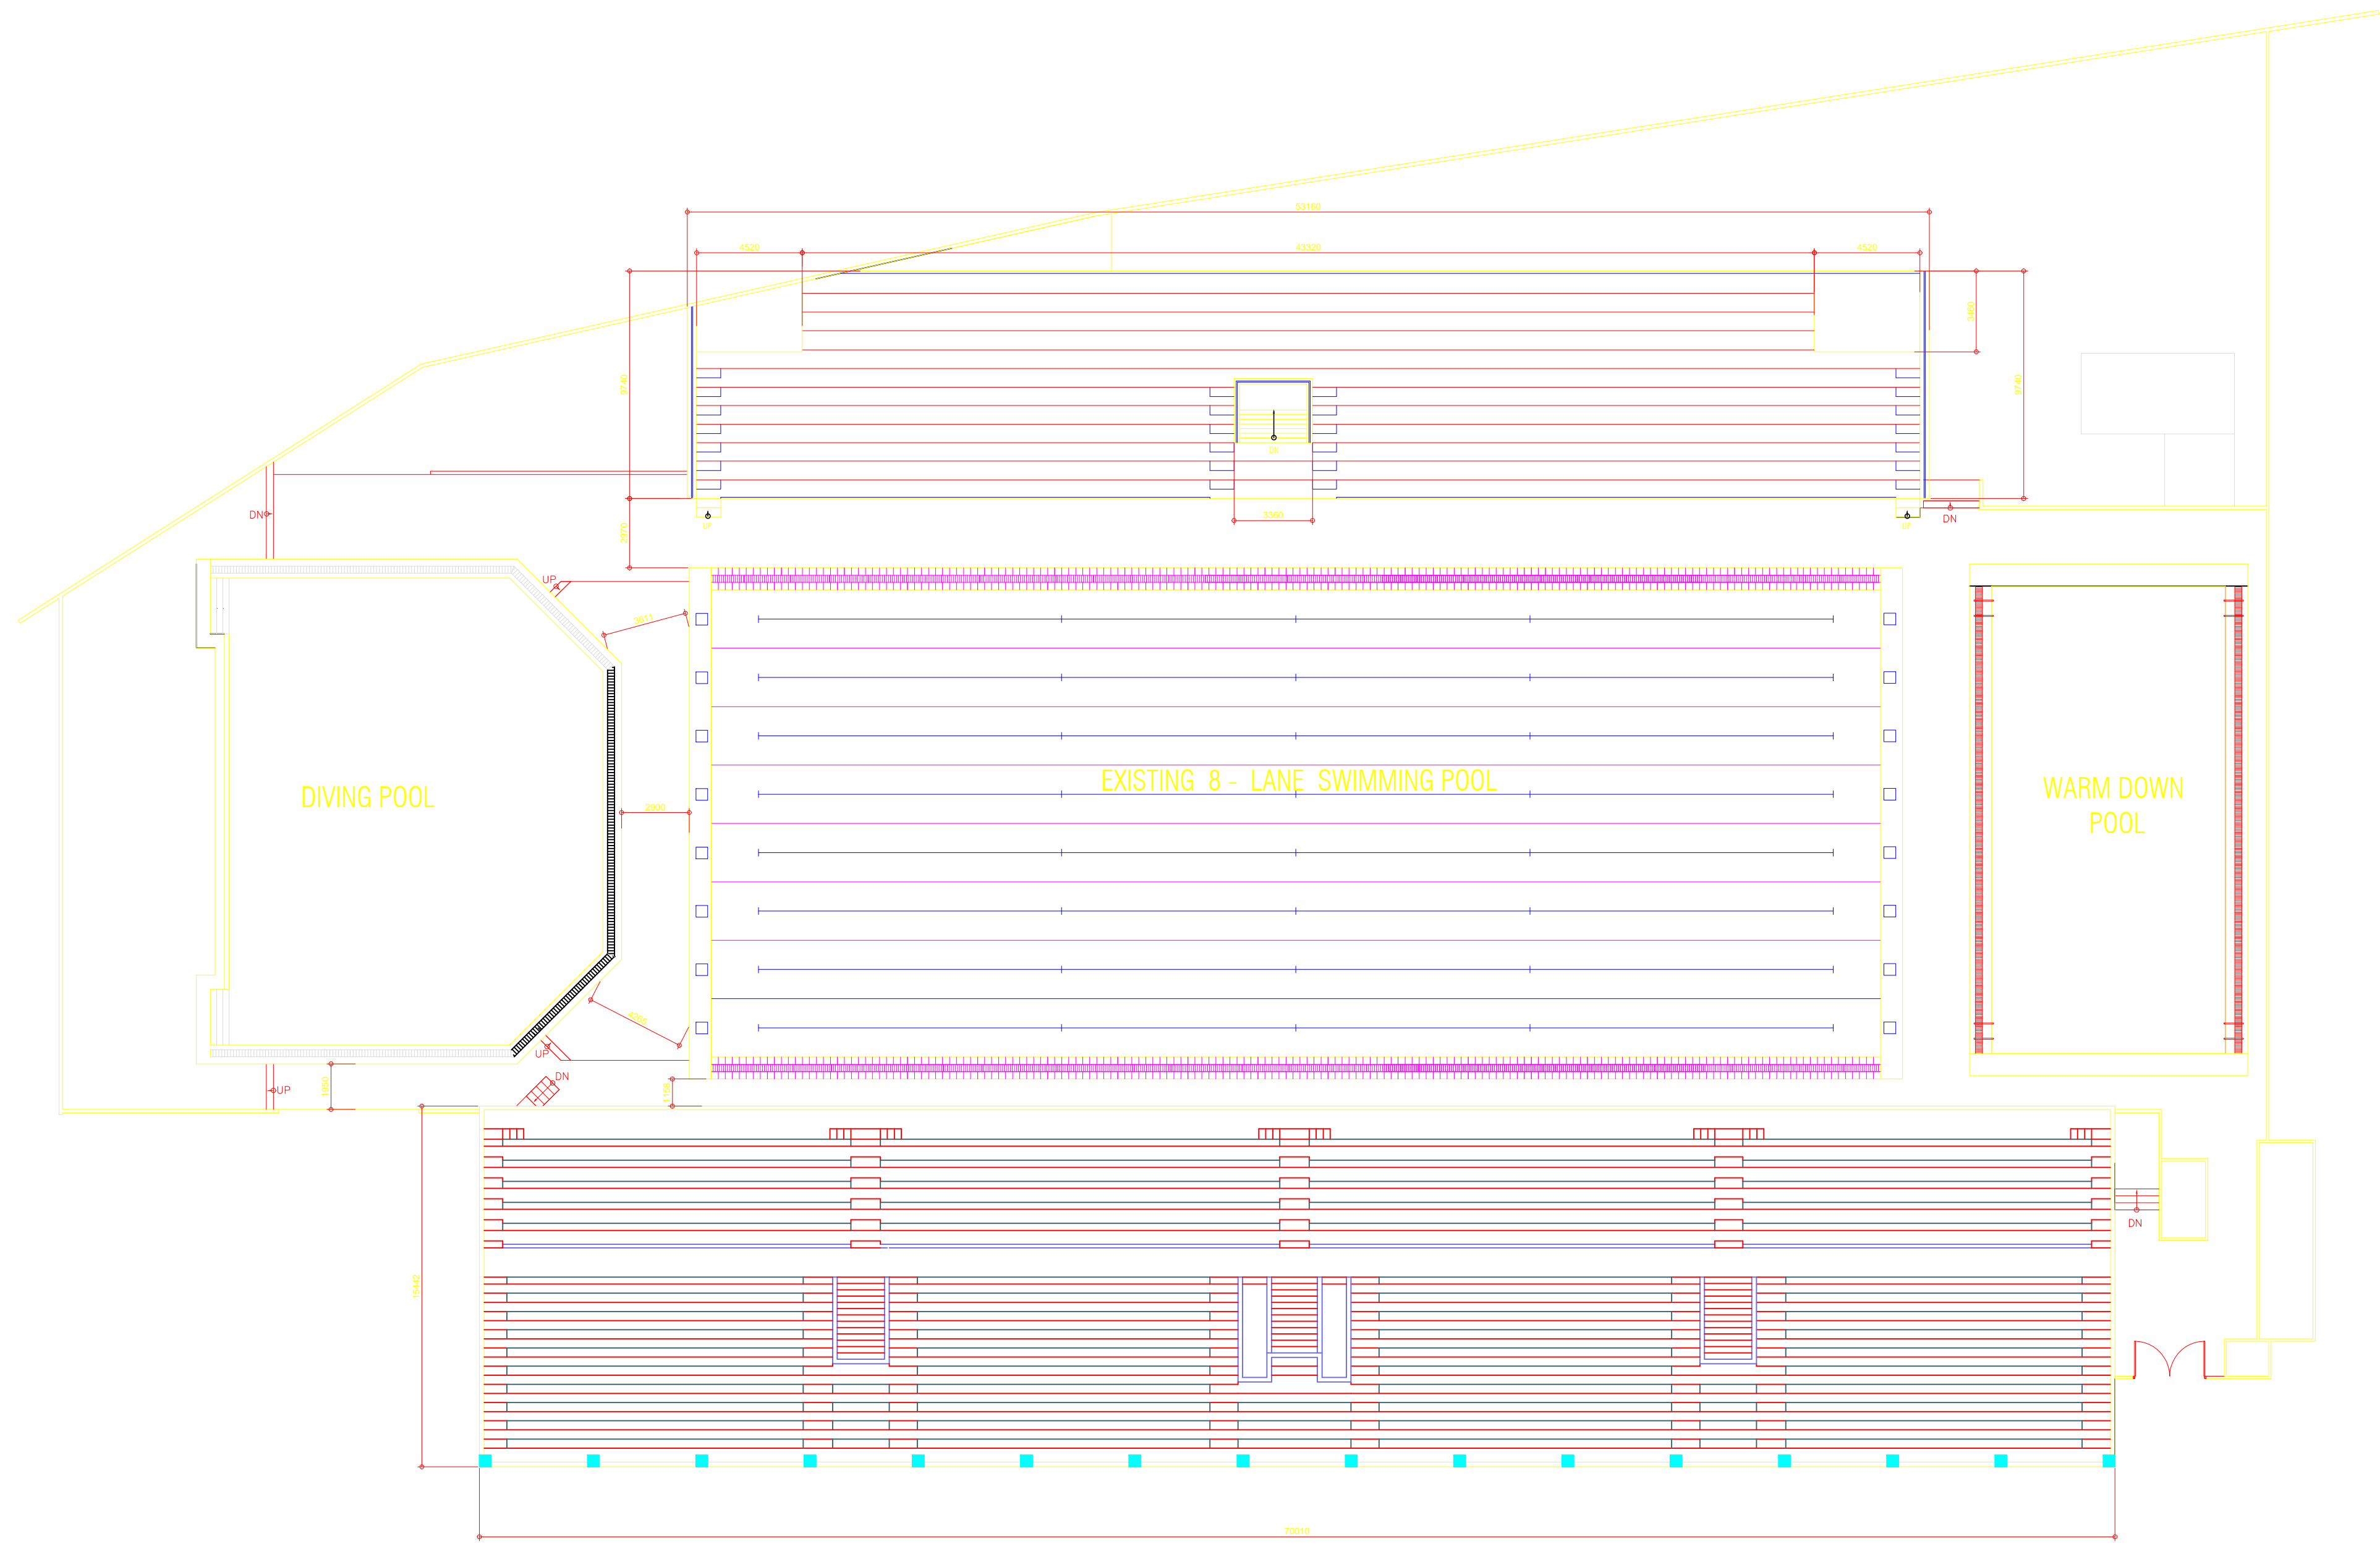



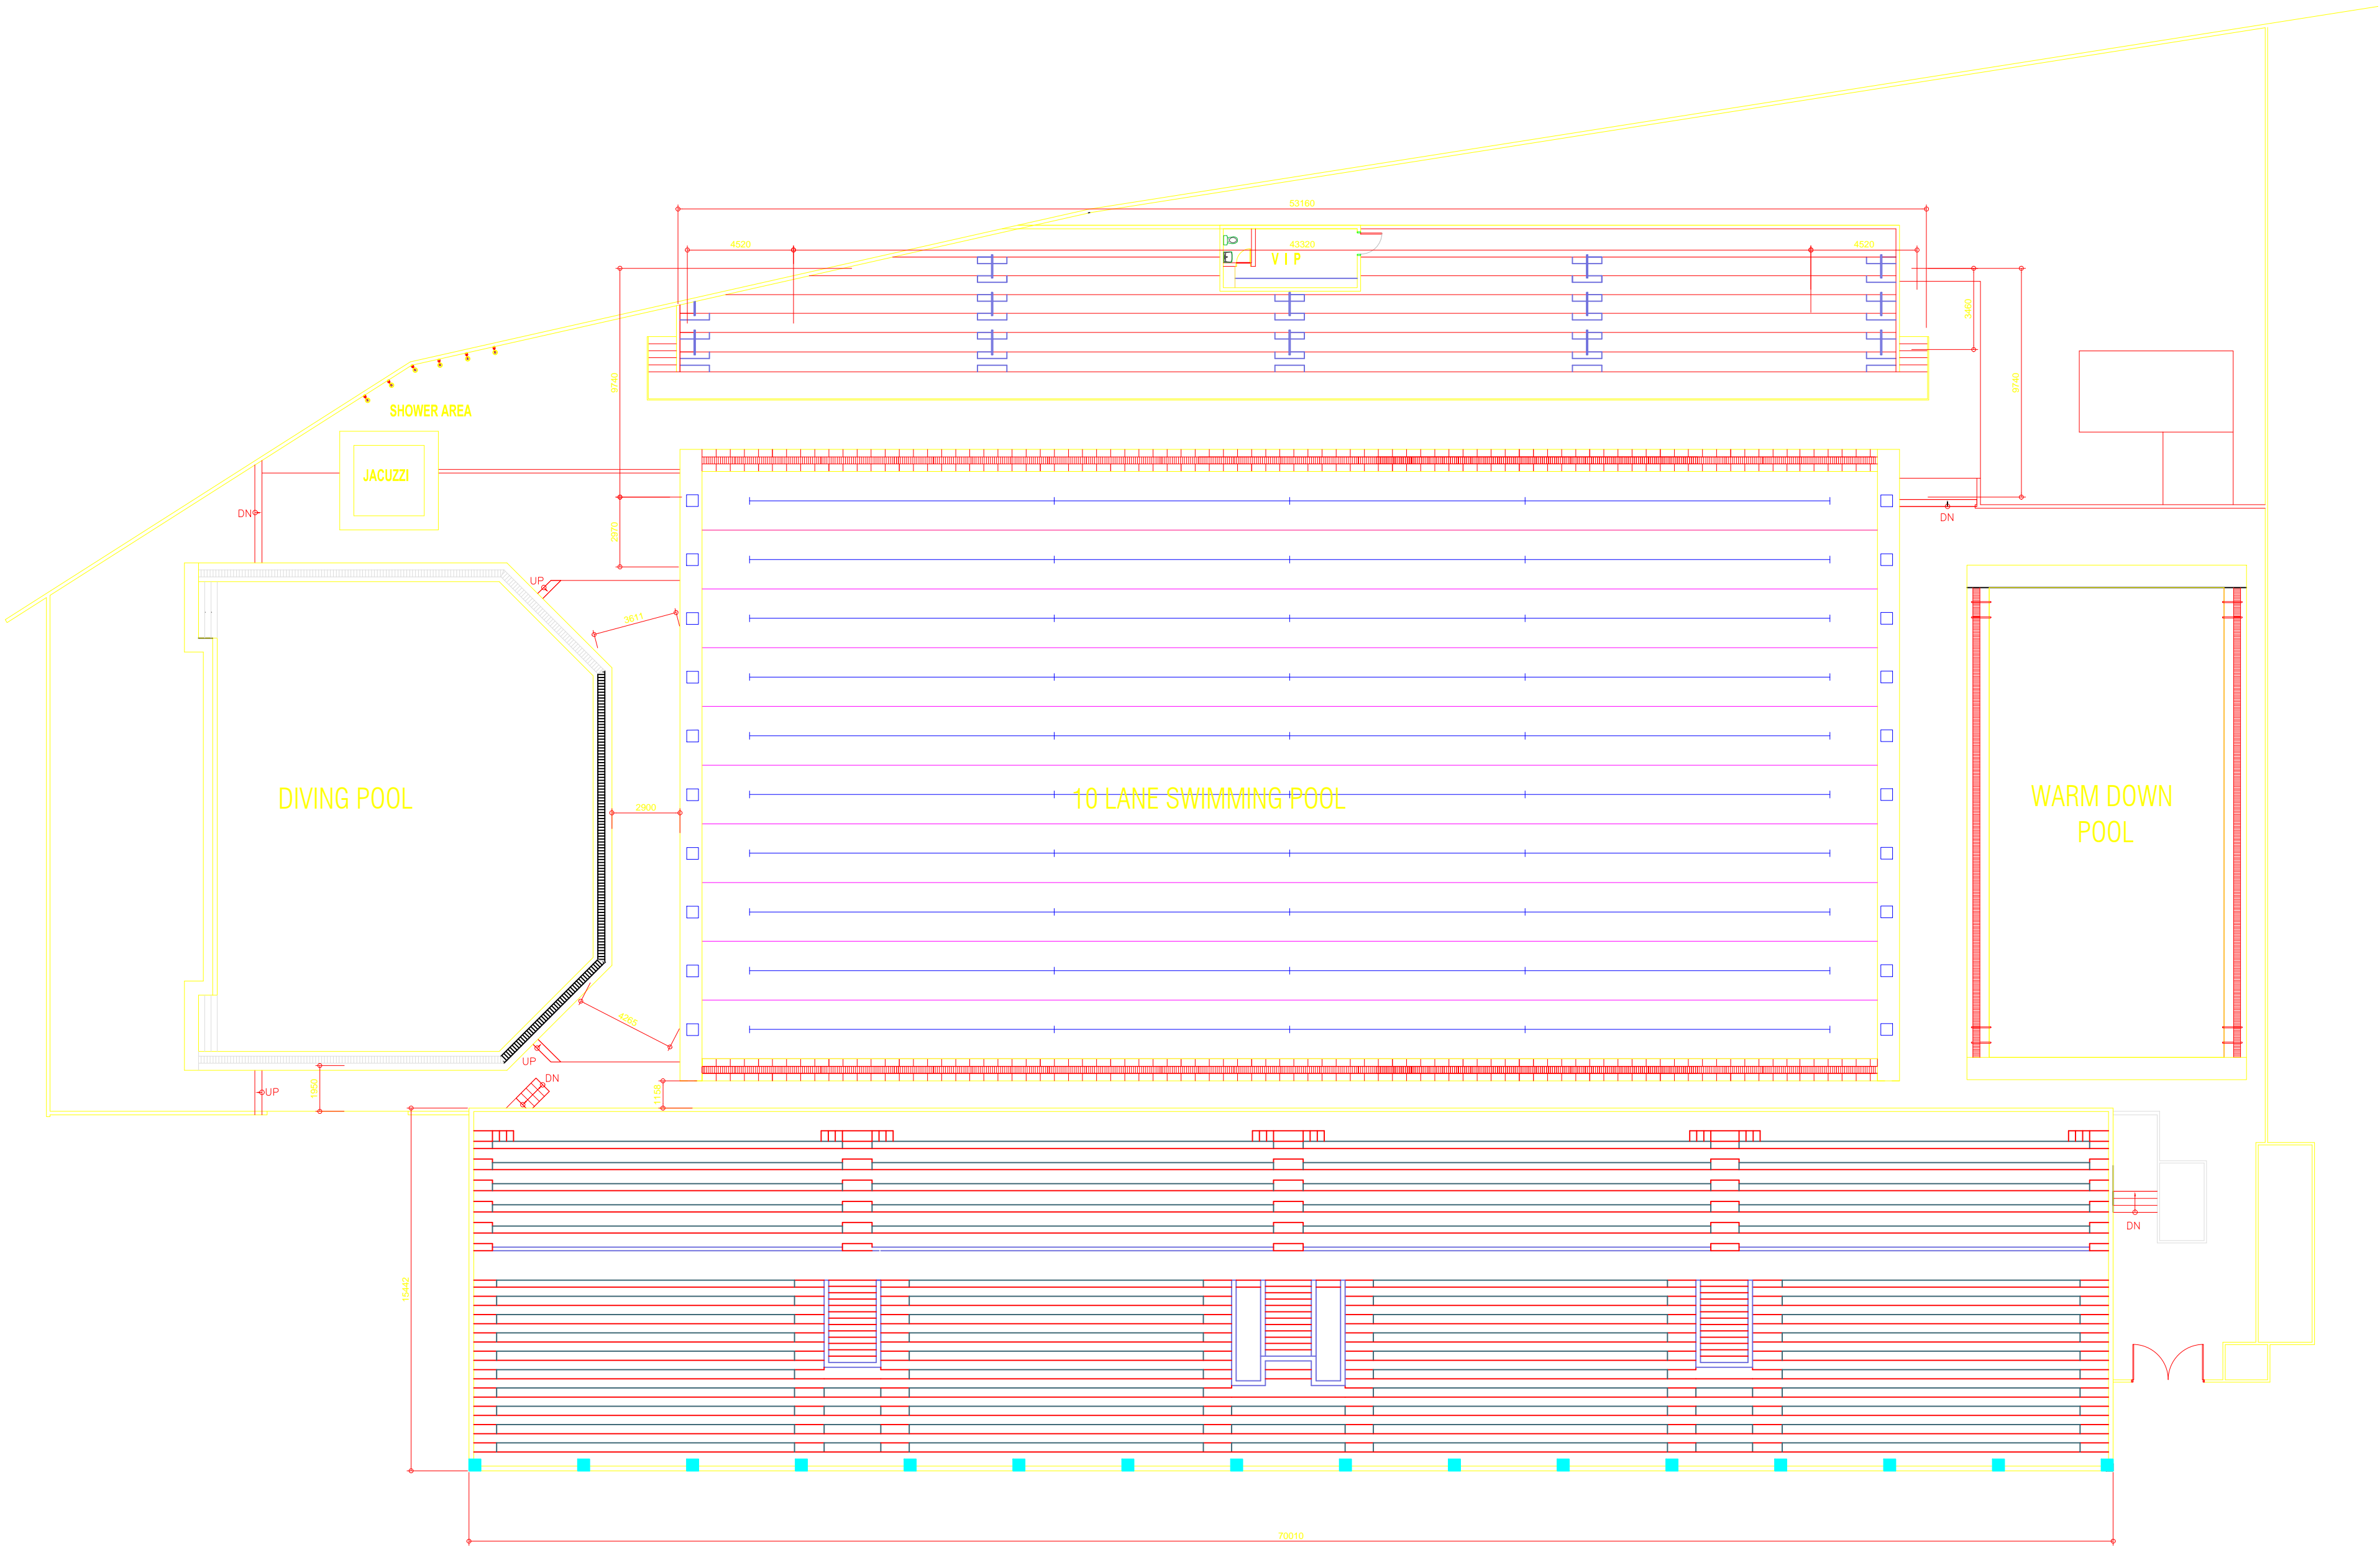
OWNER	PROJECT TITLE :	SUBMITTED BY :	RECOMMENDING APPROVAL :	APPROVED BY :	SHEET CONTENTS :	DESIGN BY :	SHEET NO :
 PHILIPPINE SPORTS COMMISSION RMSC, PABLO OCAMPO SR. ST., MALATE, MANILA	UPGRADING OF SWIMMING POOL, DIVING POOL, WARM UP POOL AND CONSTRUCTION OF NEW BLEACHERS, AND JACUZZI LOCATION: RMSC, PABLO OCAMPO SR. ST., MALATE, MANILA	ENGR. PEDRO I. PINEDA JR. HEAD - ENGINEERING UNIT	DIR. MERLITA R. IBAY DEPUTY EXECUTIVE DIRECTOR	HON. WILLIAM I. RAMIREZ CHAIRMAN	AS SHOWN	DRAWN BY :	<div style="border: 1px solid black; border-radius: 50%; width: 60px; height: 60px; display: flex; align-items: center; justify-content: center; margin: 0 auto;"> <div style="text-align: center;"> A <hr style="width: 50%; margin: 0 auto;"/> 1 </div> </div>
						CHECKED BY :	
						DATE :	
						APPROVED BY :	




EXISTING BLEACHERS FLOOR PLAN


SCALE 1 : 100 MTS.

OWNER	PROJECT TITLE :	SUBMITTED BY :	RECOMMENDING APPROVAL :	APPROVED BY :	SHEET CONTENTS :	DESIGN BY :		SHEET NO :
<div>PHILIPPINE SPORTS COMMISSION RMSG, PABLO OCAMPO SR. ST., MALATE, MANILA</div>	UPGRADING OF SWIMMING POOL, DIVING POOL, WARM UP POOL AND CONSTRUCTION OF NEW BLEACHERS,AND JACUZZI LOCATION: RMSG, PABLO OCAMPO SR. ST., MALATE, MANILA	ENGR. PEDRO I. PINEDA JR. HEAD - ENGINEERING UNIT	DIR. MERLITA R. IBAY DEPUTY EXECUTIVE DIRECTOR	HON. WILLIAM I. RAMIREZ CHAIRMAN	AS SHOWN	DRAWN BY :		<div>A</div> <div>2</div>
						CHECKED BY :		
						DATE :		
						APPROVED BY :		




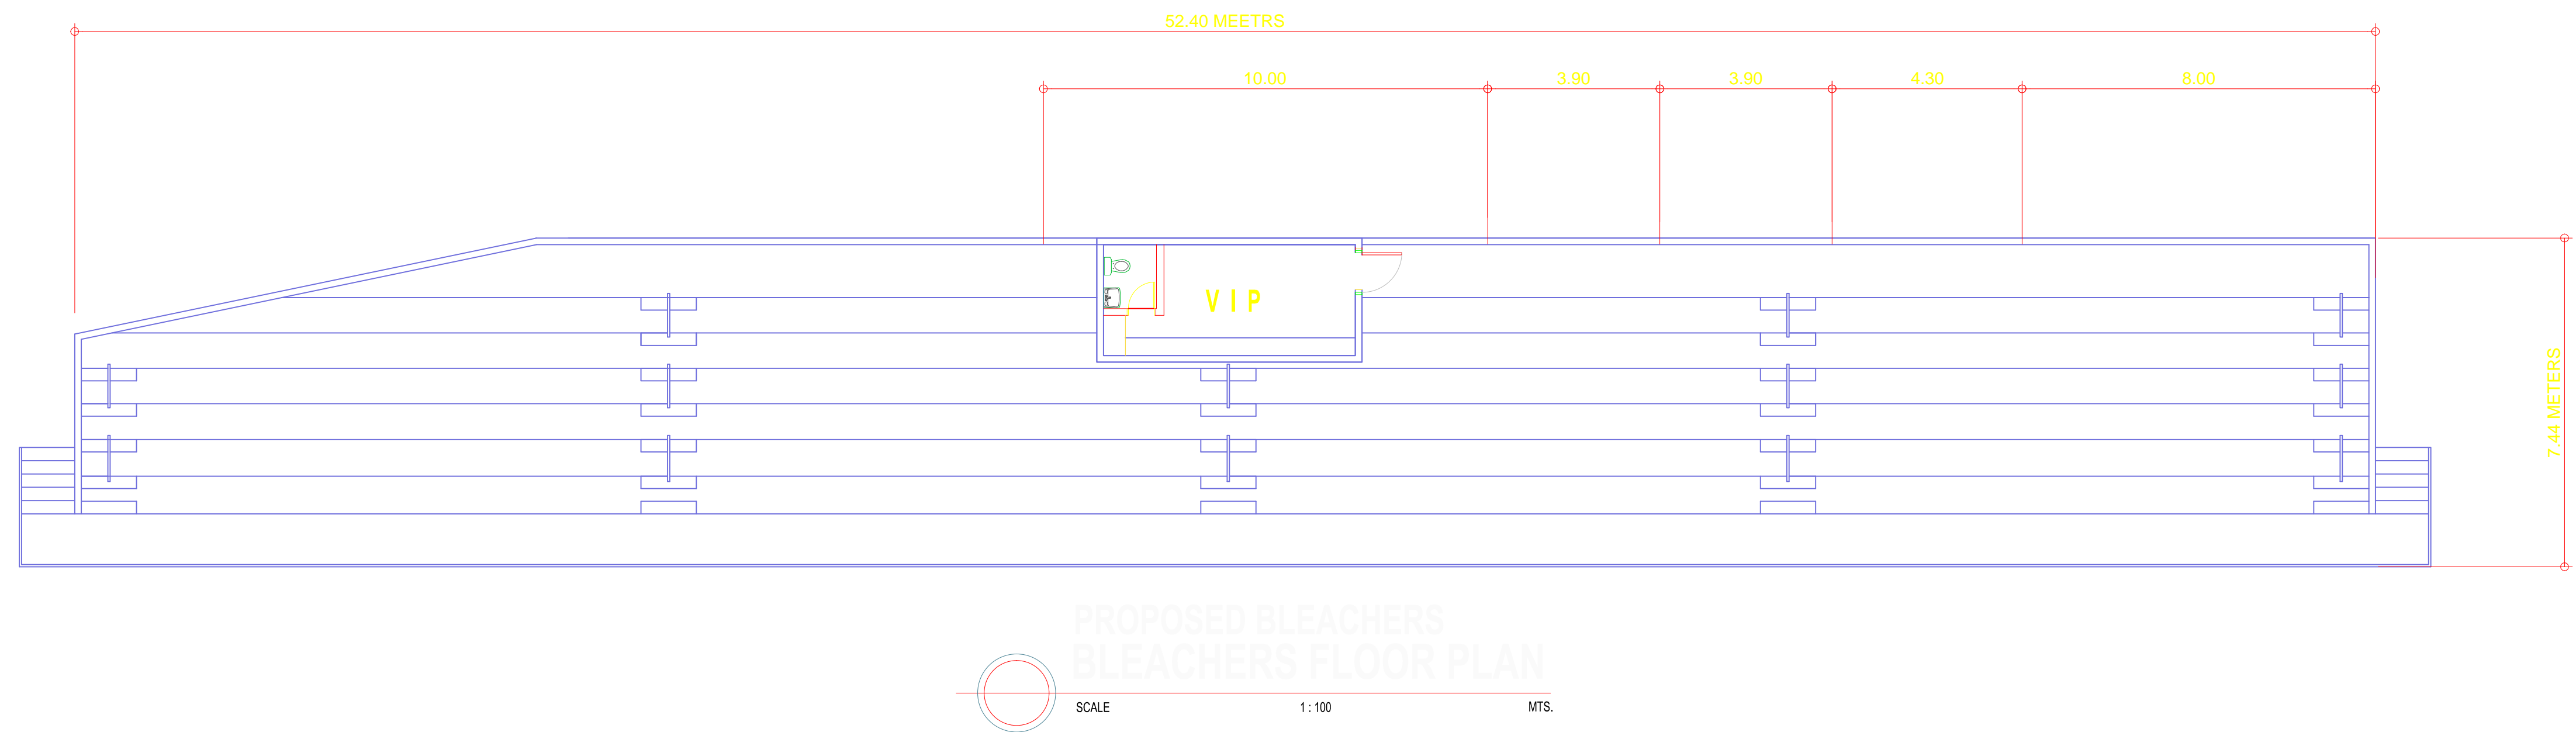
PROPOSED BLEACHERS GROUND FLOOR PLAN
SCALE 1 : 100 MTS.

 
OWNER	PROJECT TITLE :	SUBMITTED BY :	RECOMMENDING APPROVAL :	APPROVED BY :	SHEET CONTENTS :	DESIGN BY :		SHEET NO :
<div><div>PHILIPPINE SPORTS COMMISSION RMSG, PABLO OCAMPO SR. ST., MALATE, MANILA</div></div>	<div>UPGRADING OF SWIMMING POOL, DIVING POOL, WARM UP POOL AND CONSTRUCTION OF NEW BLEACHERS,AND JACUZZI</div> <div>LOCATION: RMSG, PABLO OCAMPO SR. ST., MALATE, MANILA</div>	<div>ENGR. PEDRO I. PINEDA JR.</div> <div>HEAD - ENGINEERING UNIT</div>	<div>DIR. MERLITA R. IBAY</div> <div>DEPUTY EXECUTIVE DIRECTOR</div>	<div>HON. WILLIAM I. RAMIREZ</div> <div>CHAIRMAN</div>	AS SHOWN	DRAWN BY :		<div>A</div> <div>3</div>
						CHECKED BY :		
						DATE :		
						APPROVED BY :		

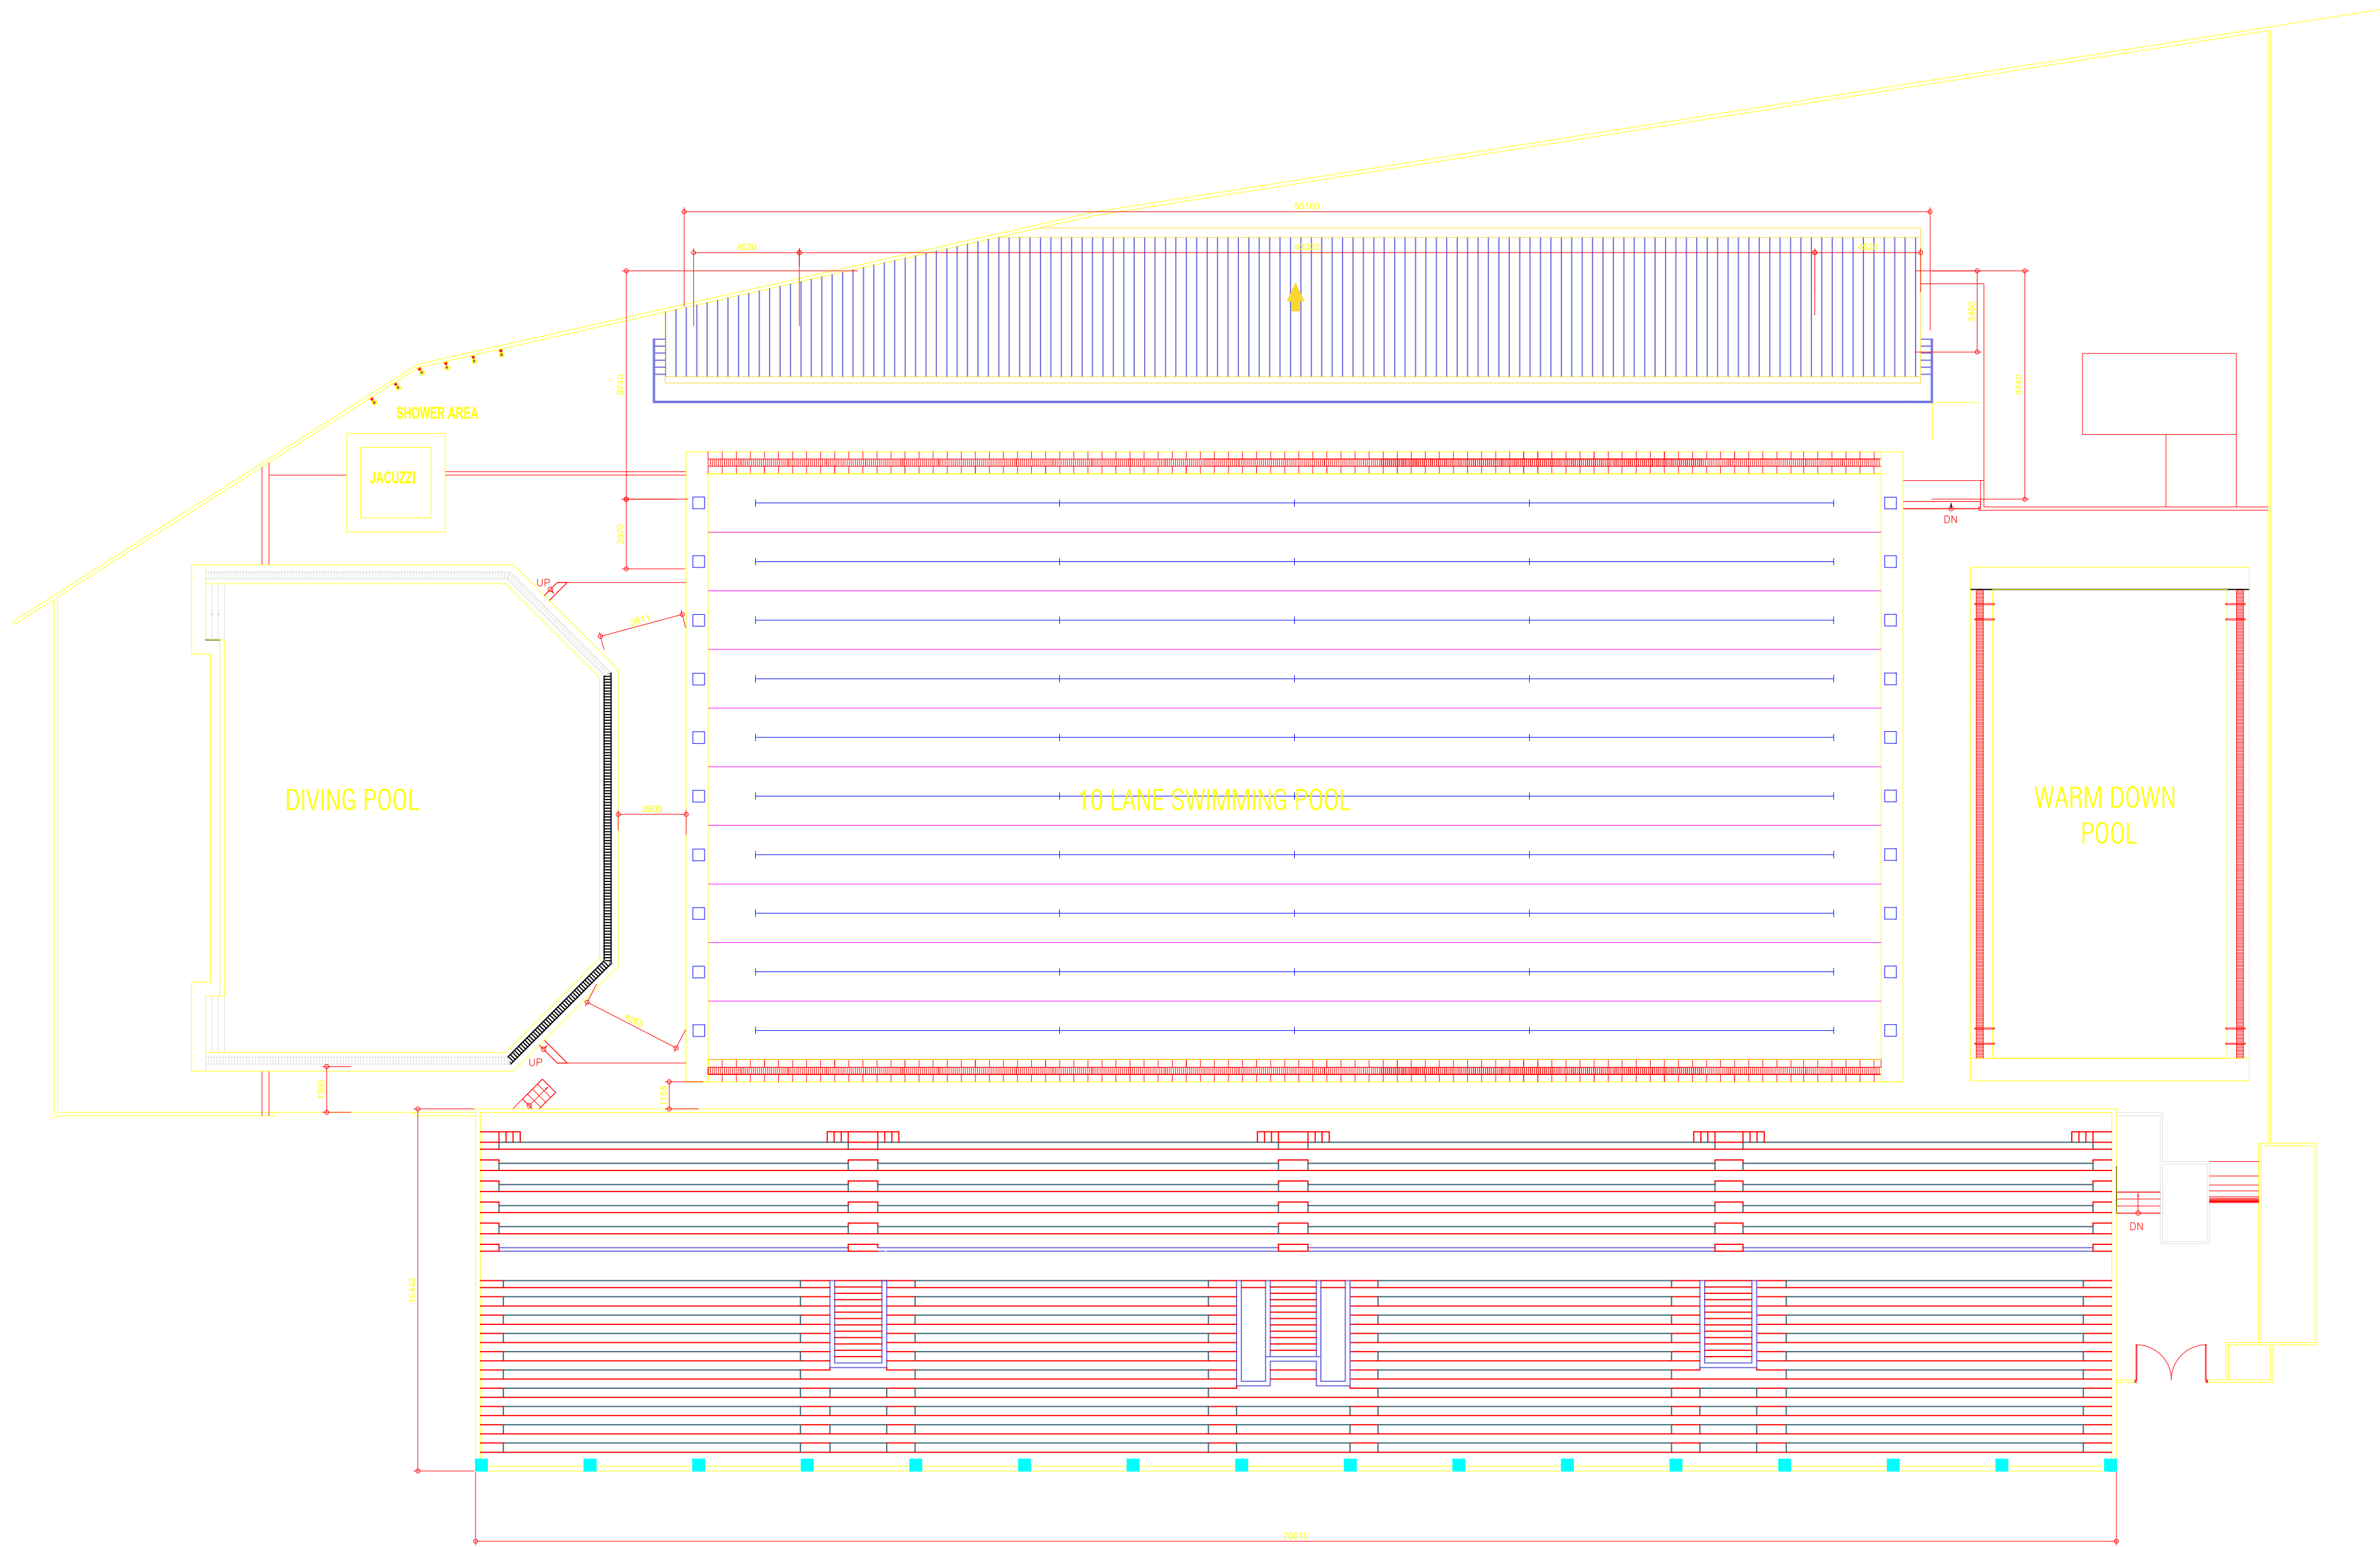


PROPOSED BLEACHERS ROOF PLAN
SCALE 1 : 100 MTS.

OWNER	PROJECT TITLE :	SUBMITTED BY :	RECOMMENDING APPROVAL :	APPROVED BY :	SHEET CONTENTS :	DESIGN BY :		SHEET NO :
 PHILIPPINE SPORTS COMMISSION RMSG, PABLO OCAMPO SR. ST., MALATE, MANILA	UPGRADING OF SWIMMING POOL, DIVING POOL, WARM UP POOL AND CONSTRUCTION OF NEW BLEACHERS,AND JACUZZI LOCATION: RMSG, PABLO OCAMPO SR. ST., MALATE, MANILA	ENGR. PEDRO I. PINEDA JR. HEAD - ENGINEERING UNIT	DIR. MERLITA R. IBAY DEPUTY EXECUTIVE DIRECTOR	HON. WILLIAM I. RAMIREZ CHAIRMAN	AS SHOWN	DRAWN BY :		<div>A</div> <div>5</div>
						CHECKED BY :		
						DATE :		
						APPROVED BY :		




OWNER	PROJECT TITLE :	SUBMITTED BY :	RECOMMENDING APPROVAL :	APPROVED BY :	SHEET CONTENTS :	DESIGN BY :	SHEET NO :
 PHILIPPINE SPORTS COMMISSION RMSC, PABLO OCAMPO SR. ST., MALATE, MANILA	UPGRADING OF SWIMMING POOL, DIVING POOL, WARM UP POOL AND CONSTRUCTION OF NEW BLEACHERS, AND JACUZZI LOCATION: RMSC, PABLO OCAMPO SR. ST., MALATE, MANILA	ENGR. PEDRO I. PINEDA JR. HEAD - ENGINEERING UNIT	DIR. MERLITA R. IBAY DEPUTY EXECUTIVE DIRECTOR	HON. WILLIAM I. RAMIREZ CHAIRMAN	AS SHOWN	DRAWN BY :	<div style="border: 1px solid black; border-radius: 50%; width: 60px; height: 60px; display: flex; align-items: center; justify-content: center; margin: 0 auto;"> <div style="text-align: center;">A</div> <hr style="width: 50%; margin: 5px auto;"/> <div style="text-align: center;">6</div> </div>
						CHECKED BY :	
						DATE :	
						APPROVED BY :	

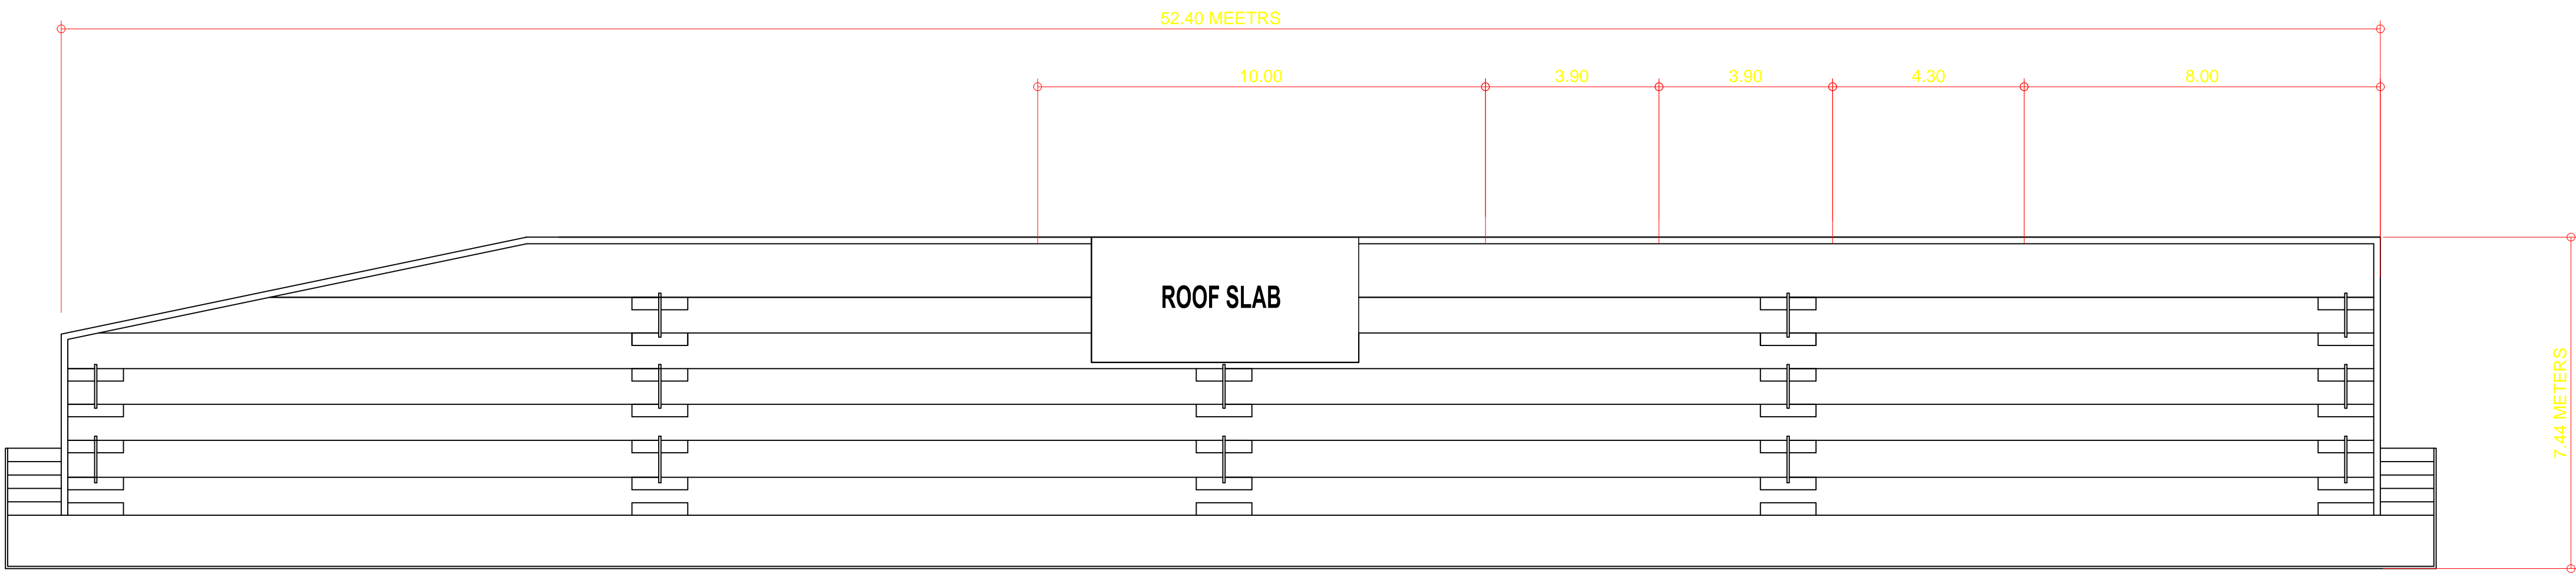


**PROPOSED BLEACHERS
VIP ROOF SLAB PLAN**



SCALE 1:100 MTS.

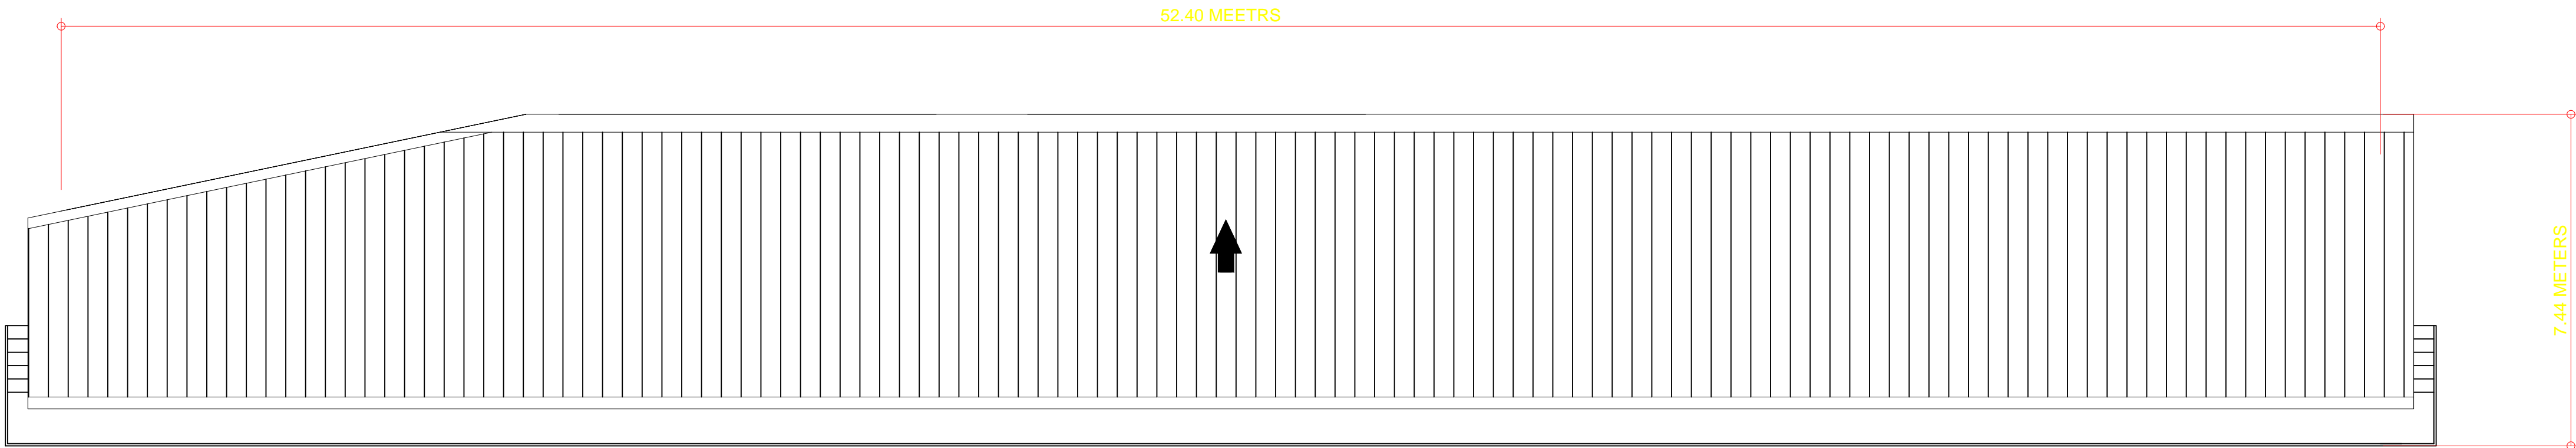



**PROPOSED BLEACHERS
ROOF PLAN**

SCALE 1:100 MTS.


OWNER	PROJECT TITLE :	SUBMITTED BY :	RECOMMENDING APPROVAL :	APPROVED BY :	SHEET CONTENTS :	DESIGN BY :		SHEET NO :
 PHILIPPINE SPORTS COMMISSION RMSG, PABLO OCAMPO SR. ST., MALATE, MANILA	UPGRADING OF SWIMMING POOL, DIVING POOL, WARM UP POOL AND CONSTRUCTION OF NEW BLEACHERS,AND JACUZZI LOCATION: RMSG, PABLO OCAMPO SR. ST., MALATE, MANILA	ENGR. PEDRO I. PINEDA JR. HEAD - ENGINEERING UNIT	DIR. MERLITA R. IBAY DEPUTY EXECUTIVE DIRECTOR	HON. WILLIAM I. RAMIREZ CHAIRMAN	AS SHOWN	DRAWN BY :		<div>A</div> <div>7</div>
						CHECKED BY :		
						DATE :		
						APPROVED BY :		

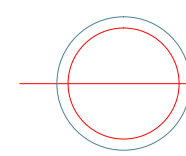
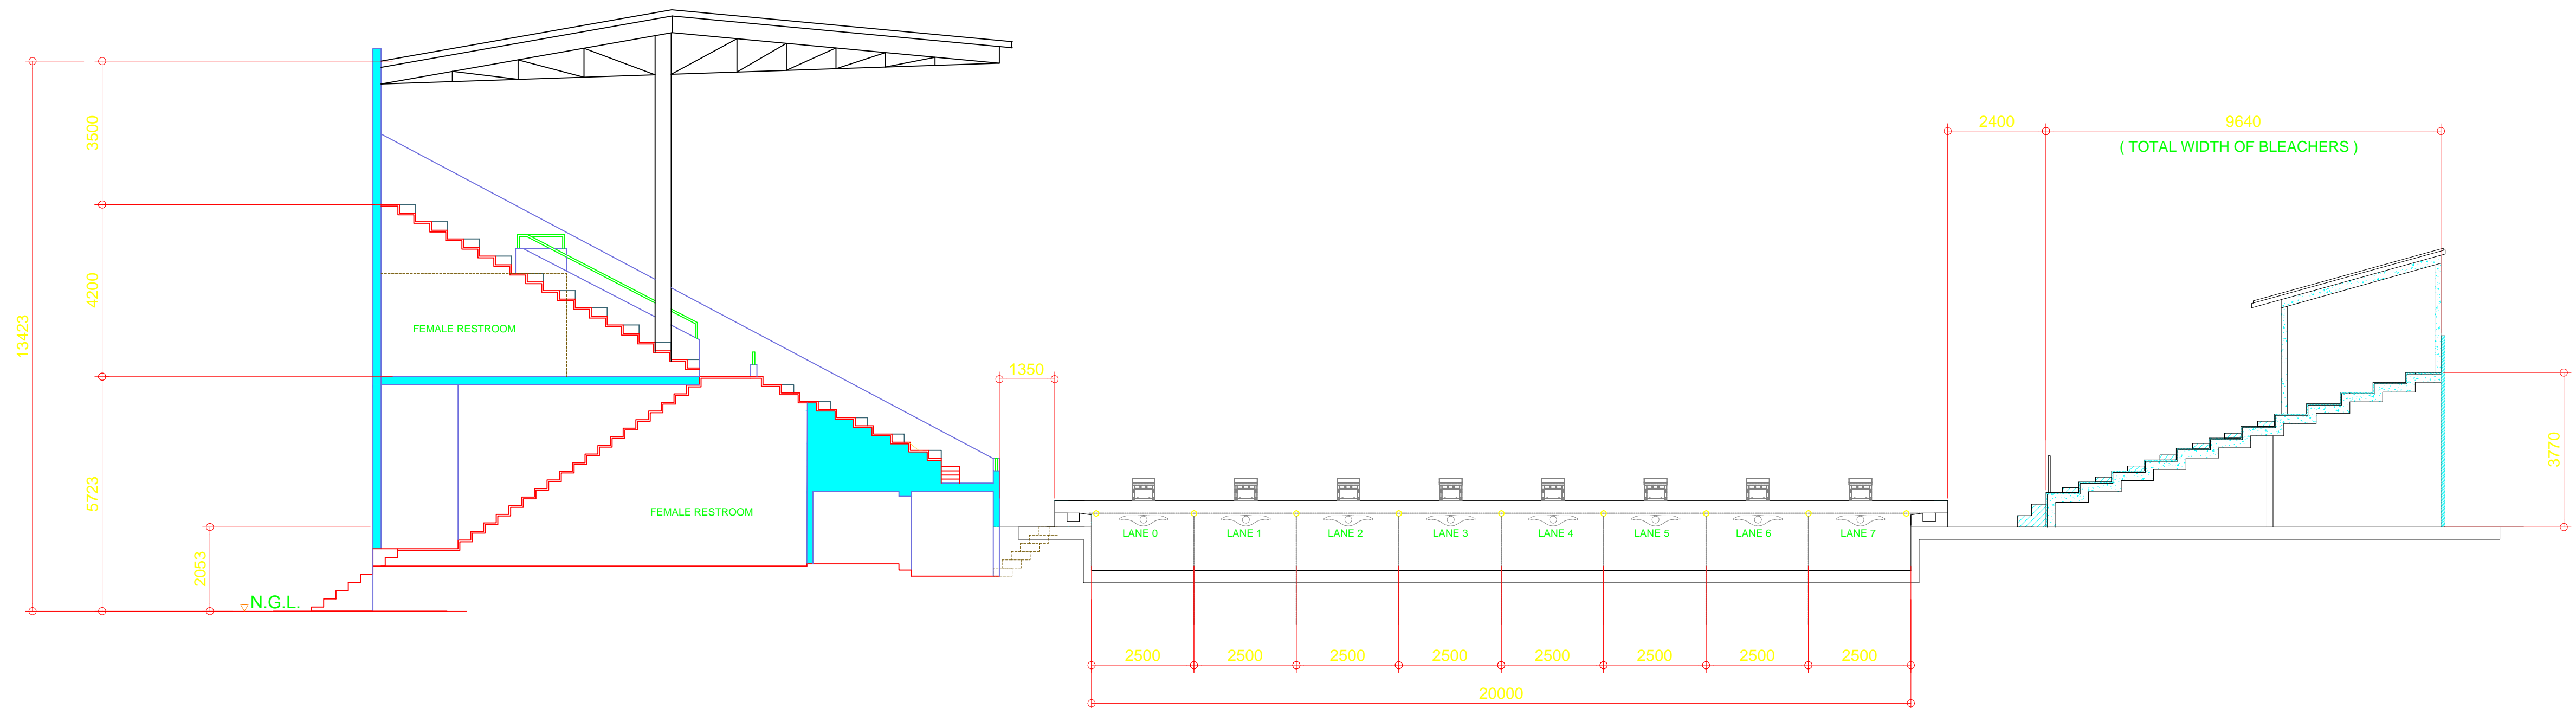


EXISTING CROSS SECTION OF AQUATIC CENTER
SCALE 1:20 MTS.

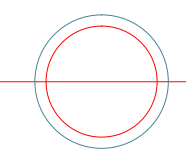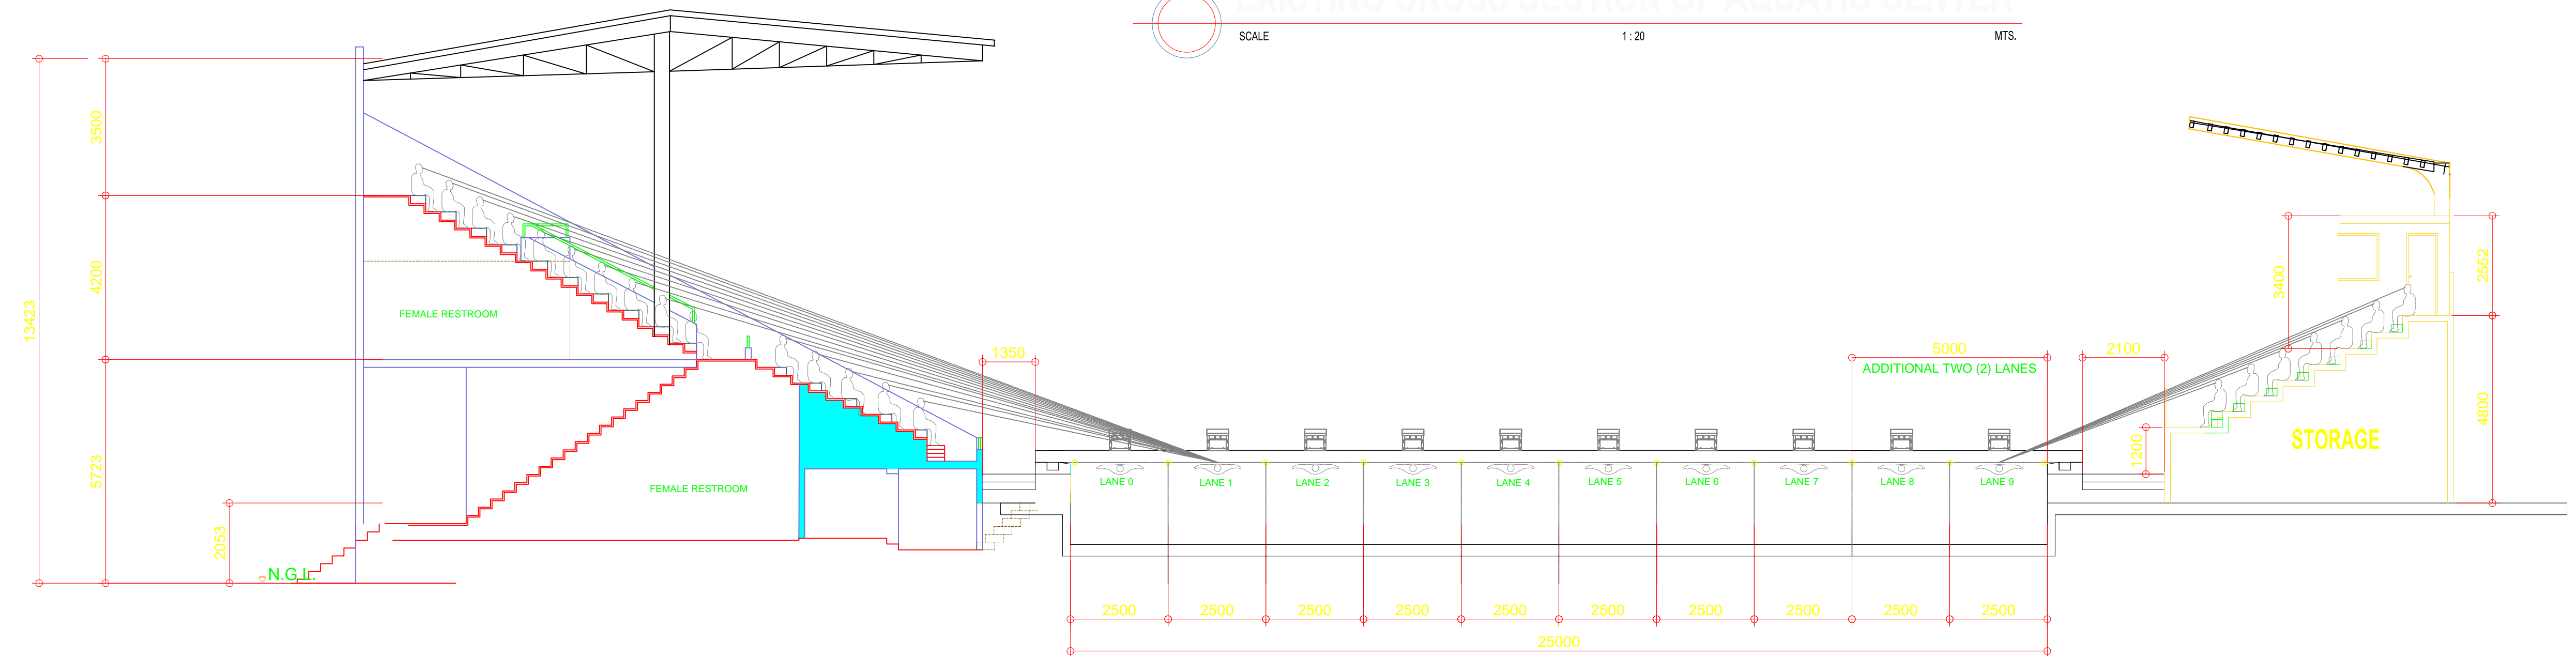


PROPOSED CROSS SECTION OF AQUATIC CENTER
SCALE 1:20 MTS.


OWNER	PROJECT TITLE :	SUBMITTED BY :	RECOMMENDING APPROVAL :	APPROVED BY :	SHEET CONTENTS :	DESIGN BY :		SHEET NO :
 PHILIPPINE SPORTS COMMISSION RMSC, PABLO OCAMPO SR. ST., MALATE, MANILA	UPGRADING OF SWIMMING POOL, DIVING POOL, WARM UP POOL AND CONSTRUCTION OF NEW BLEACHERS,AND JACUZZI LOCATION: RMSC, PABLO OCAMPO SR. ST., MALATE, MANILA	ENGR. PEDRO I. PINEDA JR. HEAD - ENGINEERING UNIT	DIR. MERLITA R. IBAY DEPUTY EXECUTIVE DIRECTOR	HON. WILLIAM I. RAMIREZ CHAIRMAN	AS SHOWN	DRAWN BY : CHECKED BY : DATE : APPROVED BY :		A 8

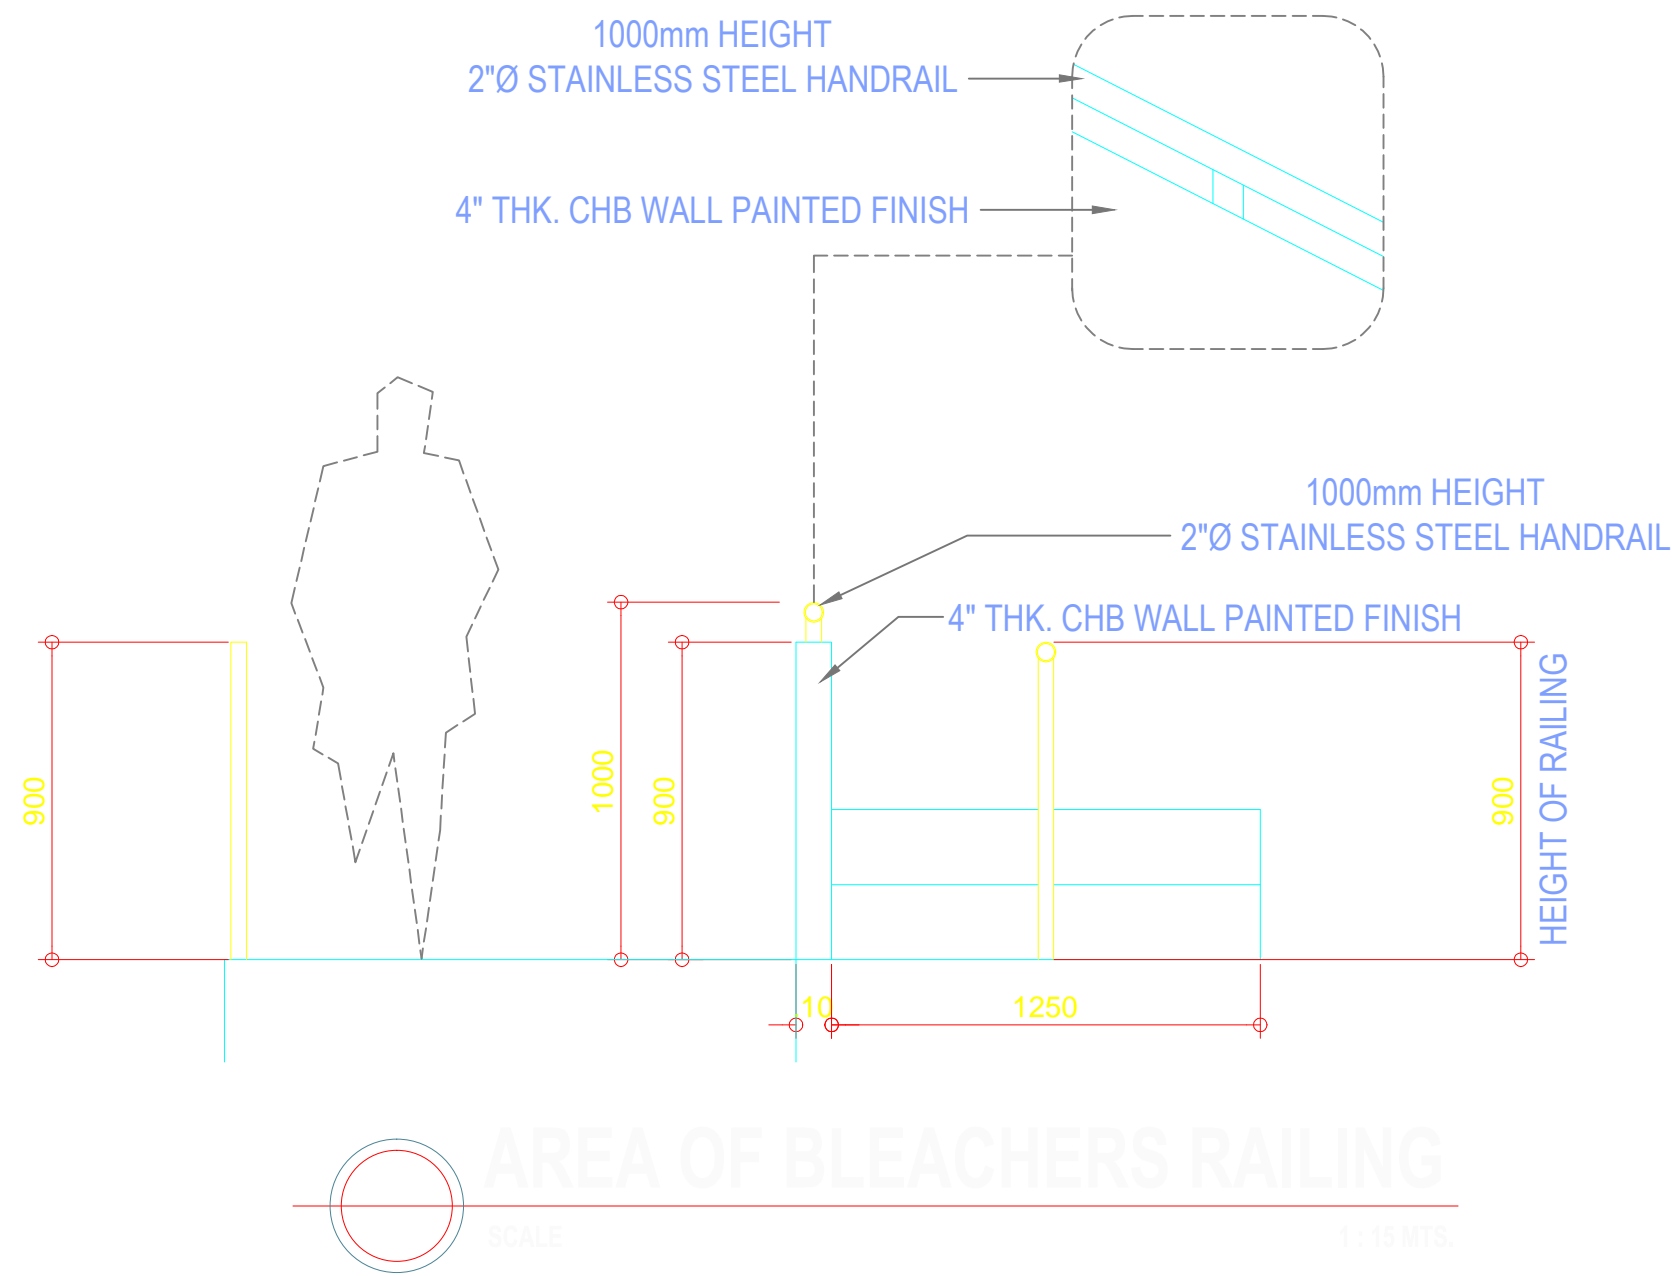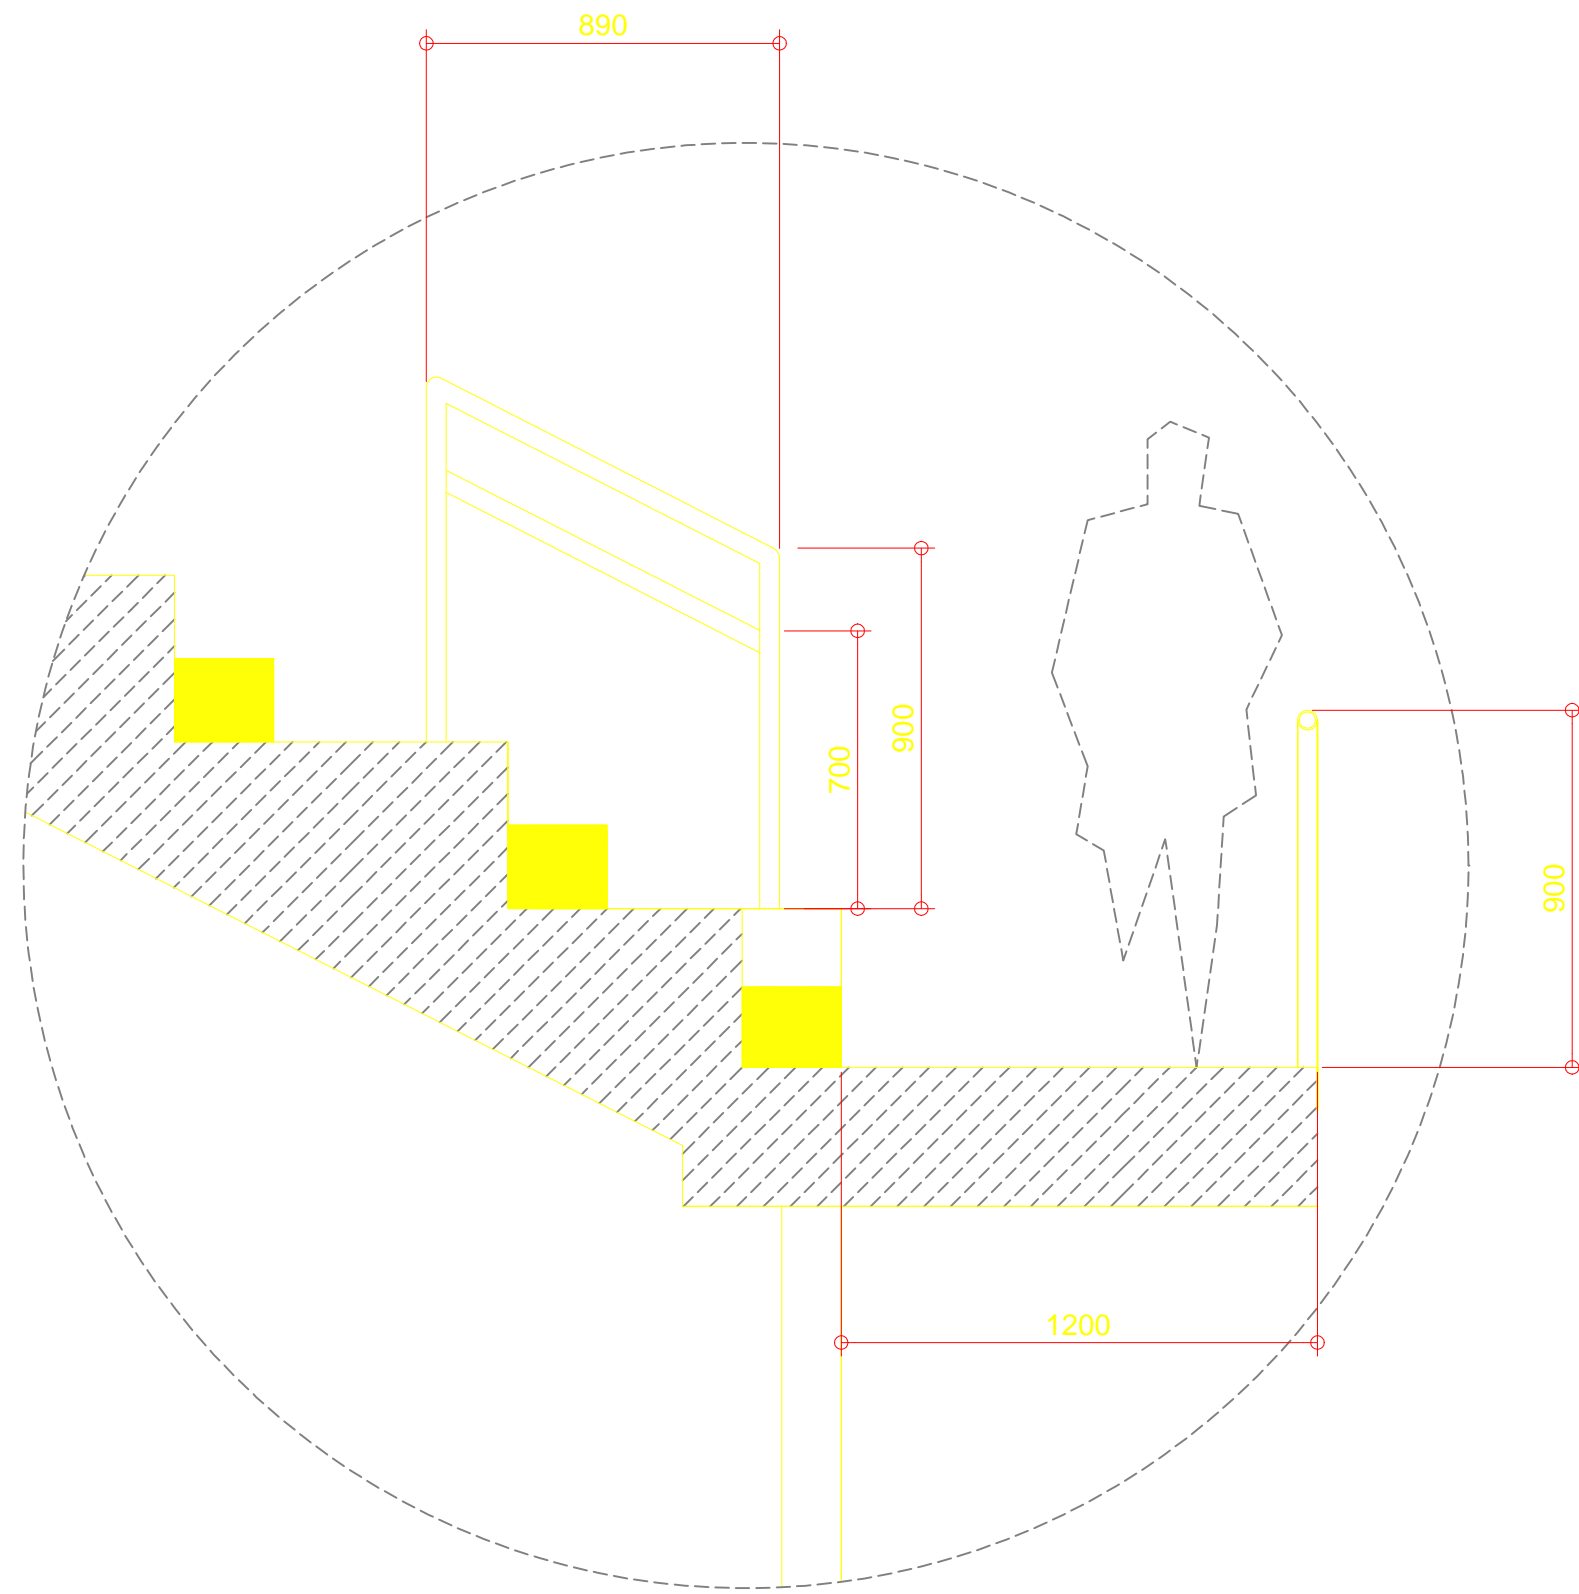


DETAIL OF RAILING @ BLEACHERS STEP
SCALE 1:15 MTS.

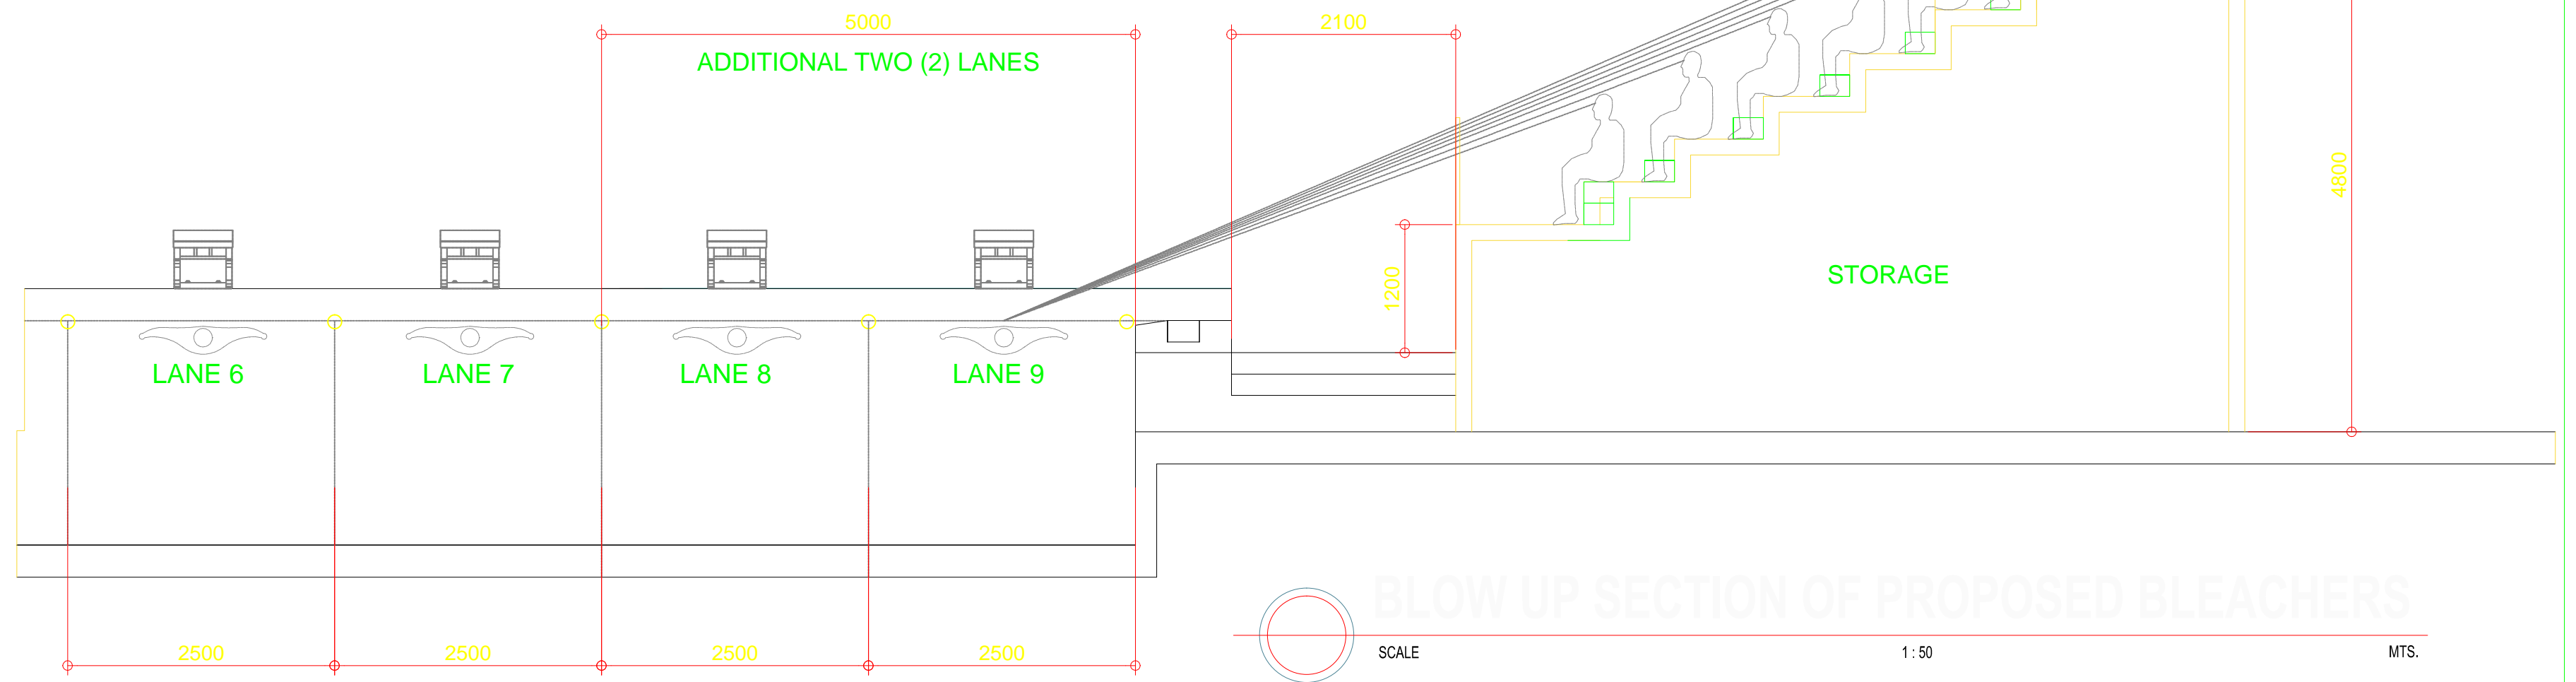


BLOW UP SECTION OF PROPOSED BLEACHERS
SCALE 1:50 MTS.


OWNER	PROJECT TITLE :	SUBMITTED BY :	RECOMMENDING APPROVAL :	APPROVED BY :	SHEET CONTENTS :	DESIGN BY :		SHEET NO :
<div>PHILIPPINE SPORTS COMMISSION RMSC, PABLO OCAMPO SR. ST., MALATE, MANILA</div>	<div>UPGRADING OF SWIMMING POOL, DIVING POOL, WARM UP POOL AND CONSTRUCTION OF NEW BLEACHERS,AND JACUZZI</div> <div>LOCATION: RMSC, PABLO OCAMPO SR. ST., MALATE, MANILA</div>	<div>ENGR. PEDRO I. PINEDA JR.</div> <div>HEAD - ENGINEERING UNIT</div>	<div>DIR. MERLITA R. IBAY</div> <div>DEPUTY EXECUTIVE DIRECTOR</div>	<div>HON. WILLIAM I. RAMIREZ</div> <div>CHAIRMAN</div>	AS SHOWN	DRAWN BY :		<div>A</div> <div>9</div>
						CHECKED BY :		
						DATE :		
						APPROVED BY :		

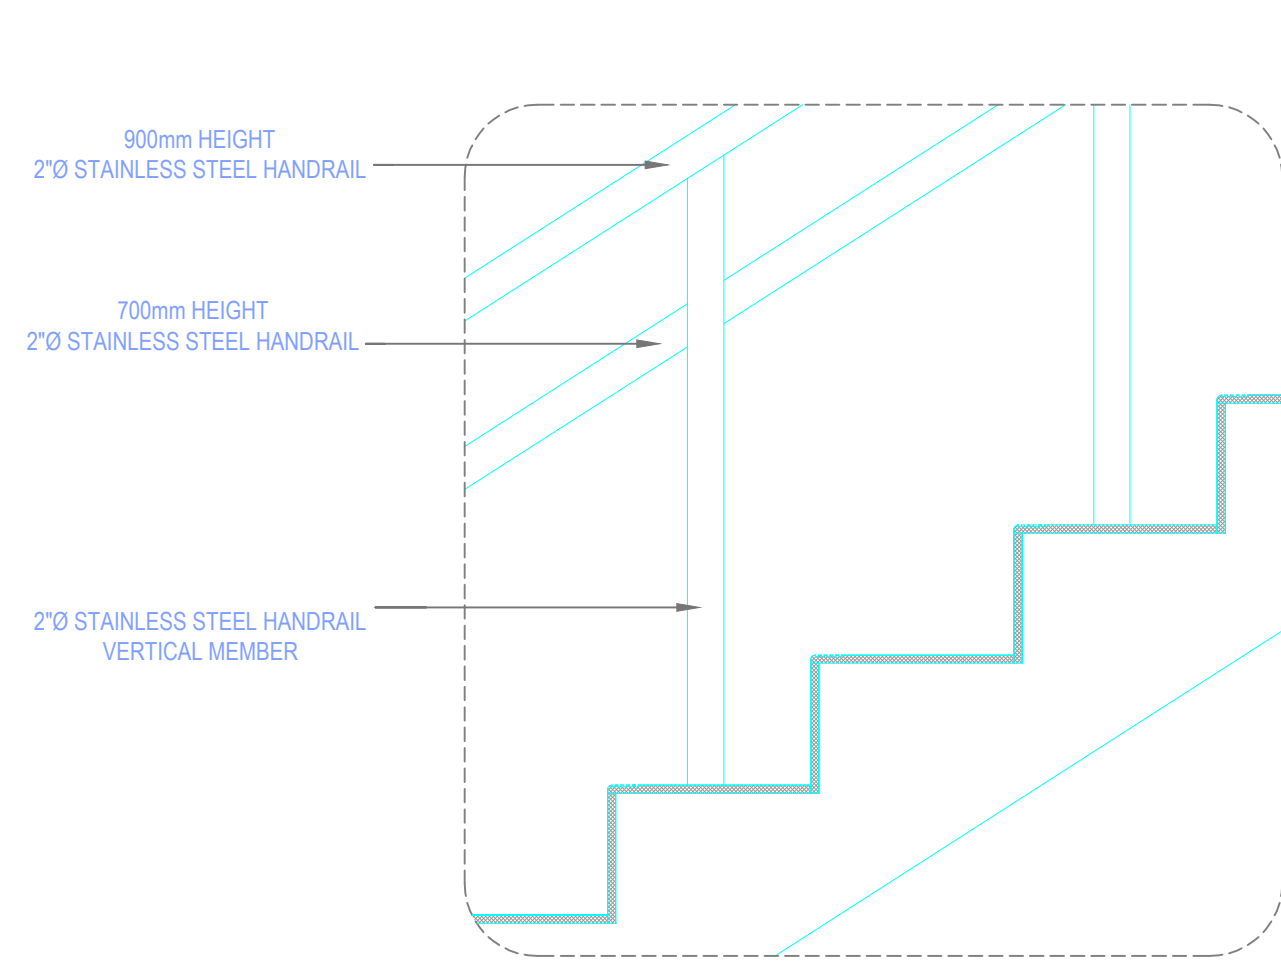


DETAIL OF RAILING

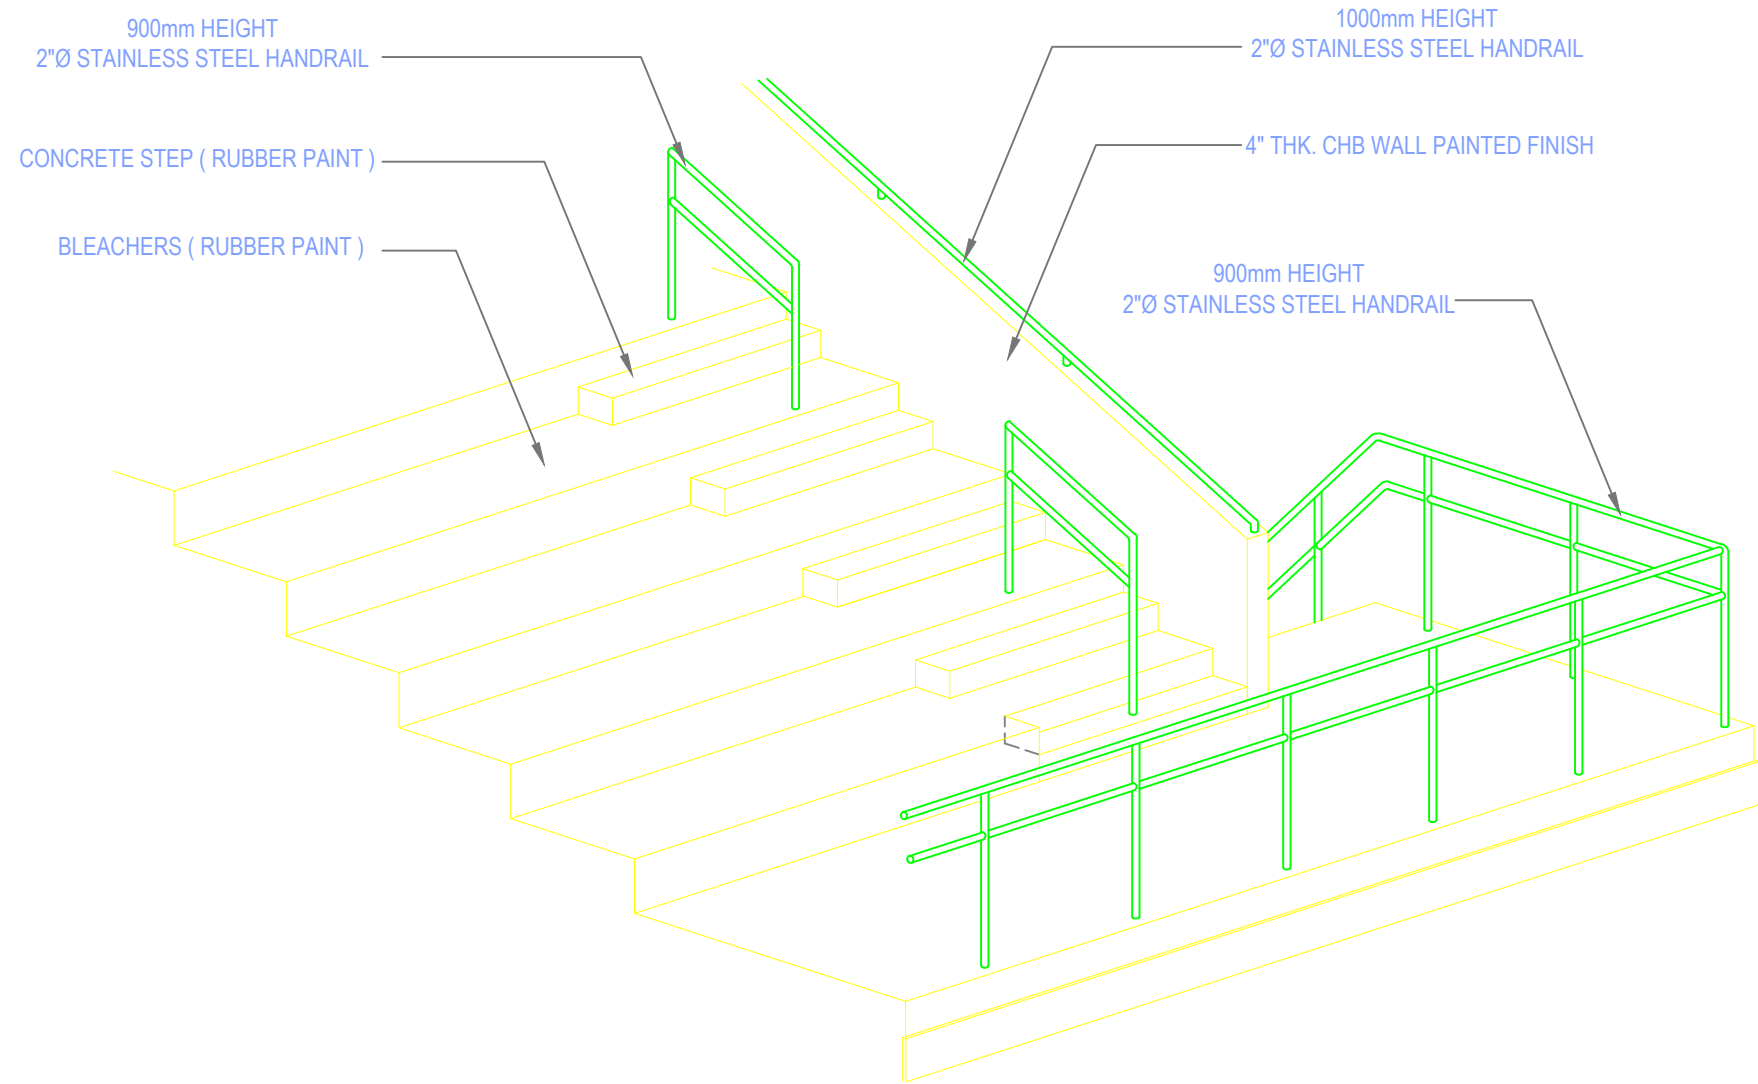


ISOMETRIC VIEW OF BLEACHERS

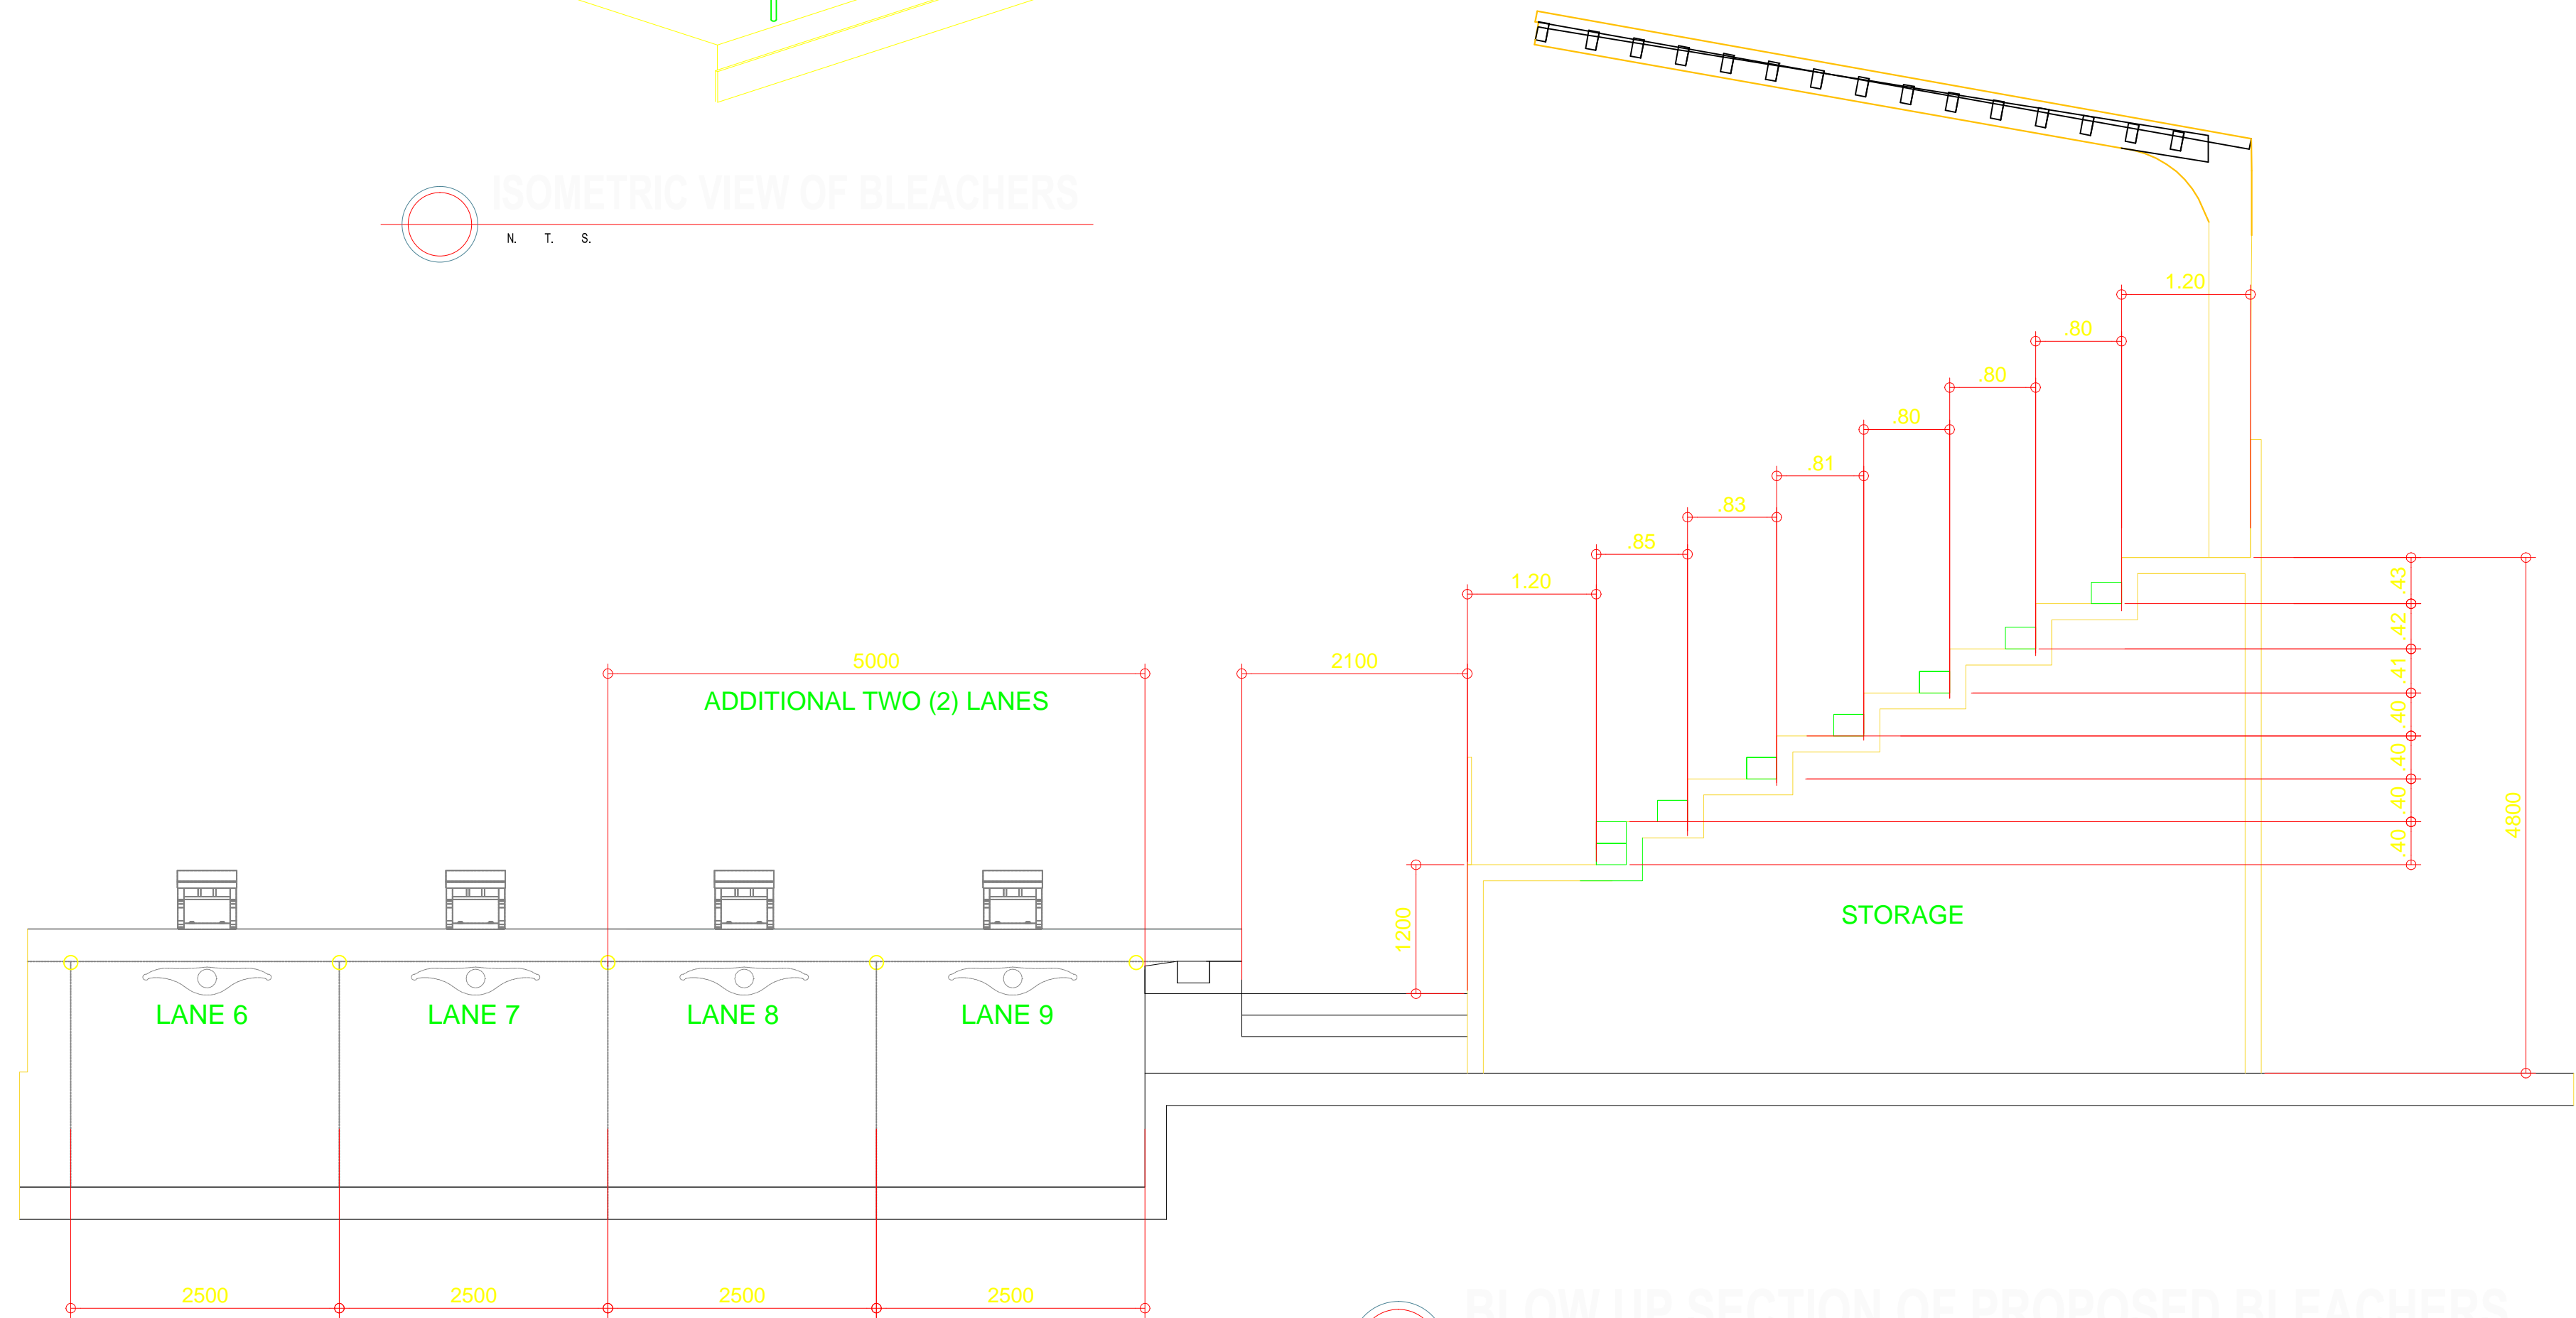


BLOW UP SECTION OF PROPOSED BLEACHERS


OWNER	PROJECT TITLE :	SUBMITTED BY :	RECOMMENDING APPROVAL :	APPROVED BY :	SHEET CONTENTS :	DESIGN BY :		SHEET NO :
<div><div>PHILIPPINE SPORTS COMMISSION RMSG, PABLO OCAMPO SR. ST., MALATE, MANILA</div></div>	<div>UPGRADING OF SWIMMING POOL, DIVING POOL, WARM UP POOL AND CONSTRUCTION OF NEW BLEACHERS,AND JACUZZI</div> <div>LOCATION: RMSG, PABLO OCAMPO SR. ST., MALATE, MANILA</div>	<div>ENGR. PEDRO I. PINEDA JR.</div> <div>HEAD - ENGINEERING UNIT</div>	<div>DIR. MERLITA R. IBAY</div> <div>DEPUTY EXECUTIVE DIRECTOR</div>	<div>HON. WILLIAM I. RAMIREZ</div> <div>CHAIRMAN</div>	AS SHOWN	DRAWN BY :		<div>A</div> <div>10</div>
						CHECKED BY :		
						DATE :		
						APPROVED BY :		

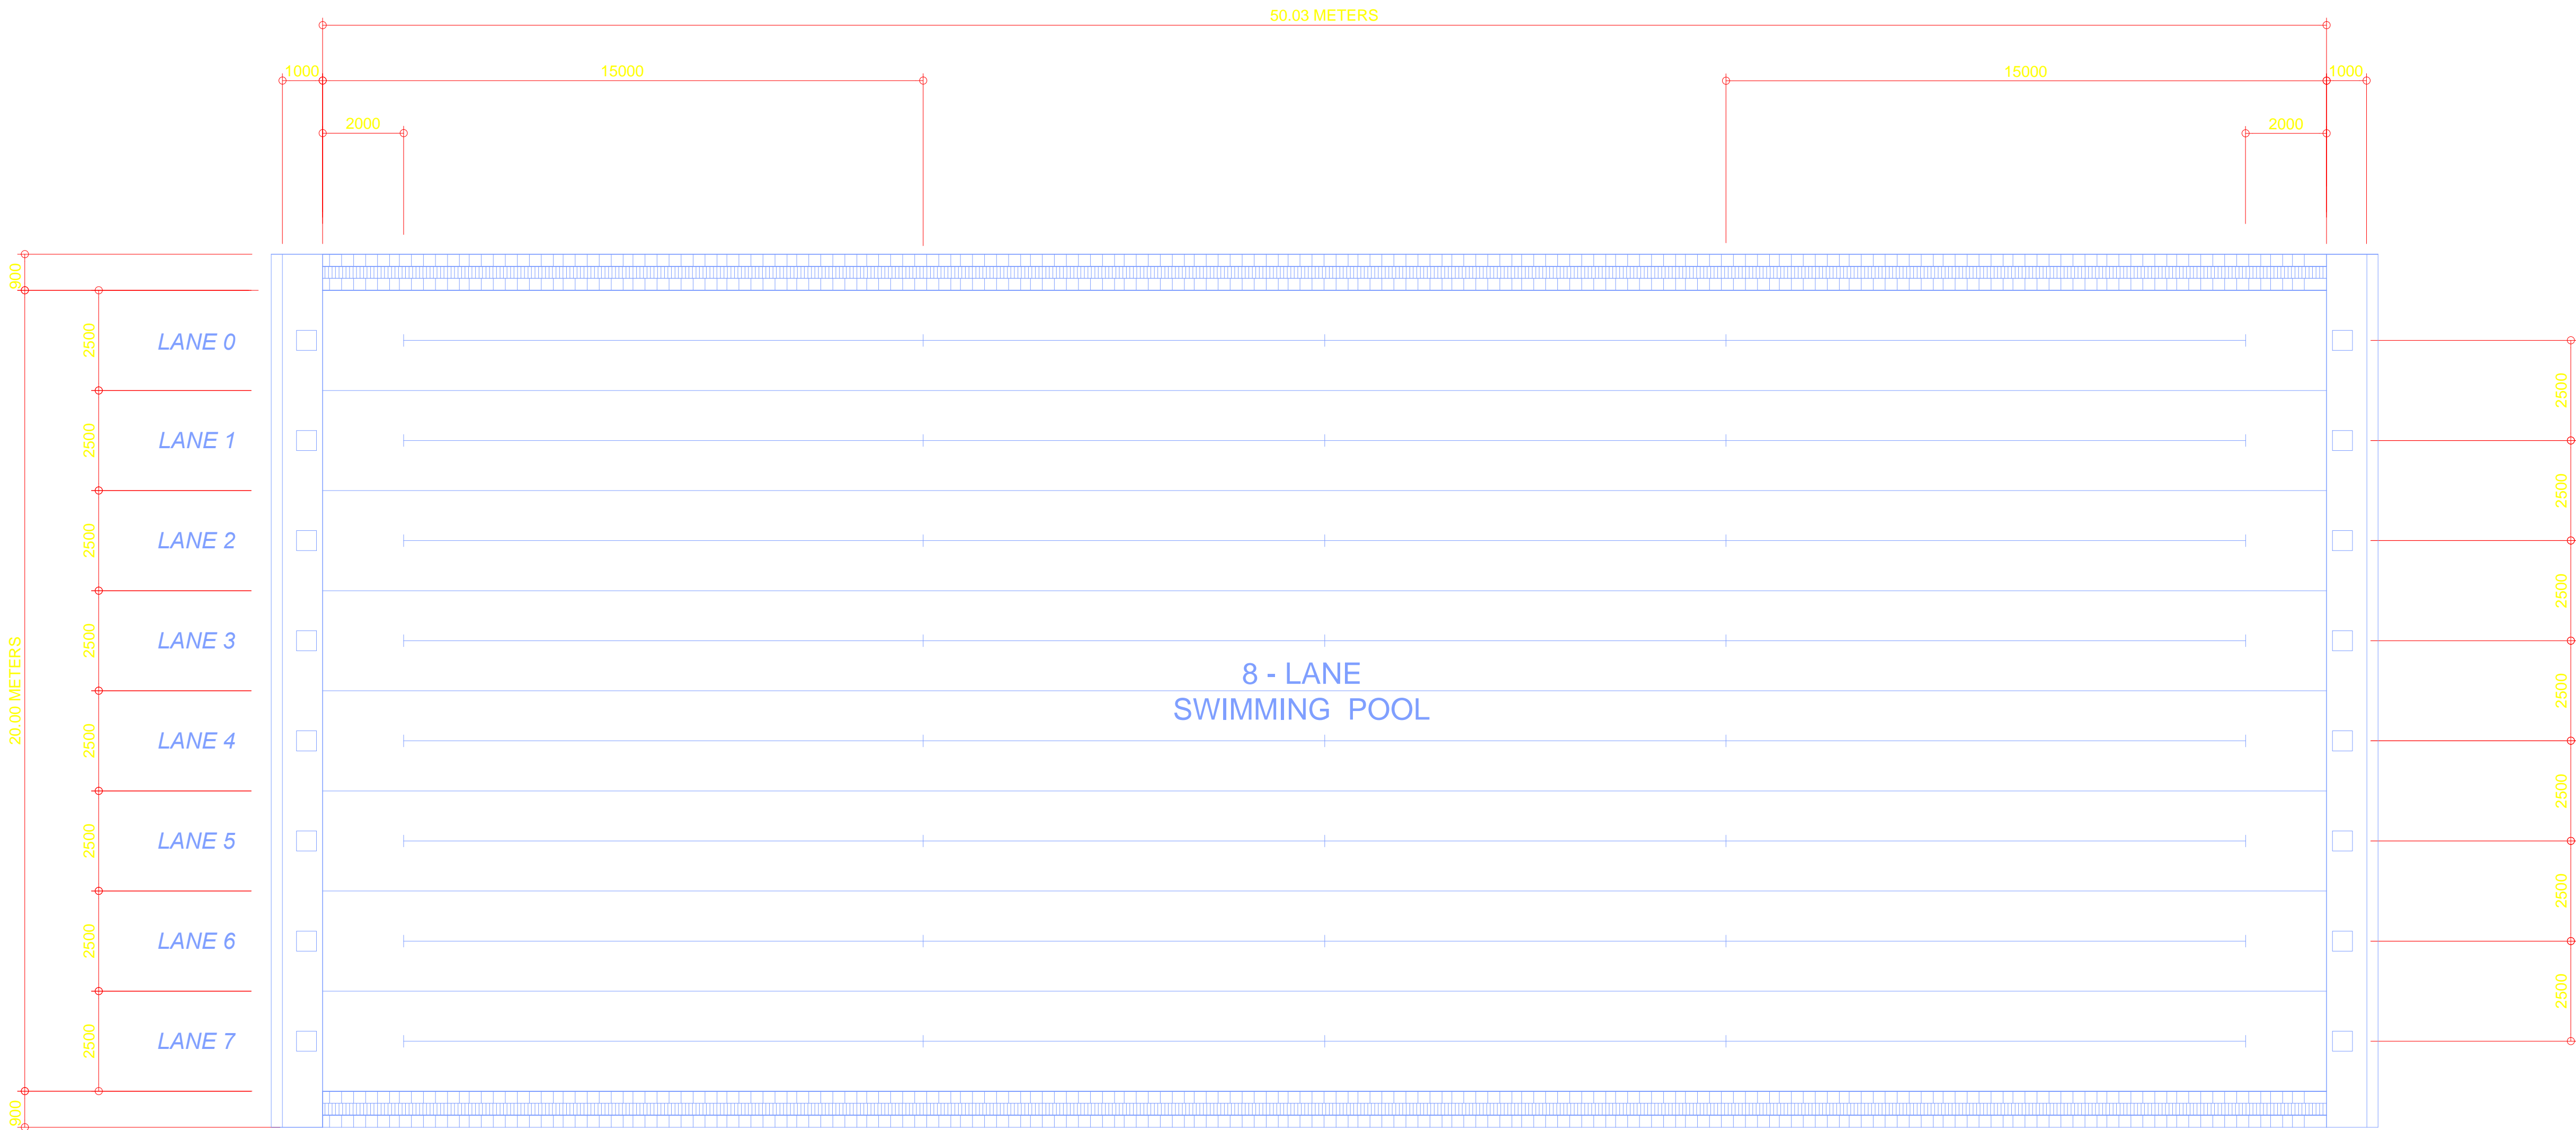

FLOOR PLAN
EXISTING SWIMMING POOL (50.03m. x 20.00m.)

SCALE 1 : 100 MTS.


OWNER	PROJECT TITLE :	SUBMITTED BY :	RECOMMENDING APPROVAL :	APPROVED BY :	SHEET CONTENTS :	DESIGN BY :		SHEET NO :
<div>PHILIPPINE SPORTS COMMISSION RMSC, PABLO OCAMPO SR. ST., MALATE, MANILA</div>	UPGRADING OF SWIMMING POOL, DIVING POOL, WARM UP POOL AND CONSTRUCTION OF NEW BLEACHERS,AND JACUZZI LOCATION: RMSC, PABLO OCAMPO SR. ST., MALATE, MANILA	ENGR. PEDRO I. PINEDA JR. HEAD - ENGINEERING UNIT	DIR. MERLITA R. IBAY DEPUTY EXECUTIVE DIRECTOR	HON. WILLIAM I. RAMIREZ CHAIRMAN	AS SHOWN	DRAWN BY :		<div>A</div> <div>11</div>
						CHECKED BY :		
						DATE :		
						APPROVED BY :		

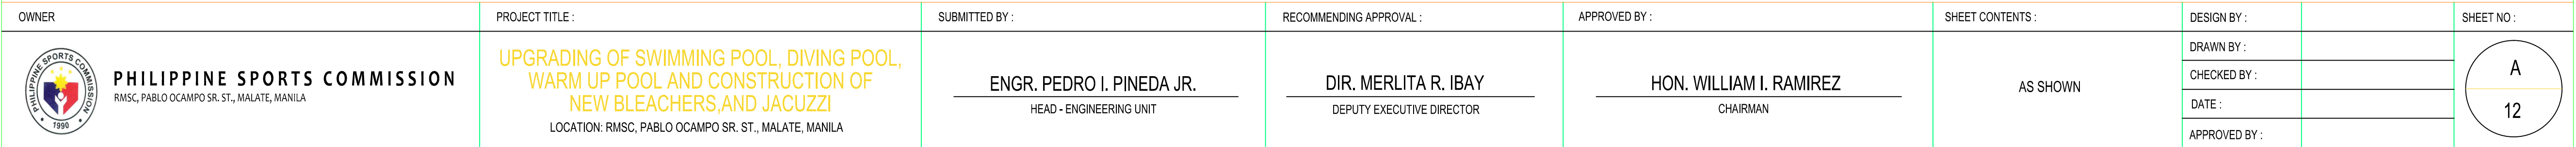




A Venn diagram with two overlapping circles, A and B. The intersection of A and B is shaded in light blue and contains the number 13.


NOTE:
1. THE FLOATER OR LANE LINE SHALL BE ANTI-WAVE
AND WITH APPROPRIATE CLAMP ROPE HOOK.

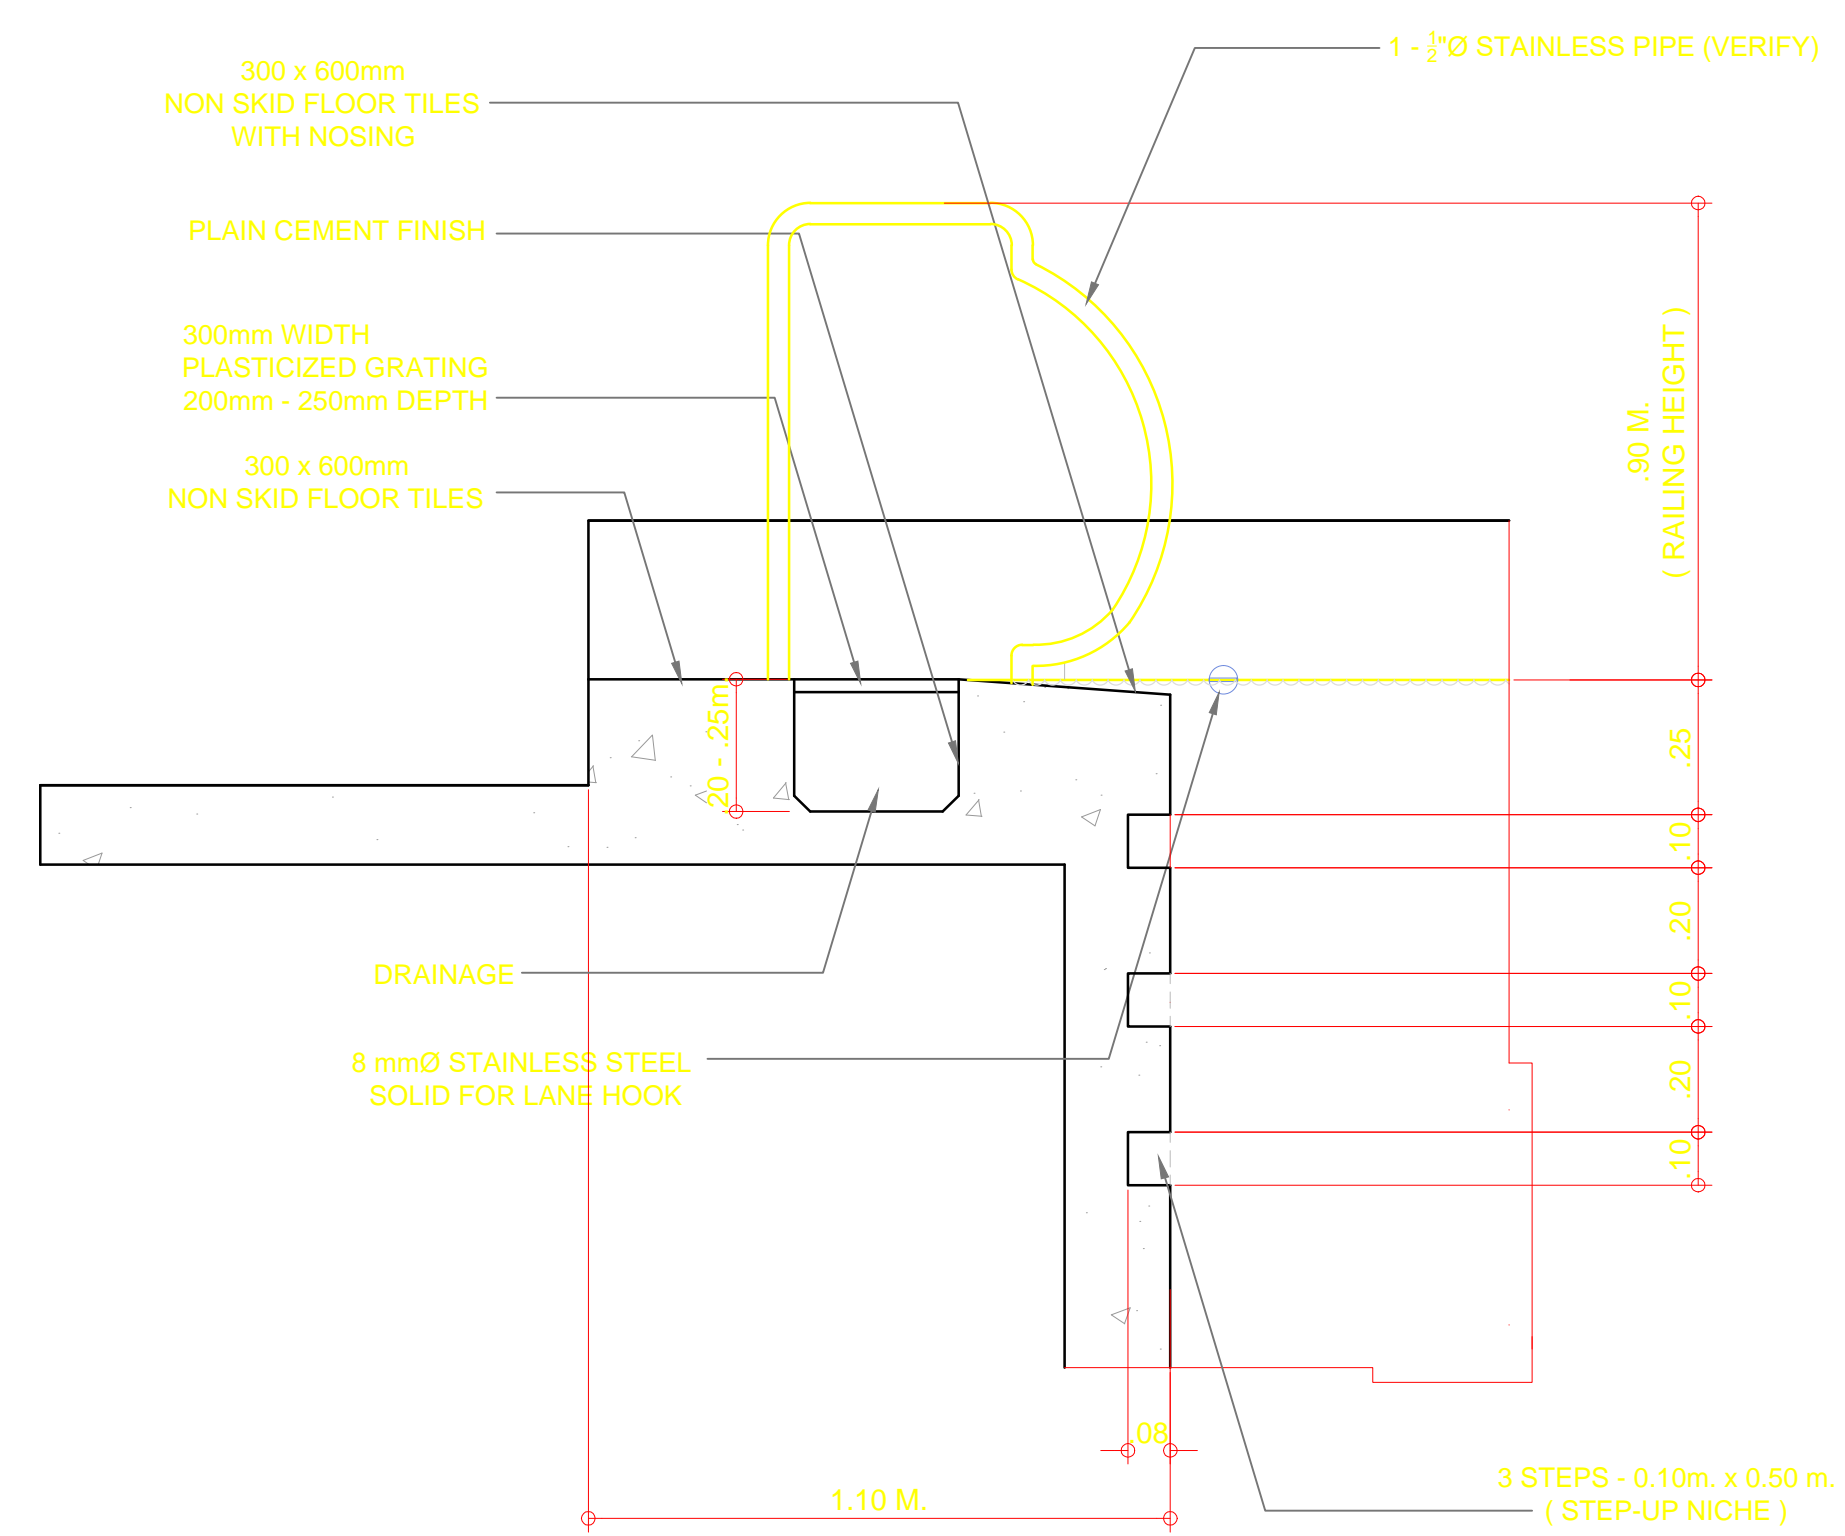



DETAIL OF RAILING AND POOL STEPS
SCALE 1:10 MTS.

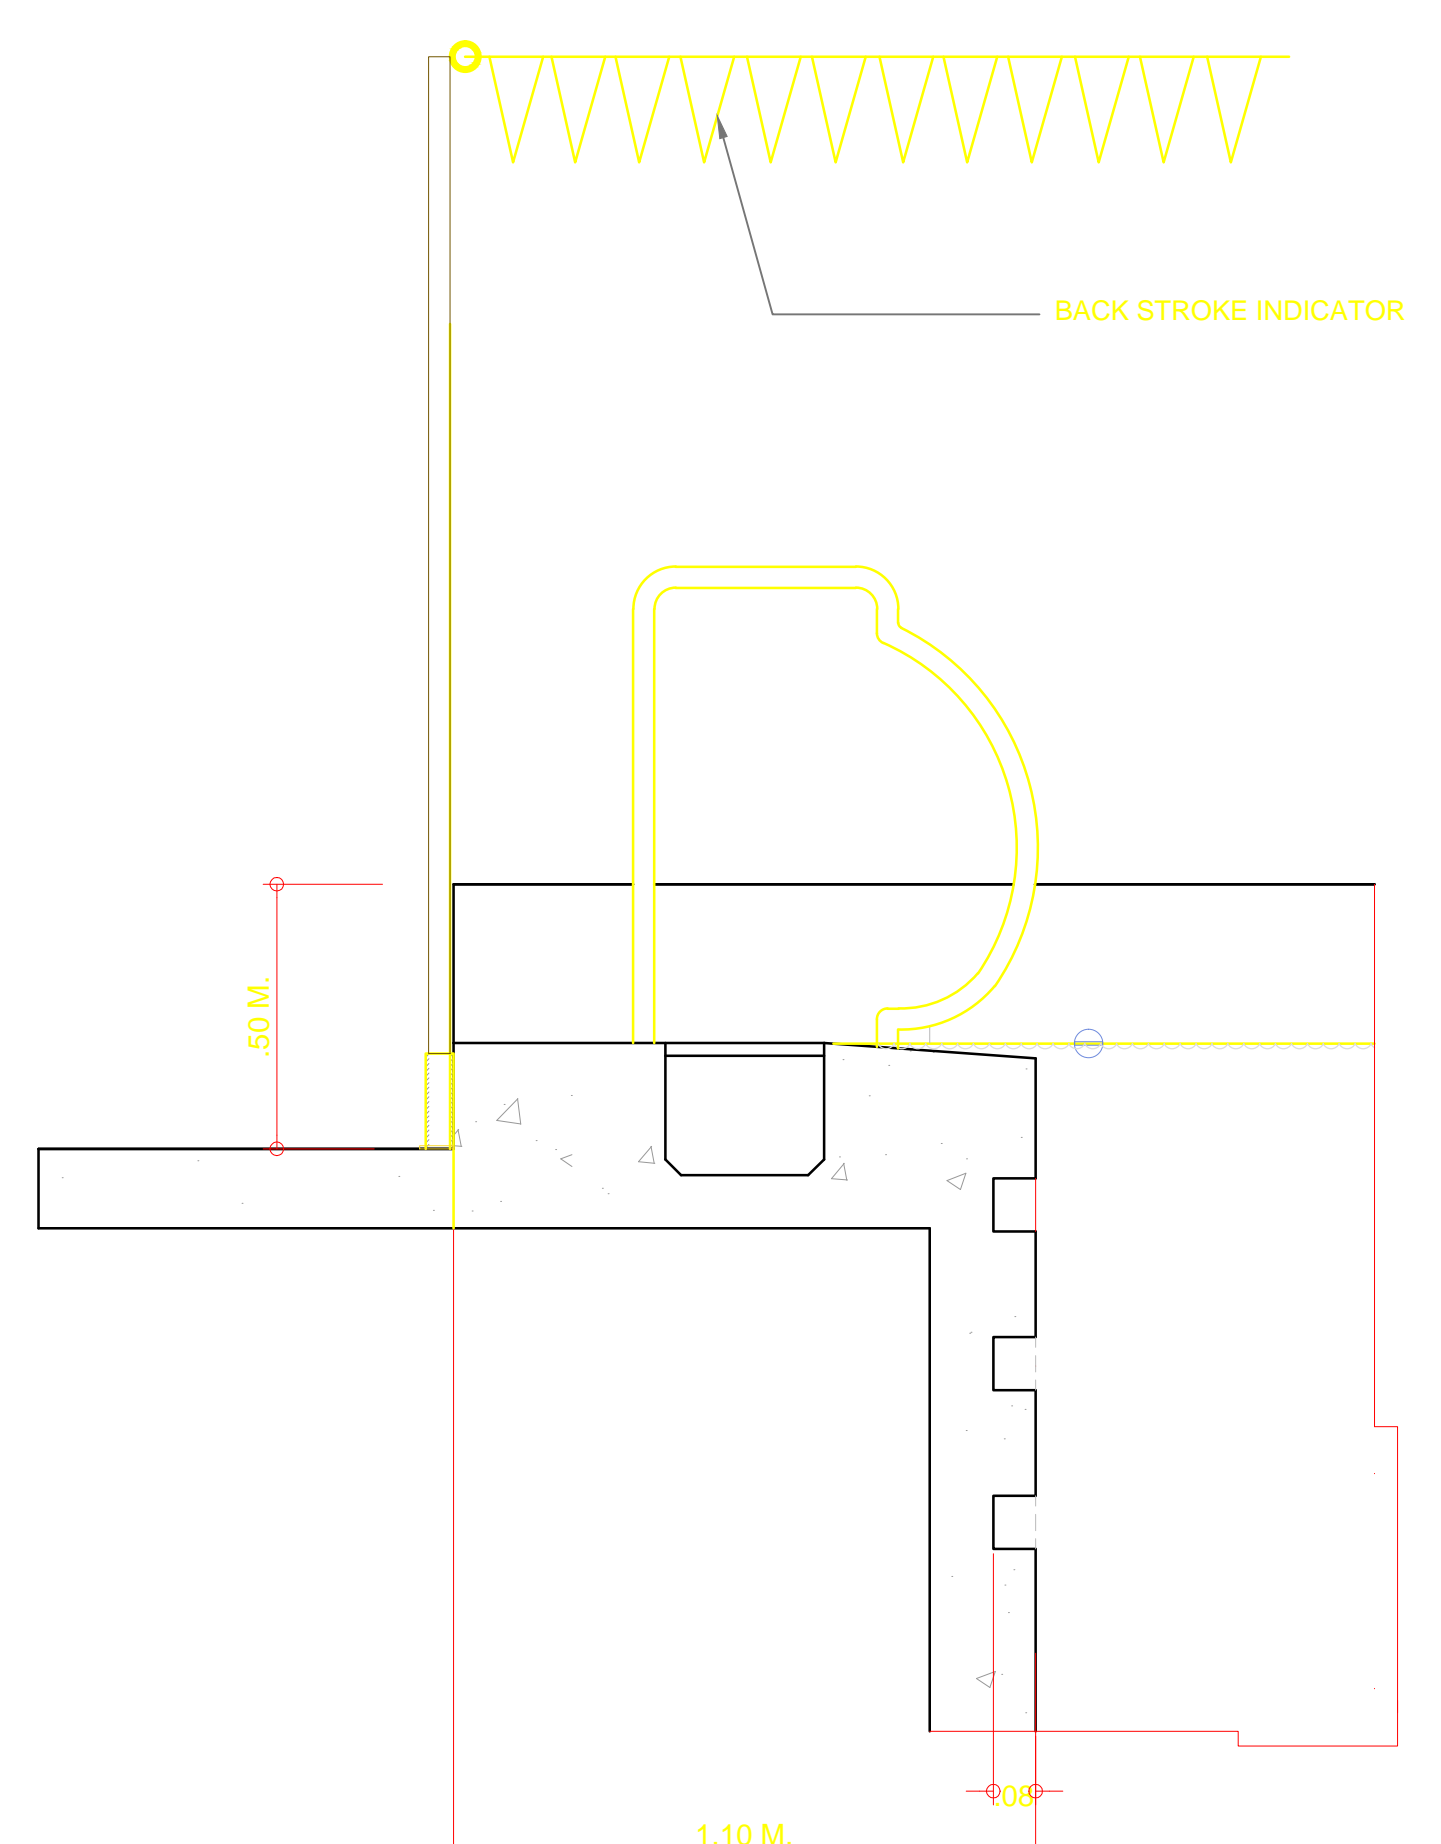


BACKSTROKE INDICATOR
SCALE 1:10 MTS.

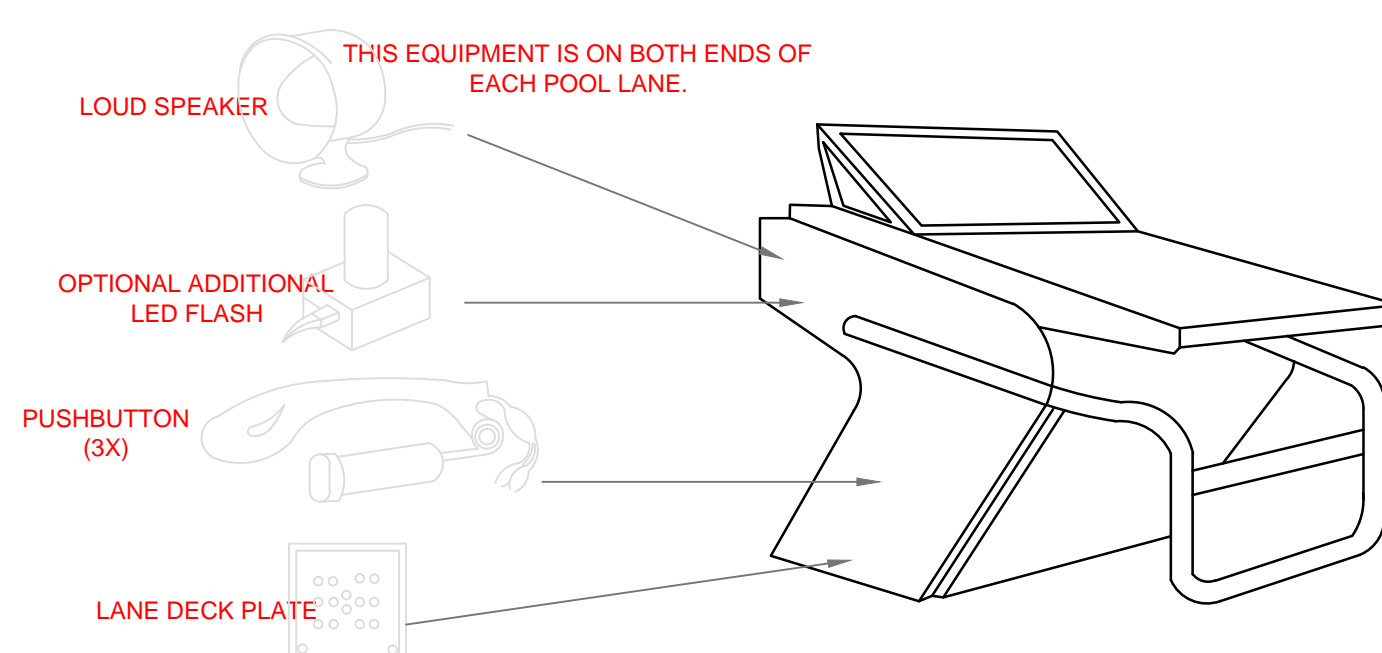


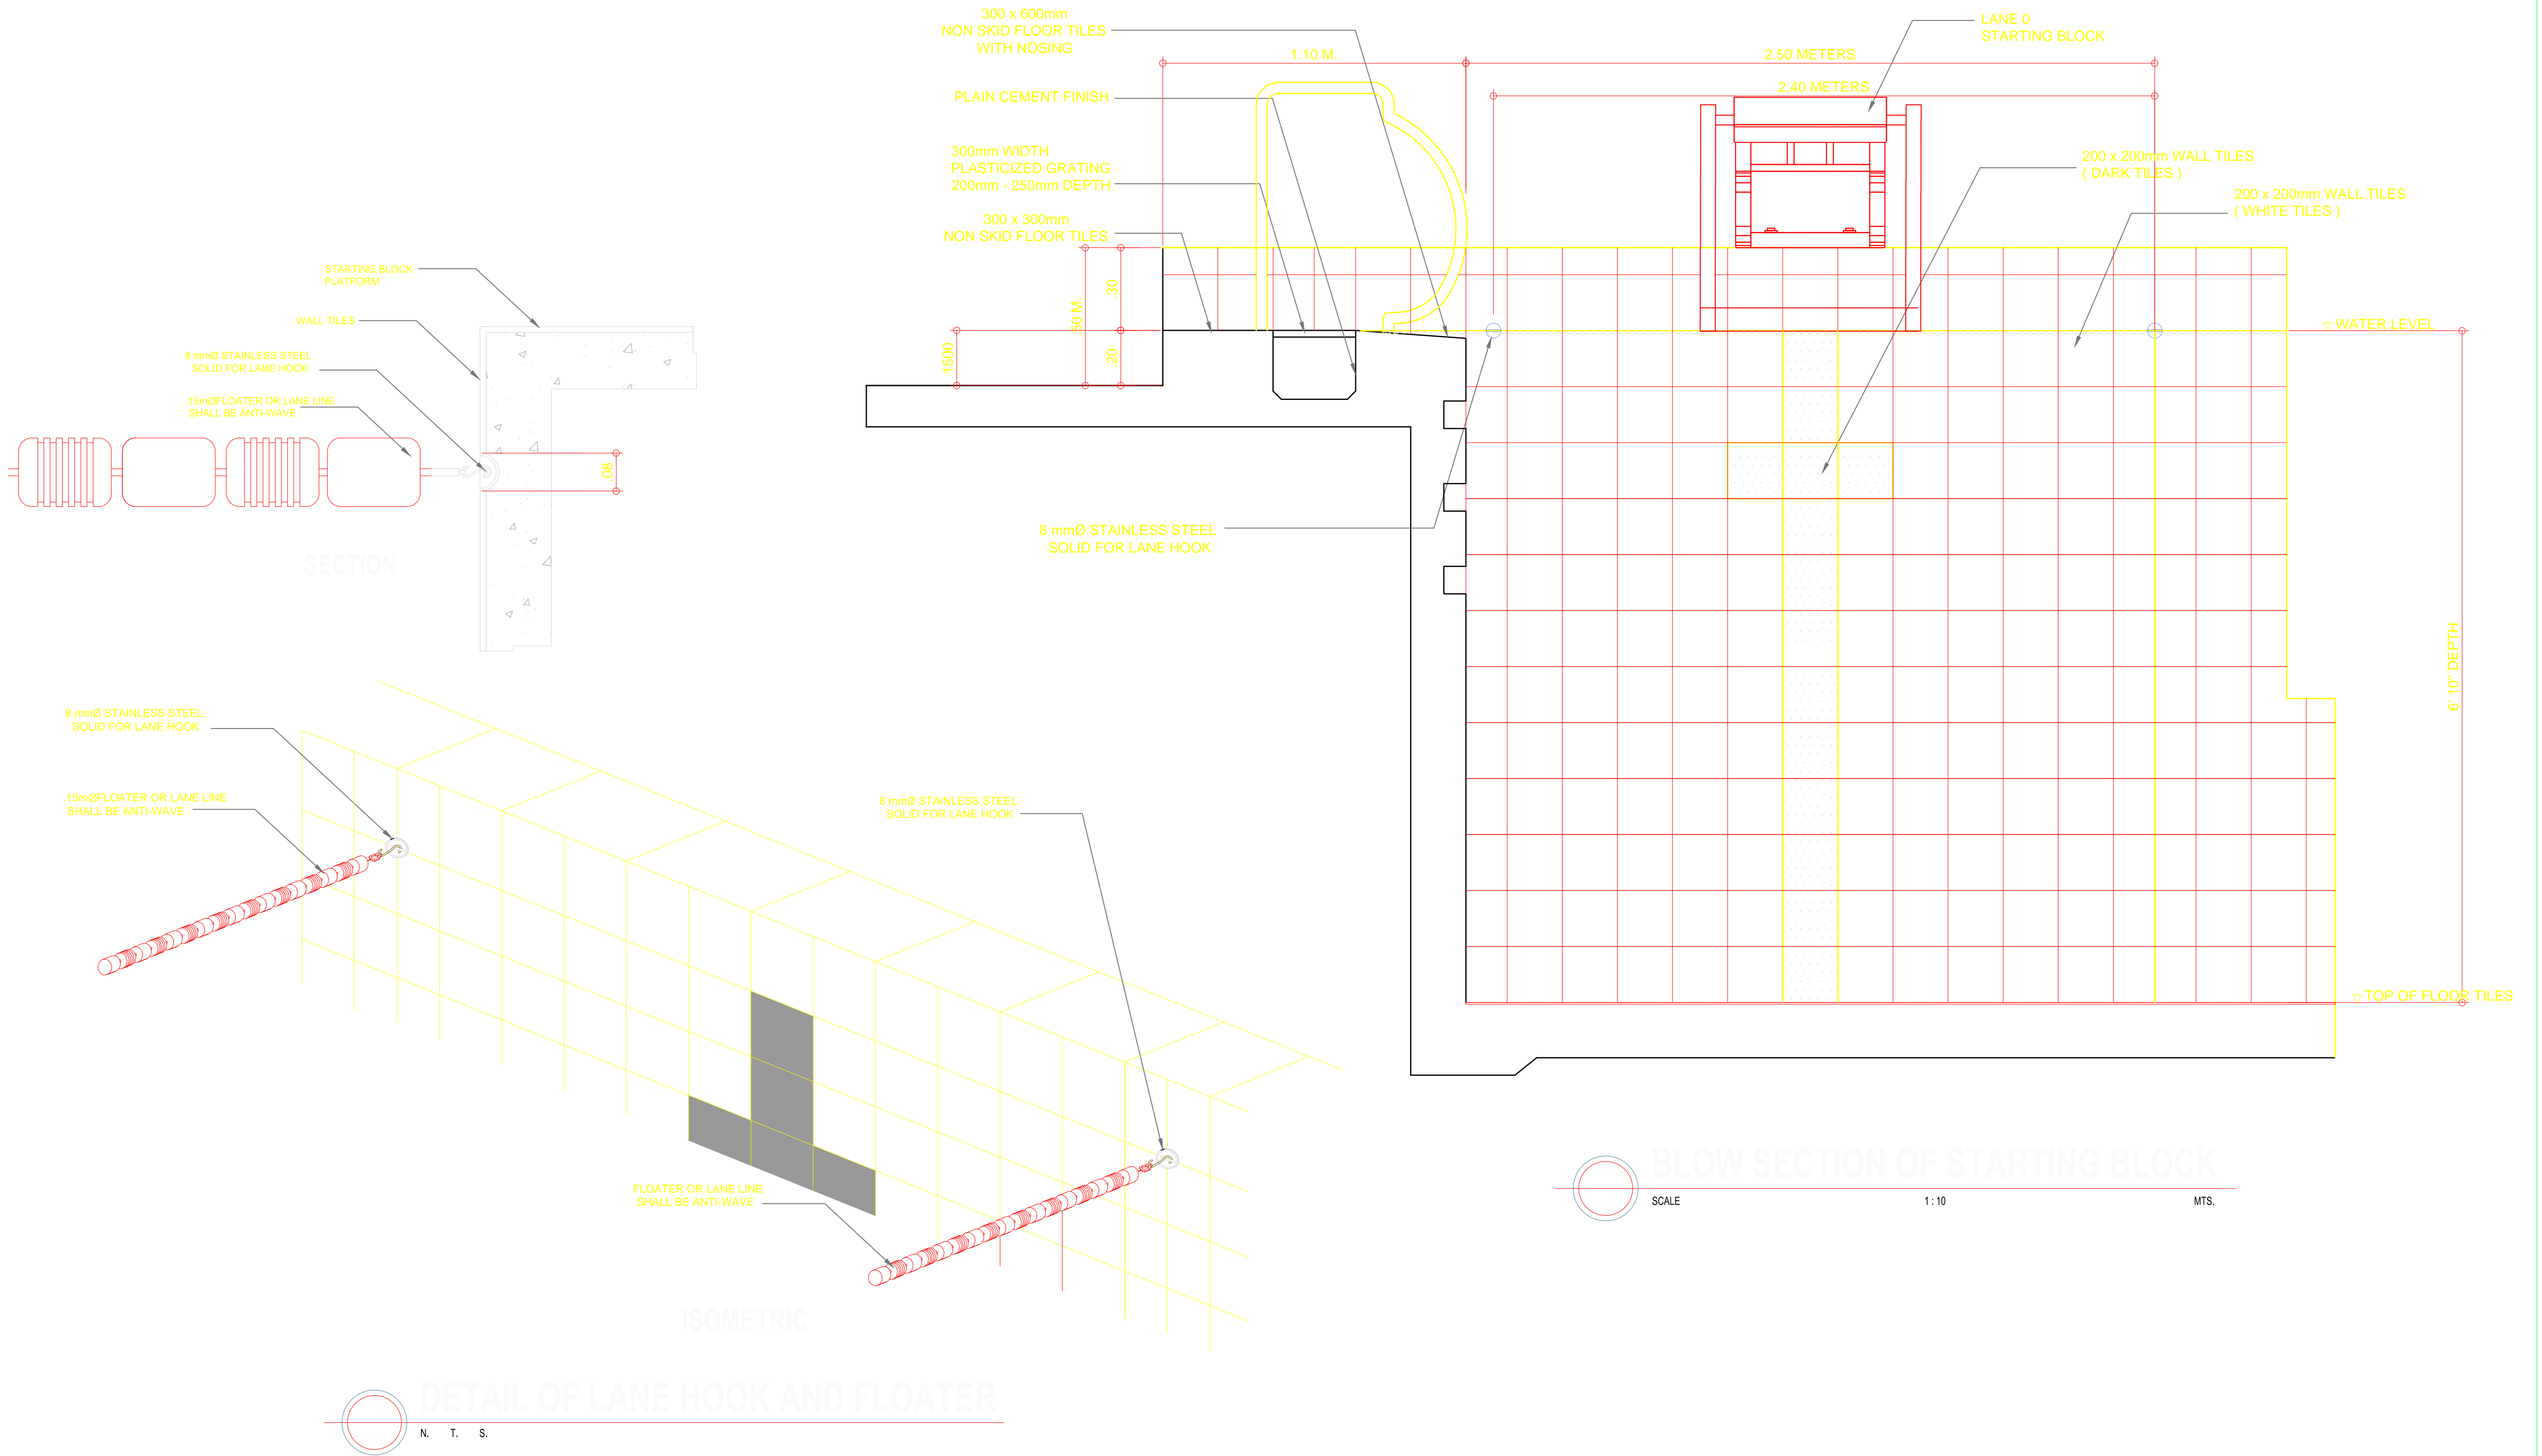
DETAIL OF STARTING BLOCK
N. T. S.

 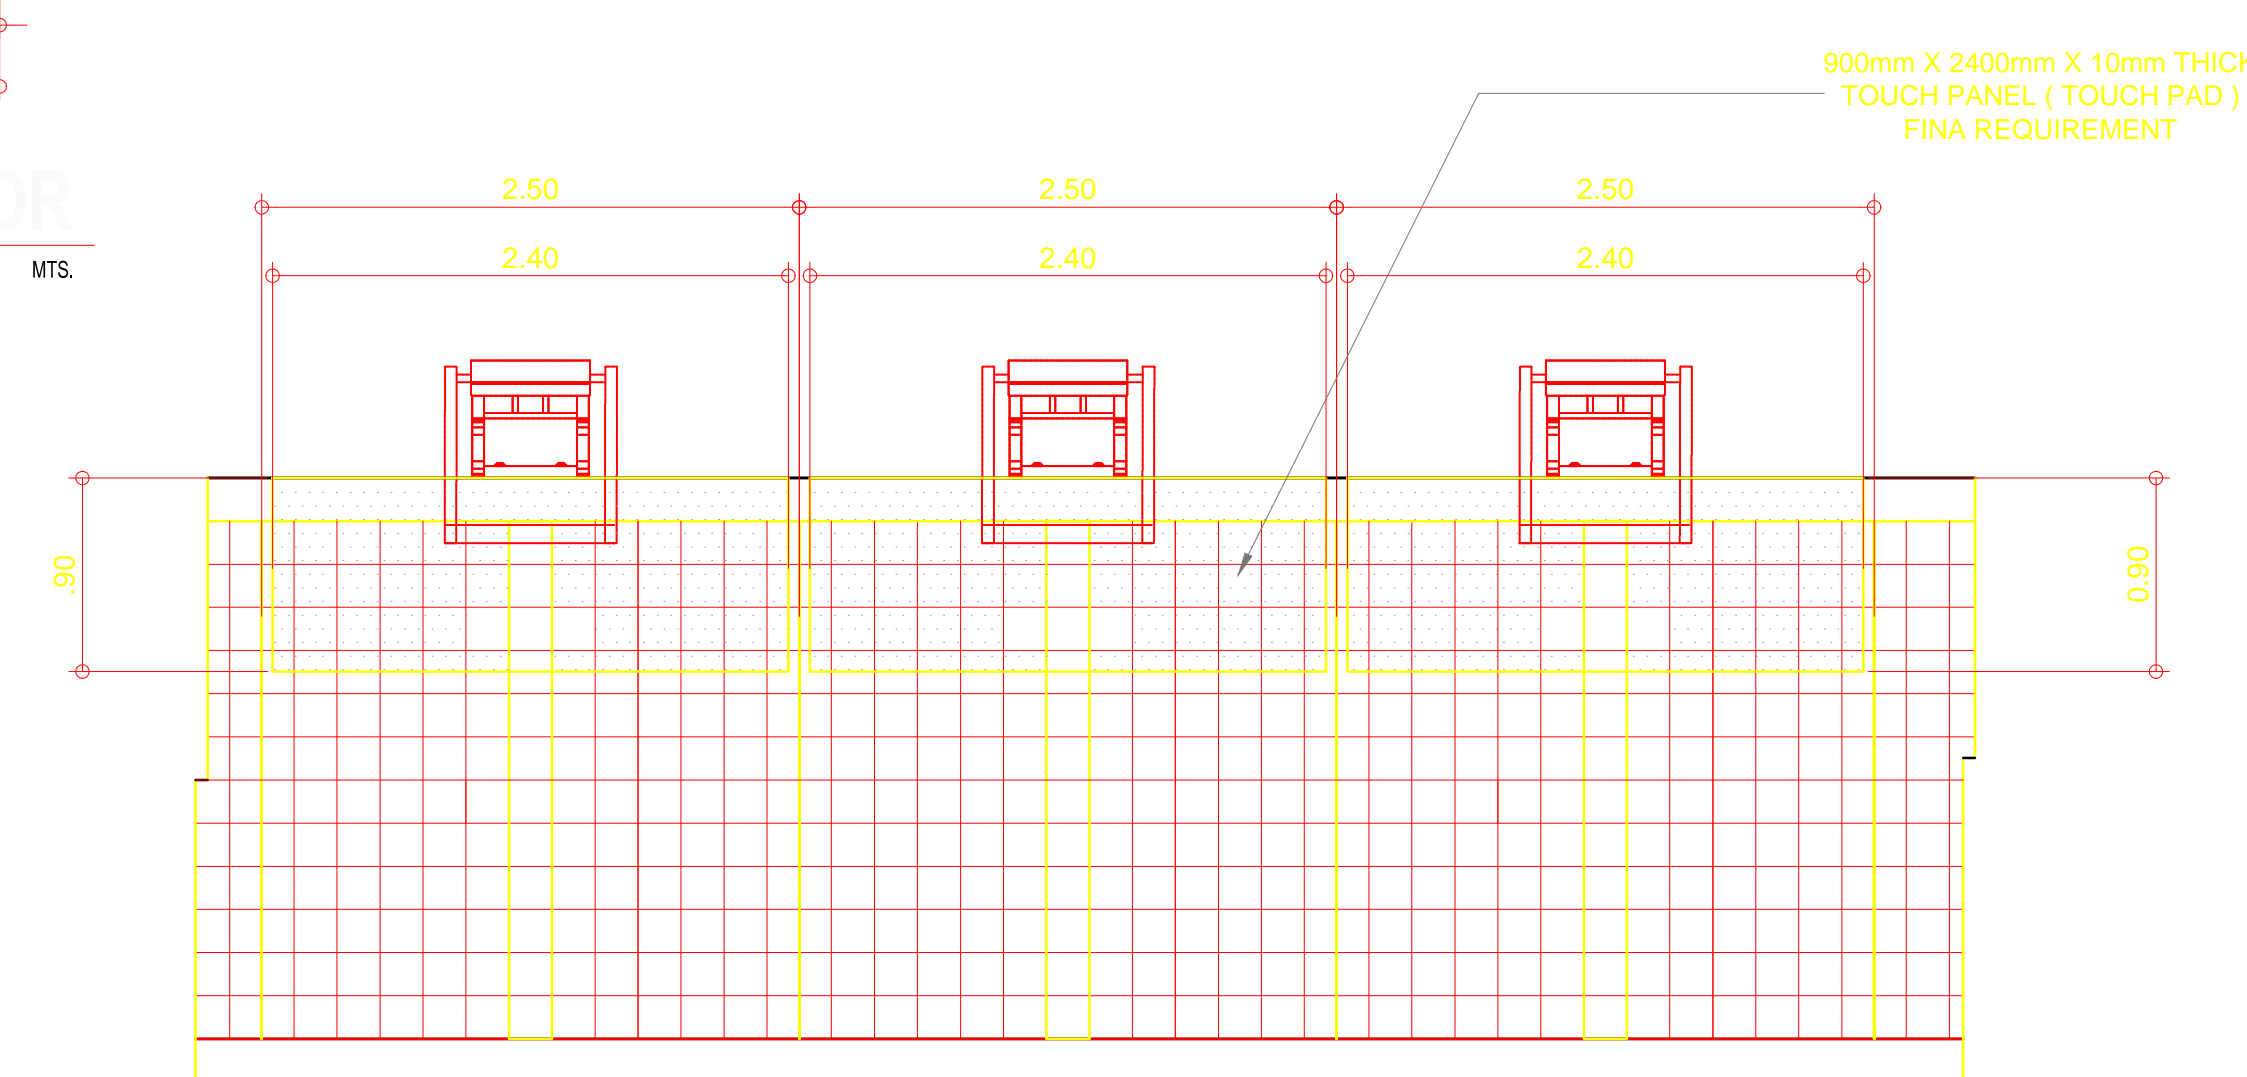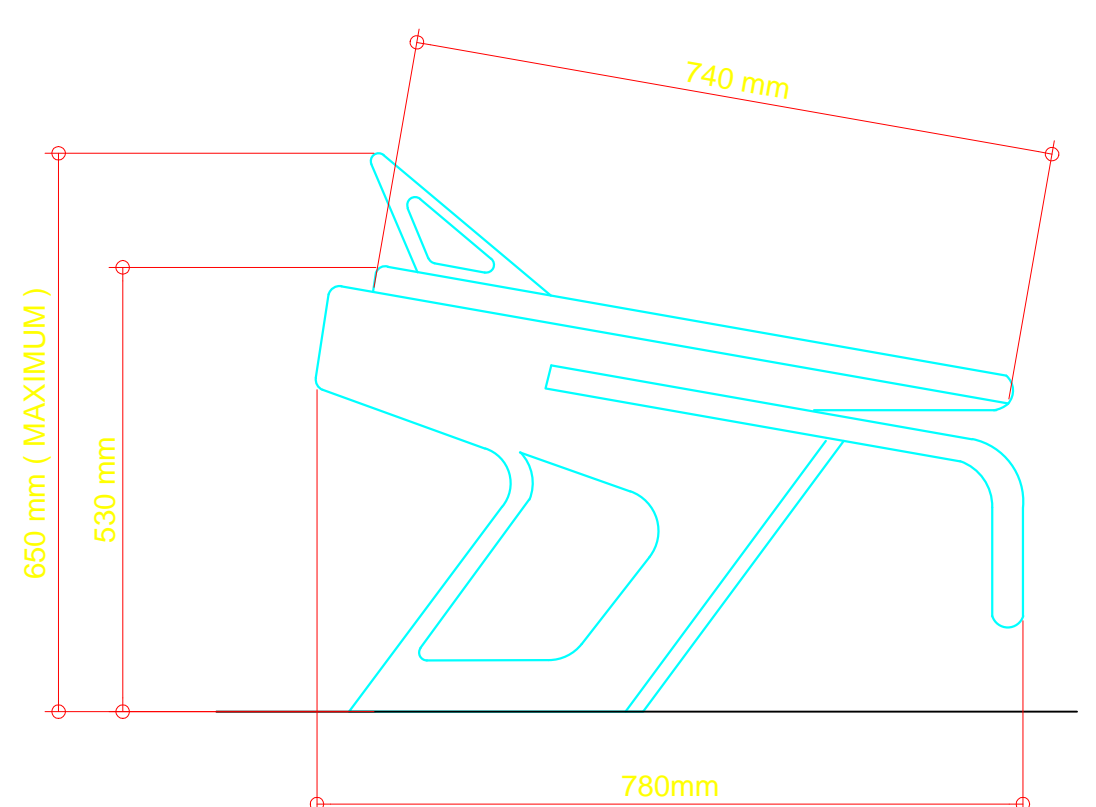



FRONT VIEW
DETAIL OF TOUCH PANEL
N. T. S.

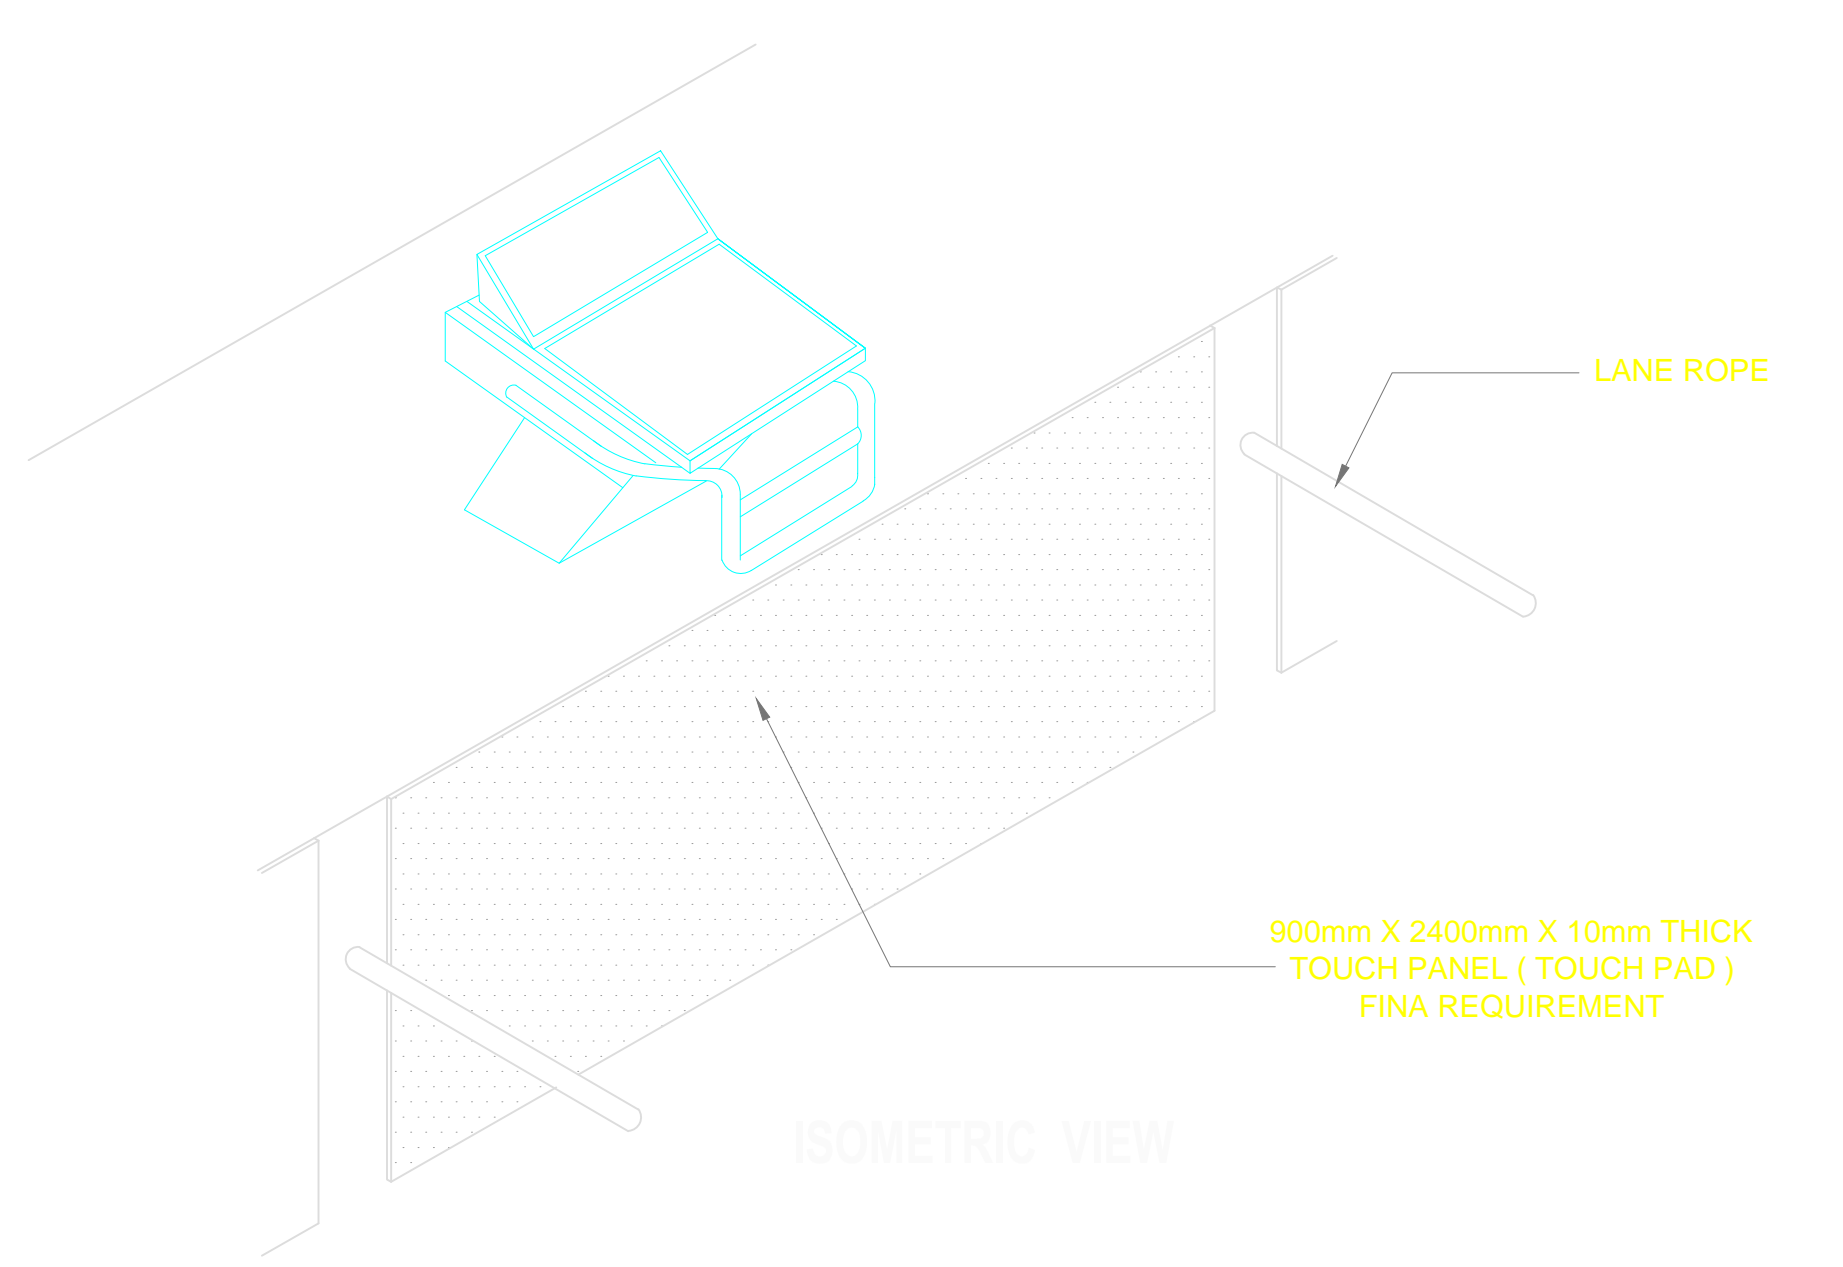


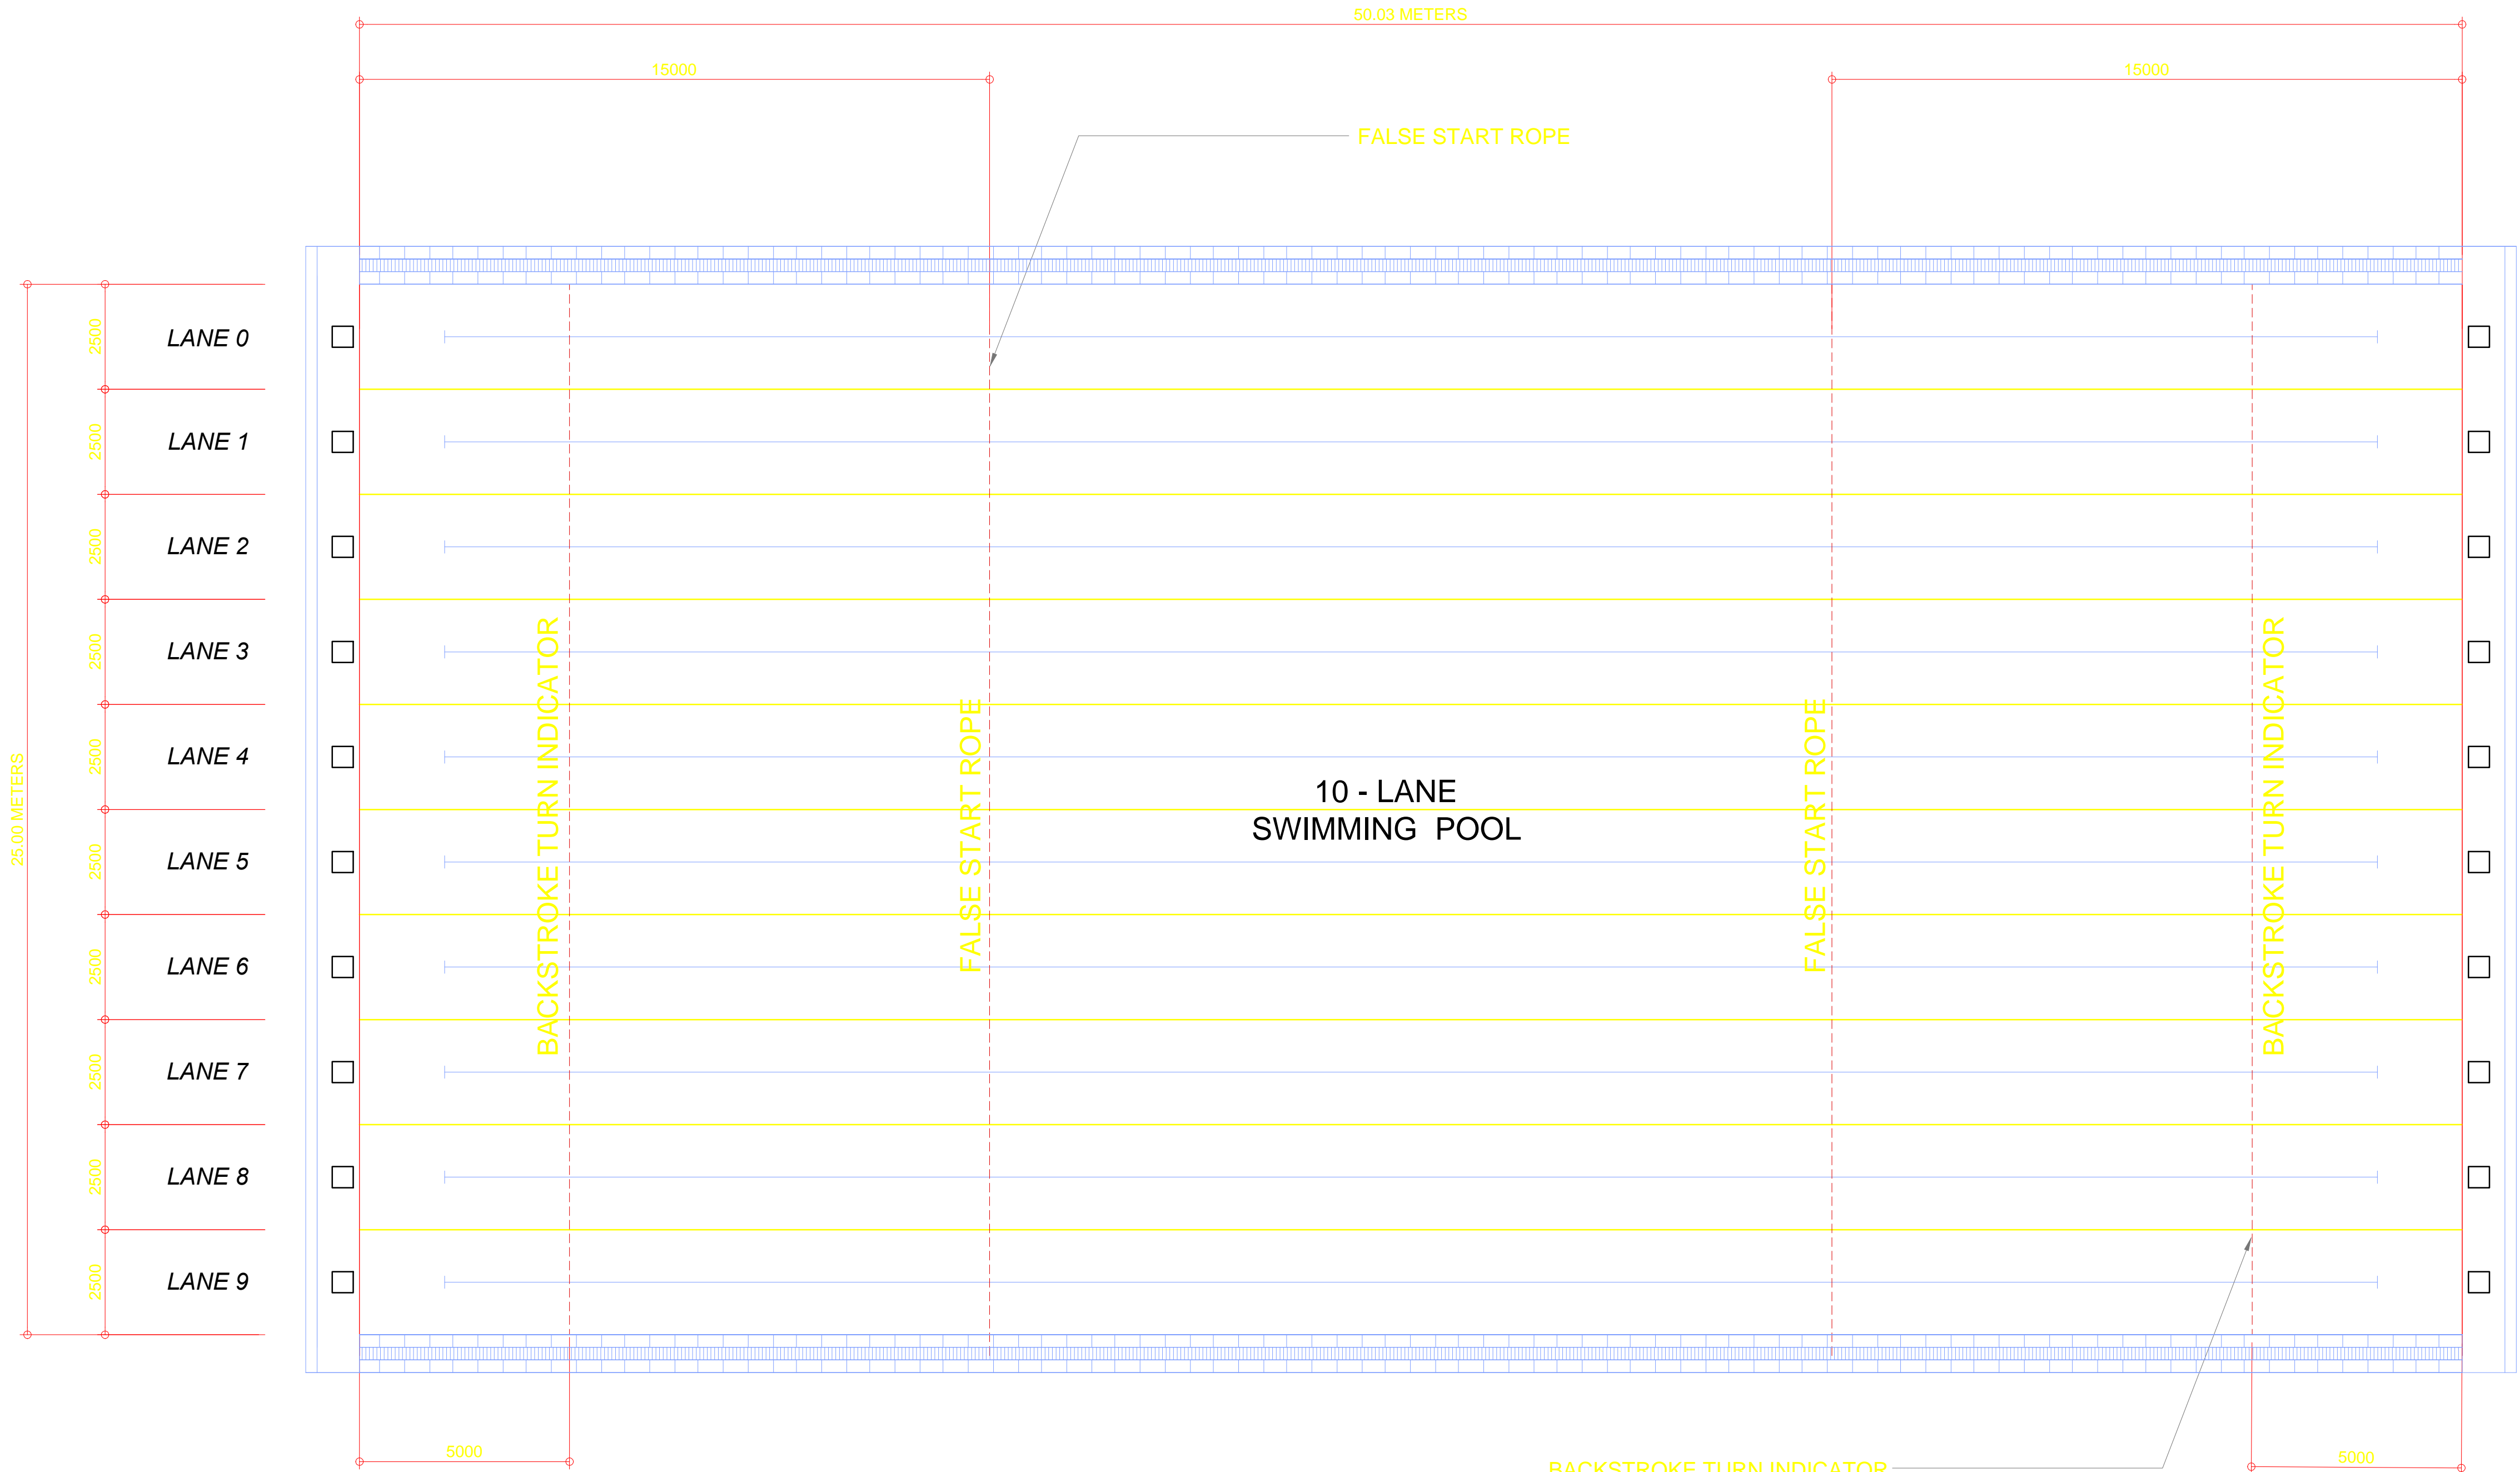
OWNER	PROJECT TITLE :	SUBMITTED BY :	RECOMMENDING APPROVAL :	APPROVED BY :	SHEET CONTENTS :	DESIGN BY :	SHEET NO :
<div><div><div>PHILIPPINE SPORTS COMMISSION</div><div>RMSC, PABLO OCAMPO SR. ST., MALATE, MANILA</div></div></div>	<div>UPGRADING OF SWIMMING POOL, DIVING POOL, WARM UP POOL AND CONSTRUCTION OF NEW BLEACHERS,AND JACUZZI</div> <div>LOCATION: RMSC, PABLO OCAMPO SR. ST., MALATE, MANILA</div>	<div>ENGR. PEDRO I. PINEDA JR.</div> <div>HEAD - ENGINEERING UNIT</div>	<div>DIR. MERLITA R. IBAY</div> <div>DEPUTY EXECUTIVE DIRECTOR</div>	<div>HON. WILLIAM I. RAMIREZ</div> <div>CHAIRMAN</div>	AS SHOWN	DRAWN BY :	<div><div>A</div><div>14</div></div>
						CHECKED BY :	
						DATE :	
						APPROVED BY :	



OWNER	PROJECT TITLE :	SUBMITTED BY :	RECOMMENDING APPROVAL :	APPROVED BY :	SHEET CONTENTS :	DESIGN BY :	SHEET NO :
<div><div>PHILIPPINE SPORTS COMMISSION RMSC, PABLO OCAMPO SR. ST., MALATE, MANILA</div></div>	<div>UPGRADING OF SWIMMING POOL, DIVING POOL, WARM UP POOL AND CONSTRUCTION OF NEW BLEACHERS,AND JACUZZI</div> <div>LOCATION: RMSC, PABLO OCAMPO SR. ST., MALATE, MANILA</div>	<div>ENGR. PEDRO I. PINEDA JR.</div> <div>HEAD - ENGINEERING UNIT</div>	<div>DIR. MERLITA R. IBAY</div> <div>DEPUTY EXECUTIVE DIRECTOR</div>	<div>HON. WILLIAM I. RAMIREZ</div> <div>CHAIRMAN</div>	AS SHOWN	DRAWN BY :	<div>A</div> <div>15</div>
					CHECKED BY :		
					DATE :		
					APPROVED BY :		

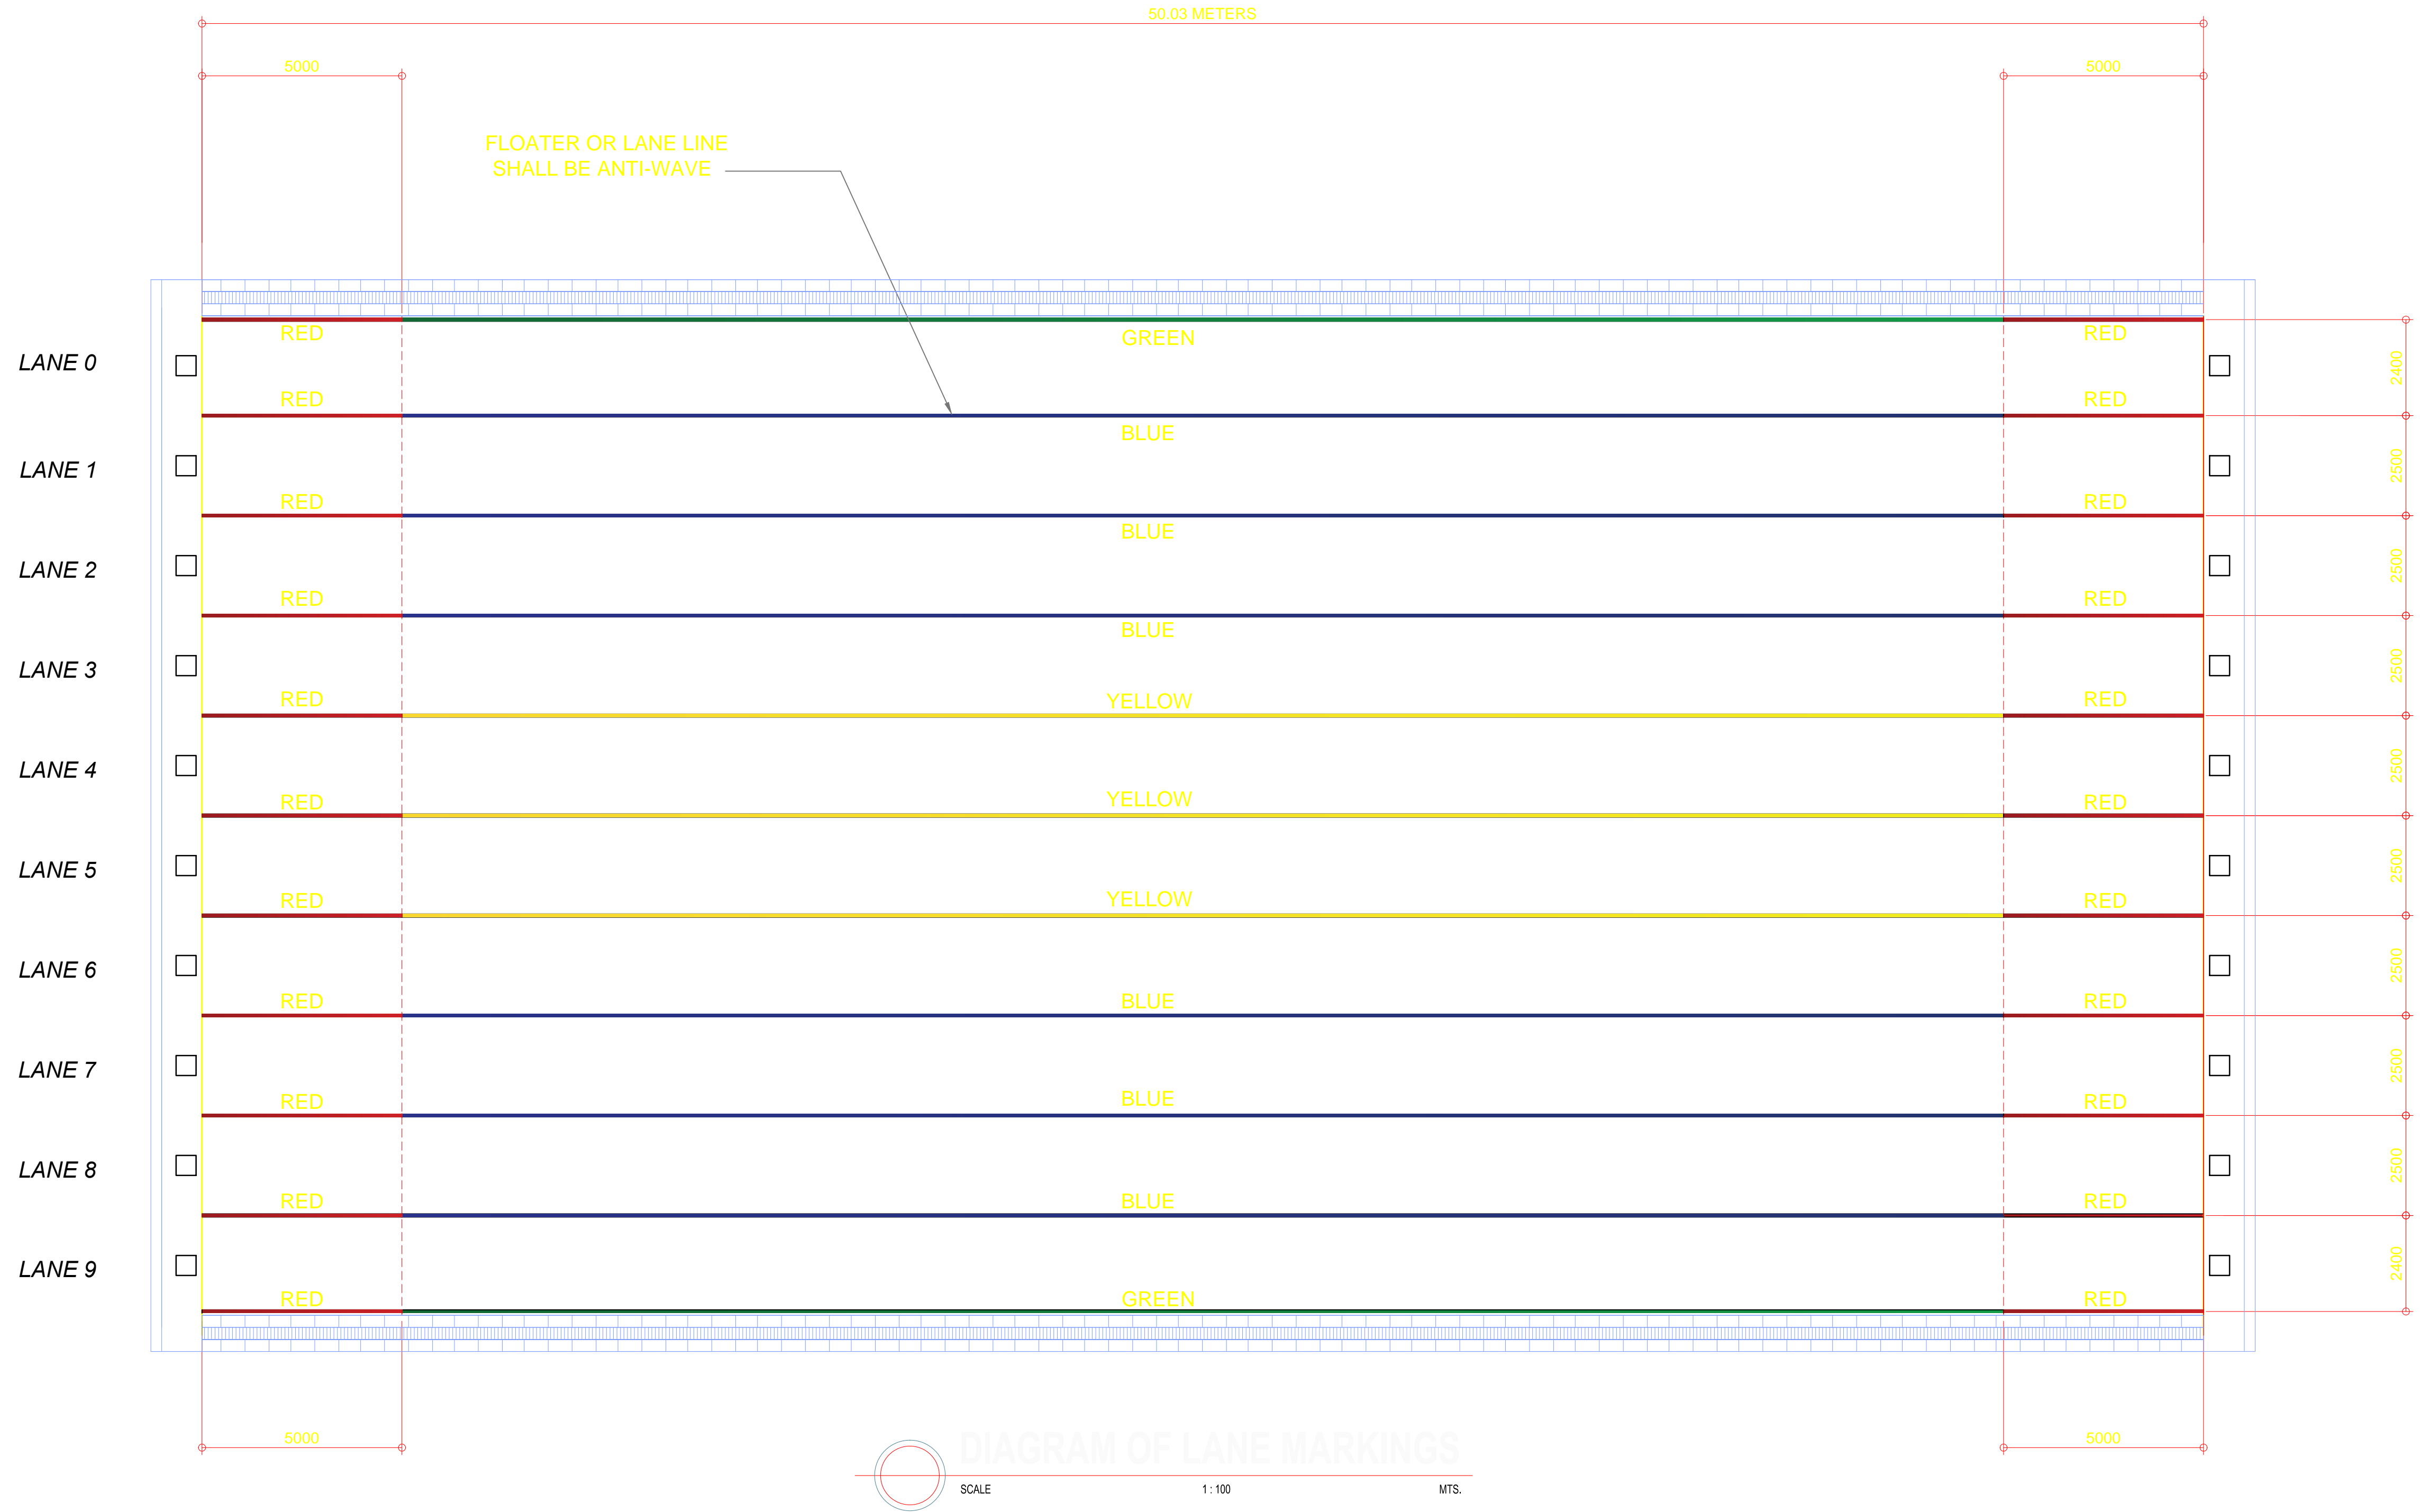


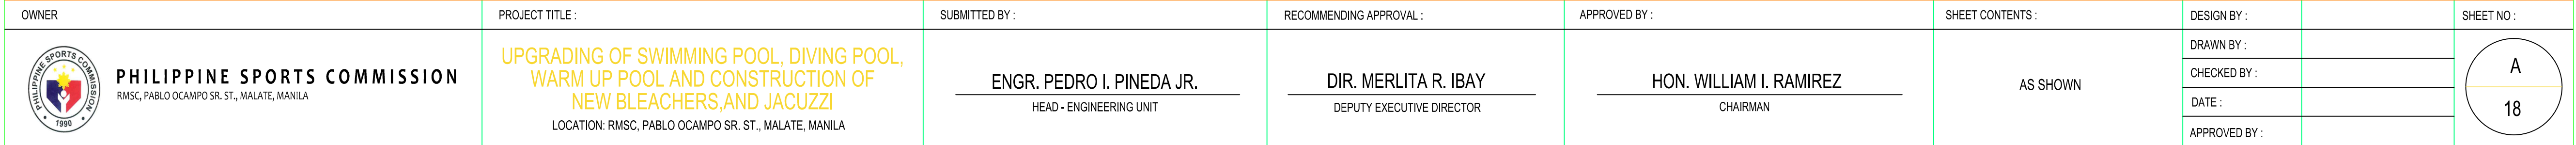
OWNER	PROJECT TITLE :	SUBMITTED BY :	RECOMMENDING APPROVAL :	APPROVED BY :	SHEET CONTENTS :	DESIGN BY :		SHEET NO :
 PHILIPPINE SPORTS COMMISSION RMSG, PABLO OCAMPO SR. ST., MALATE, MANILA	UPGRADING OF SWIMMING POOL, DIVING POOL, WARM UP POOL AND CONSTRUCTION OF NEW BLEACHERS,AND JACUZZI LOCATION: RMSG, PABLO OCAMPO SR. ST., MALATE, MANILA	ENGR. PEDRO I. PINEDA JR. HEAD - ENGINEERING UNIT	DIR. MERLITA R. IBAY DEPUTY EXECUTIVE DIRECTOR	HON. WILLIAM I. RAMIREZ CHAIRMAN	AS SHOWN	DRAWN BY :		<div>A</div> <div>16</div>
						CHECKED BY :		
						DATE :		
						APPROVED BY :		




LOCATION OF FALSE START AND
BACKSTROKE TURN INDICATOR

SCALE 1:100 MTS.


OWNER	PROJECT TITLE :	SUBMITTED BY :	RECOMMENDING APPROVAL :	APPROVED BY :	SHEET CONTENTS :	DESIGN BY :		SHEET NO :
<div><div>PHILIPPINE SPORTS COMMISSION RMSG, PABLO OCAMPO SR. ST., MALATE, MANILA</div></div>	<div>UPGRADING OF SWIMMING POOL, DIVING POOL, WARM UP POOL AND CONSTRUCTION OF NEW BLEACHERS,AND JACUZZI</div> <div>LOCATION: RMSG, PABLO OCAMPO SR. ST., MALATE, MANILA</div>	<div>ENGR. PEDRO I. PINEDA JR.</div> <div>HEAD - ENGINEERING UNIT</div>	<div>DIR. MERLITA R. IBAY</div> <div>DEPUTY EXECUTIVE DIRECTOR</div>	<div>HON. WILLIAM I. RAMIREZ</div> <div>CHAIRMAN</div>	AS SHOWN	DRAWN BY :		<div><div>A</div><div>17</div></div>
						CHECKED BY :		
						DATE :		
						APPROVED BY :		




 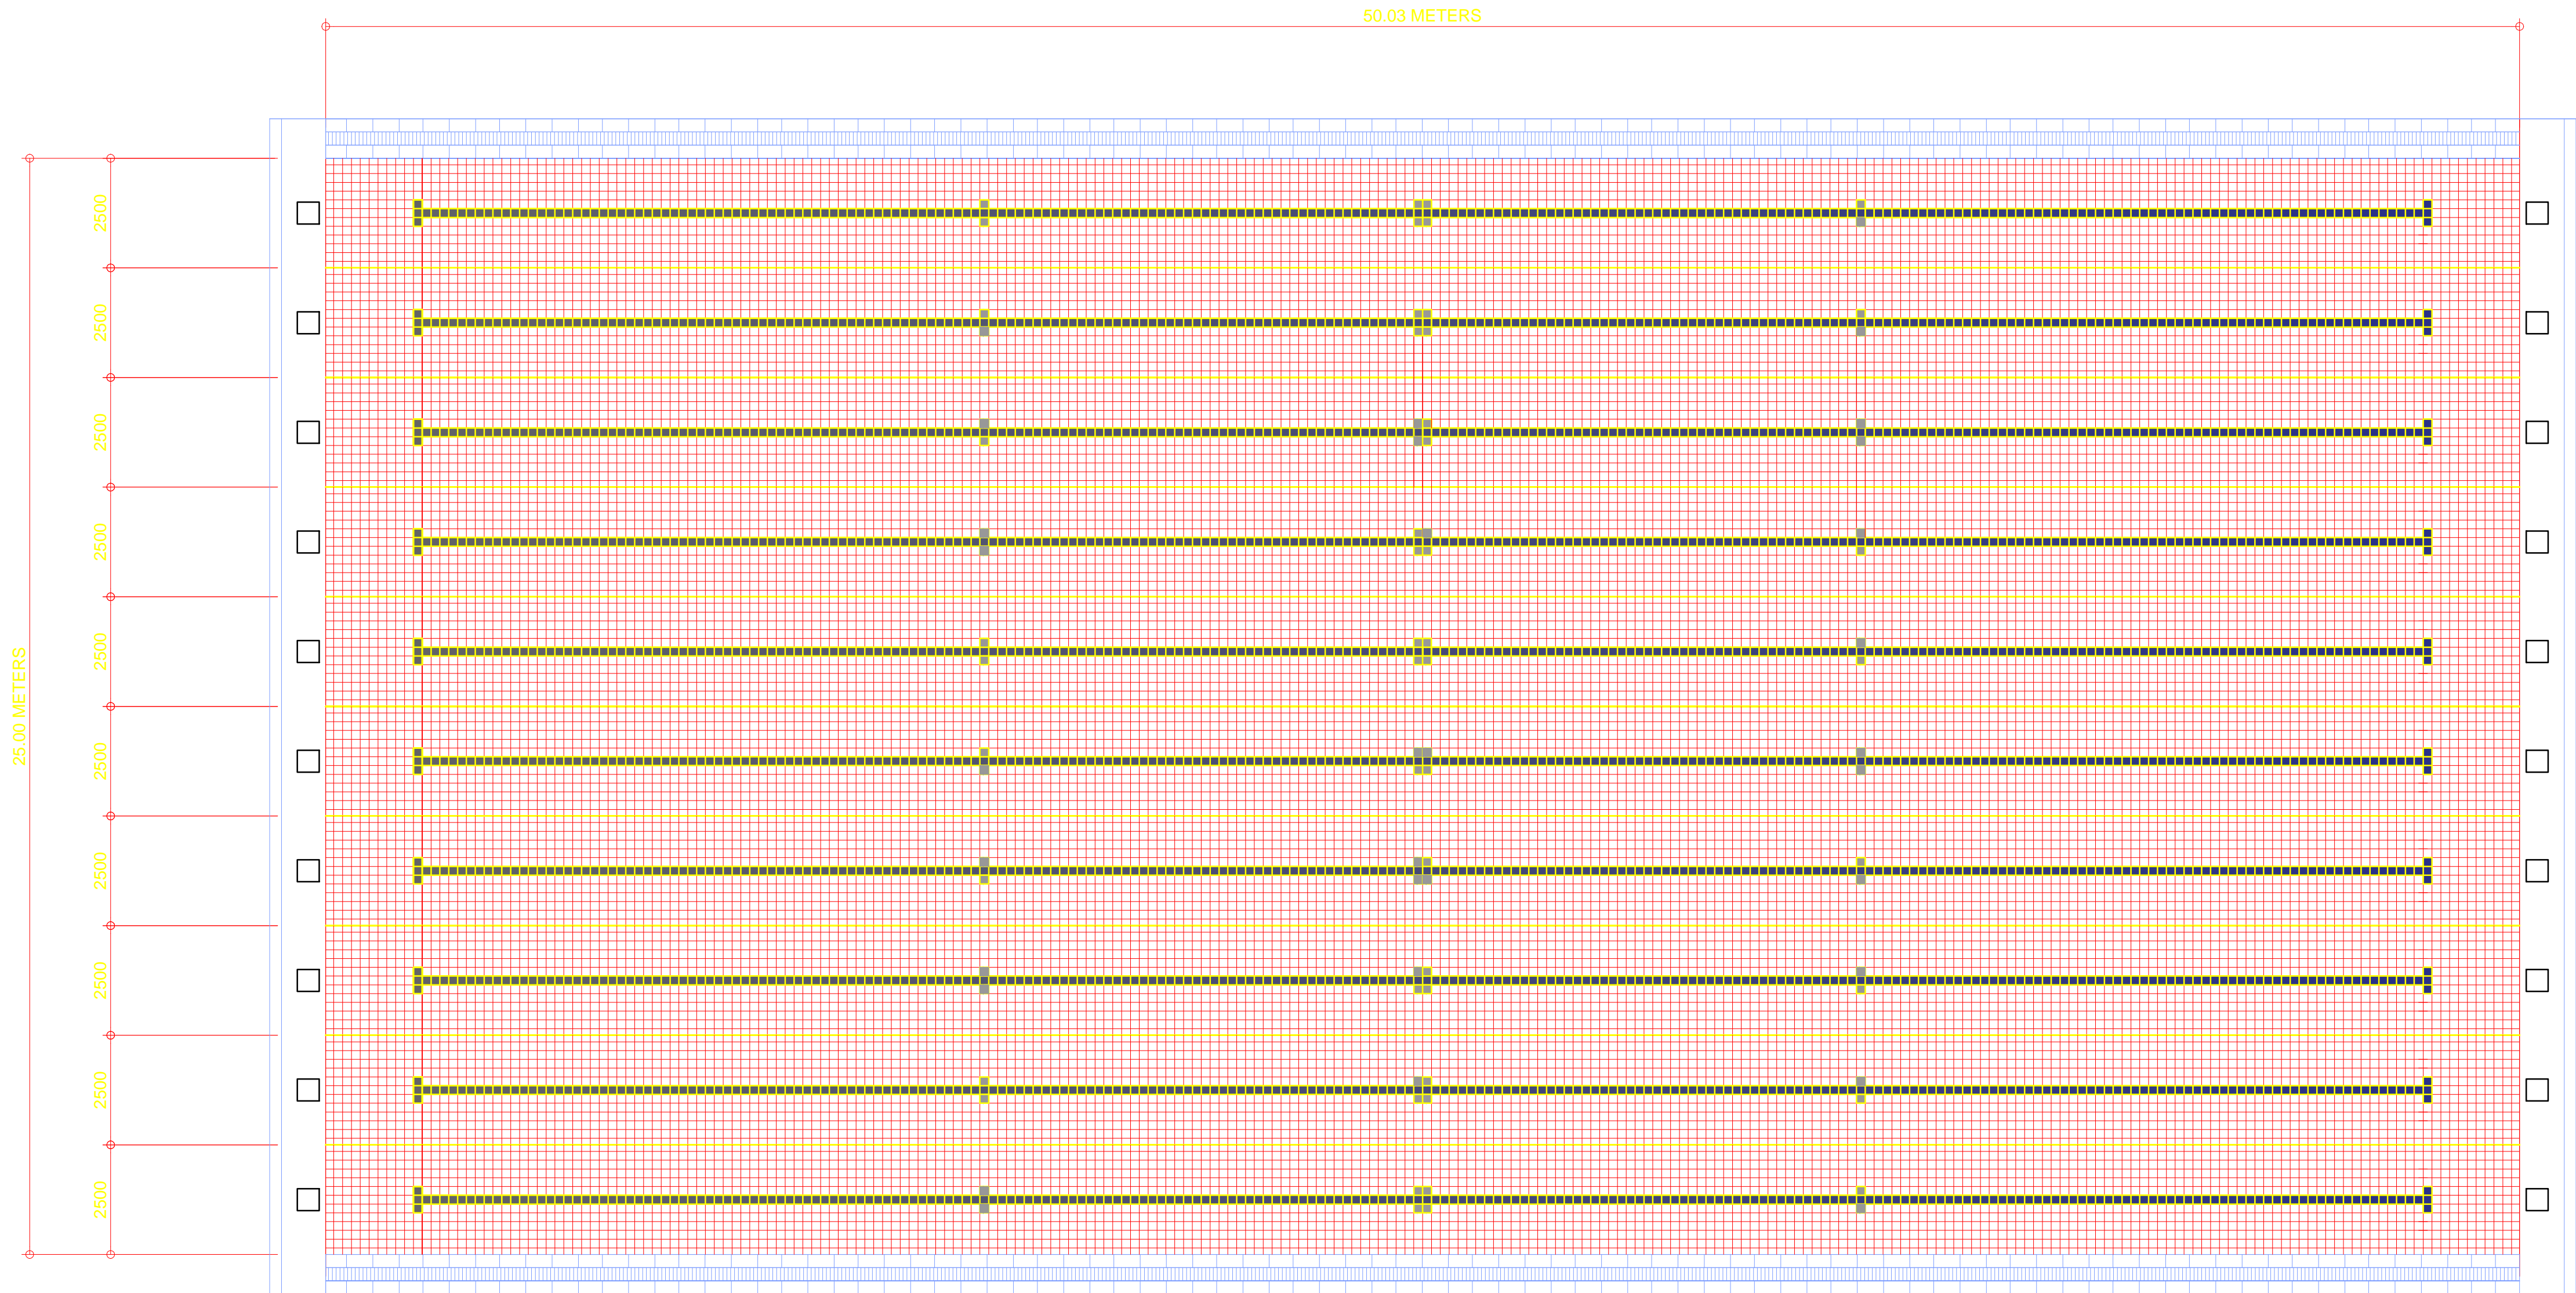


EXISTING LONGITUDINAL SECTION

 
SCALE 1:100 MTS.



OWNER	PROJECT TITLE :	SUBMITTED BY :	RECOMMENDING APPROVAL :	APPROVED BY :	SHEET CONTENTS :	DESIGN BY :		SHEET NO :
<div><div>PHILIPPINE SPORTS COMMISSION RMSG, PABLO OCAMPO SR. ST., MALATE, MANILA</div></div>	<div>UPGRADING OF SWIMMING POOL, DIVING POOL, WARM UP POOL AND CONSTRUCTION OF NEW BLEACHERS,AND JACUZZI</div> <div>LOCATION: RMSG, PABLO OCAMPO SR. ST., MALATE, MANILA</div>	<div>ENGR. PEDRO I. PINEDA JR.</div> <div>HEAD - ENGINEERING UNIT</div>	<div>DIR. MERLITA R. IBAY</div> <div>DEPUTY EXECUTIVE DIRECTOR</div>	<div>HON. WILLIAM I. RAMIREZ</div> <div>CHAIRMAN</div>	AS SHOWN	DESIGN BY :		<div>A</div> <div>19</div>
						DRAWN BY :		
						CHECKED BY :		
						DATE :		
						APPROVED BY :		

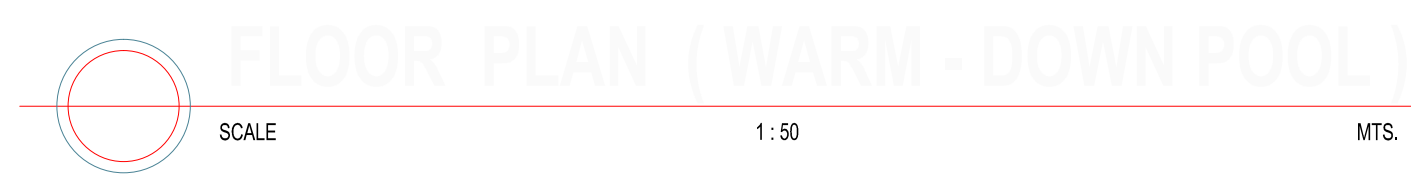


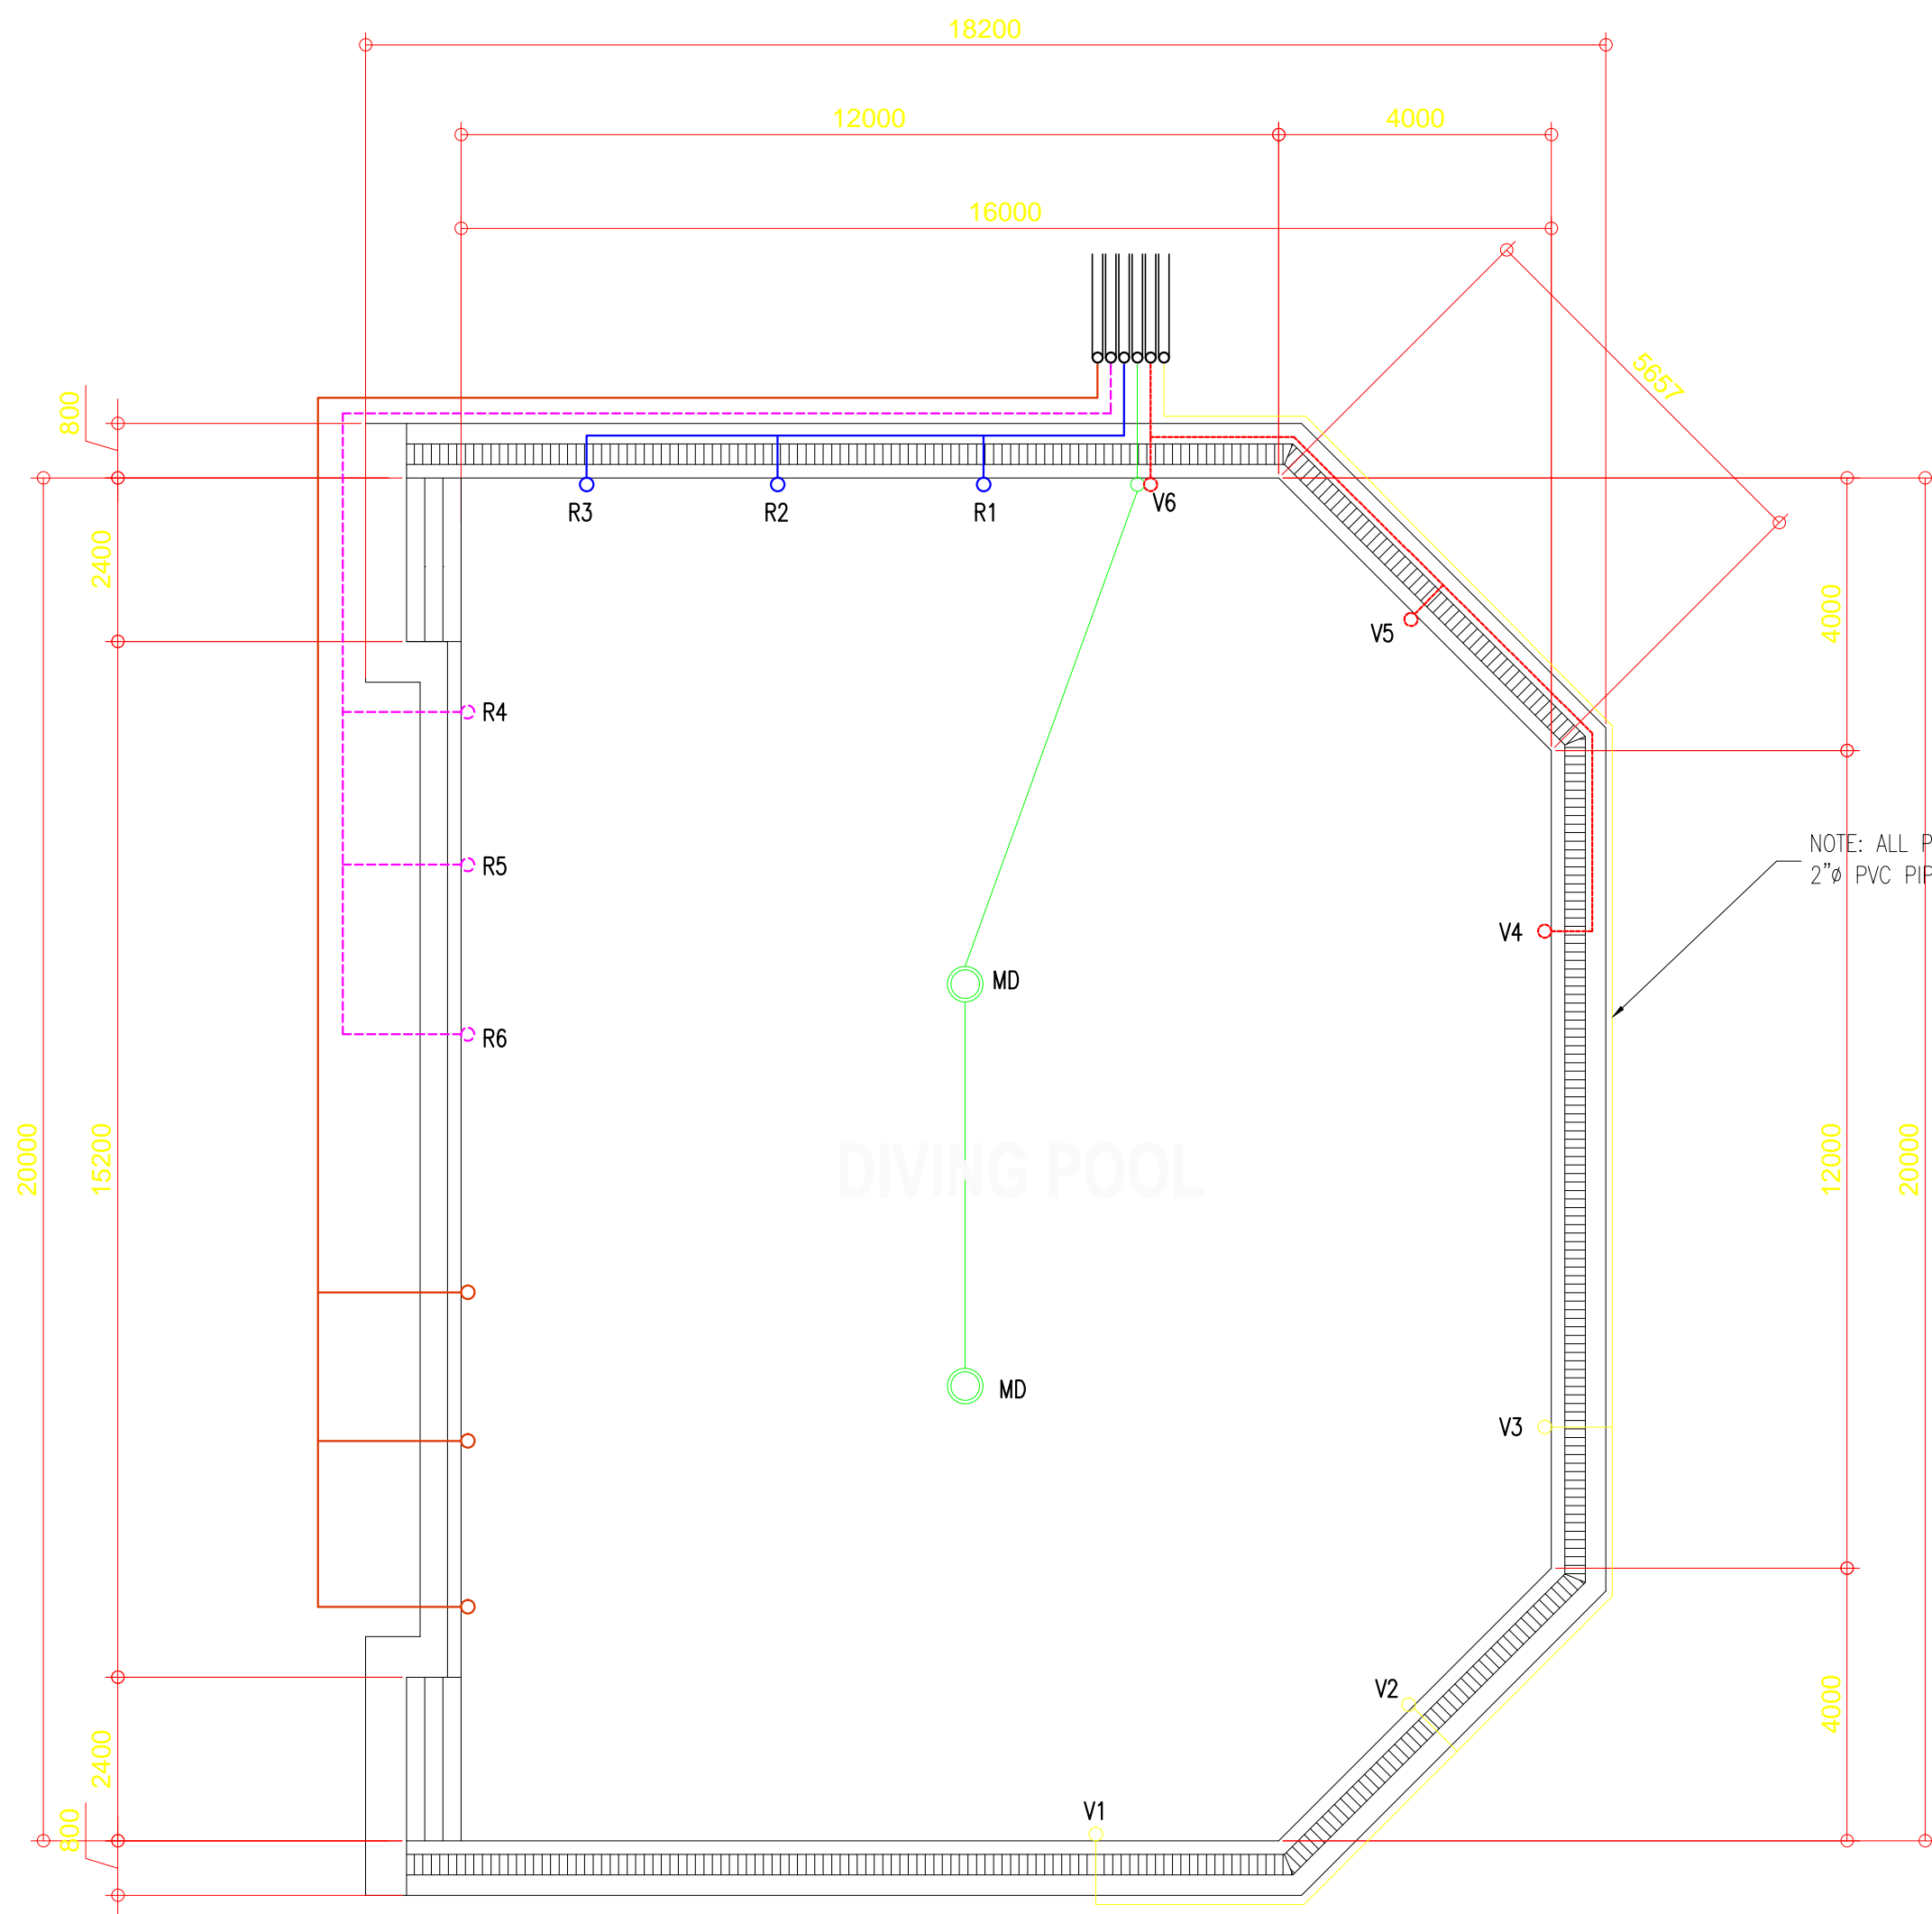
21




OWNER	PROJECT TITLE :	SUBMITTED BY :	RECOMMENDING APPROVAL :	APPROVED BY :	SHEET CONTENTS :	DESIGN BY :	SHEET NO :
 PHILIPPINE SPORTS COMMISSION RMSC, PABLO OCAMPO SR. ST., MALATE, MANILA	UPGRADING OF SWIMMING POOL, DIVING POOL, WARM UP POOL AND CONSTRUCTION OF NEW BLEACHERS, AND JACUZZI LOCATION: RMSC, PABLO OCAMPO SR. ST., MALATE, MANILA	ENGR. PEDRO I. PINEDA JR. HEAD - ENGINEERING UNIT	DIR. MERLITA R. IBAY DEPUTY EXECUTIVE DIRECTOR	HON. WILLIAM I. RAMIREZ CHAIRMAN	AS SHOWN	DRAWN BY :	<div> <div>A</div> <div>22</div> </div>
						CHECKED BY :	
						DATE :	
						APPROVED BY :	

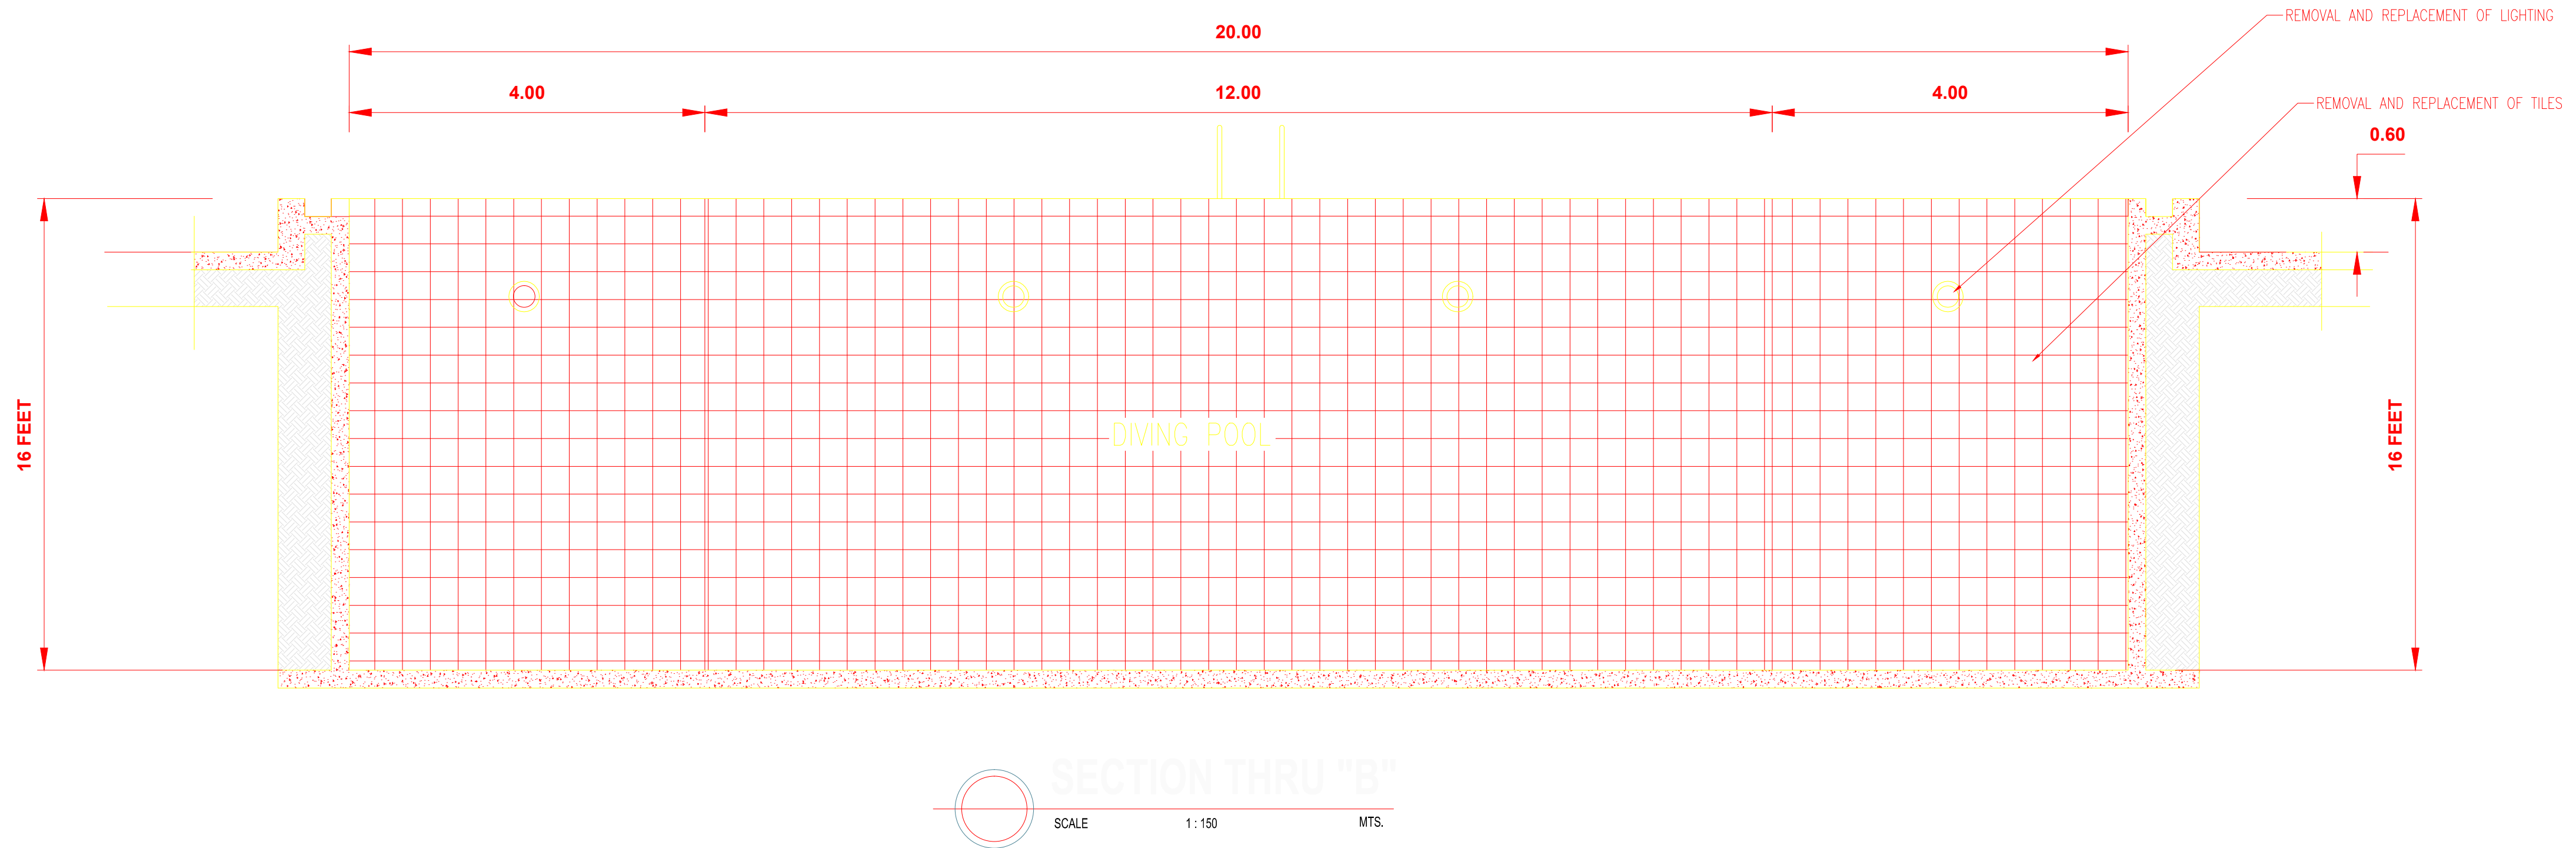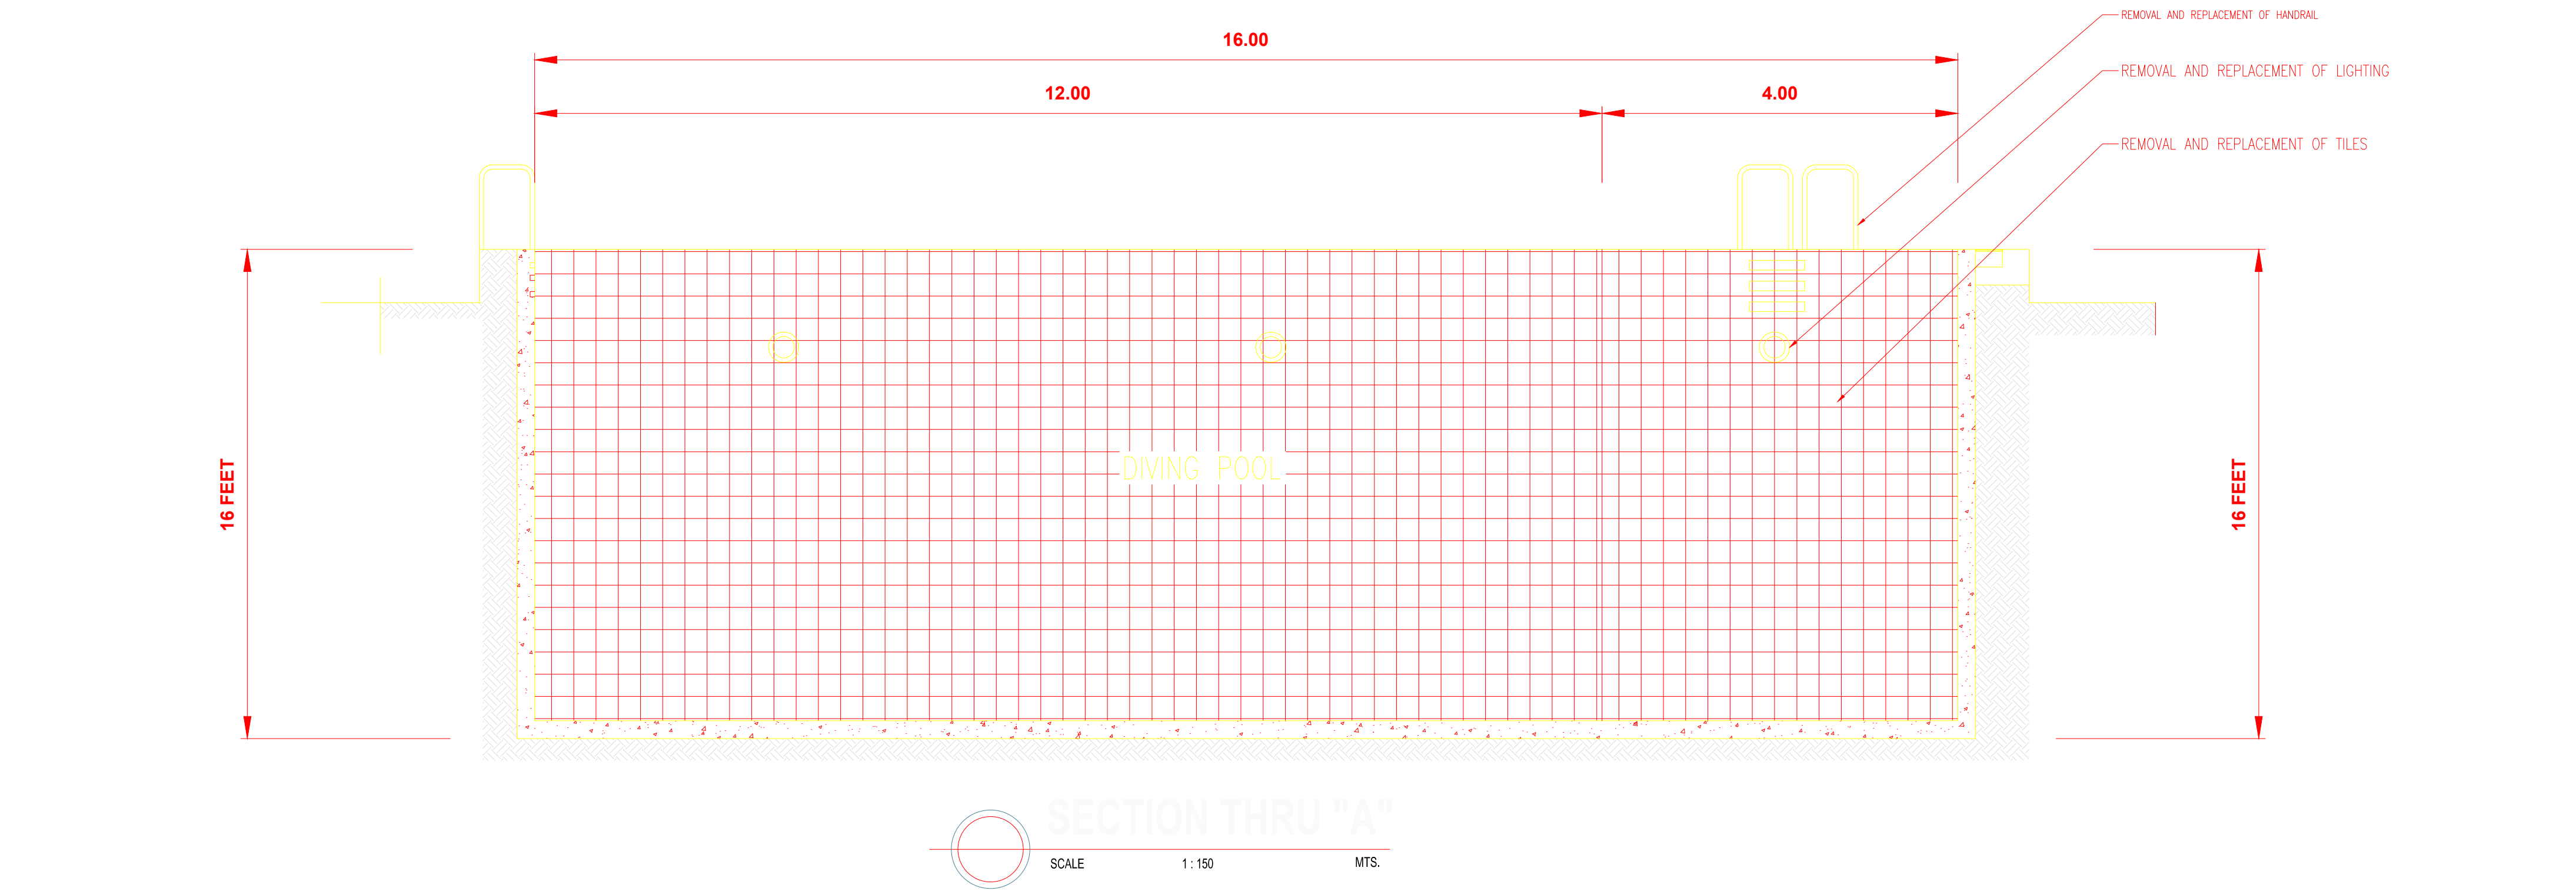


OWNER	PROJECT TITLE :	SUBMITTED BY :	RECOMMENDING APPROVAL :	APPROVED BY :	SHEET CONTENTS :	DESIGN BY :		SHEET NO :
<div><div>PHILIPPINE SPORTS COMMISSION RMSG, PABLO OCAMPO SR. ST., MALATE, MANILA</div></div>	<div>UPGRADING OF SWIMMING POOL, DIVING POOL, WARM UP POOL AND CONSTRUCTION OF NEW BLEACHERS,AND JACUZZI</div> <div>LOCATION: RMSG, PABLO OCAMPO SR. ST., MALATE, MANILA</div>	<div>ENGR. PEDRO I. PINEDA JR.</div> <div>HEAD - ENGINEERING UNIT</div>	<div>DIR. MERLITA R. IBAY</div> <div>DEPUTY EXECUTIVE DIRECTOR</div>	<div>HON. WILLIAM I. RAMIREZ</div> <div>CHAIRMAN</div>	AS SHOWN	DESIGN BY :		<div>A</div> <div>23</div>
						DRAWN BY :		
						CHECKED BY :		
						DATE :		
						APPROVED BY :		



PIPING LAY-OUT
SCALE 1:100 MTS.

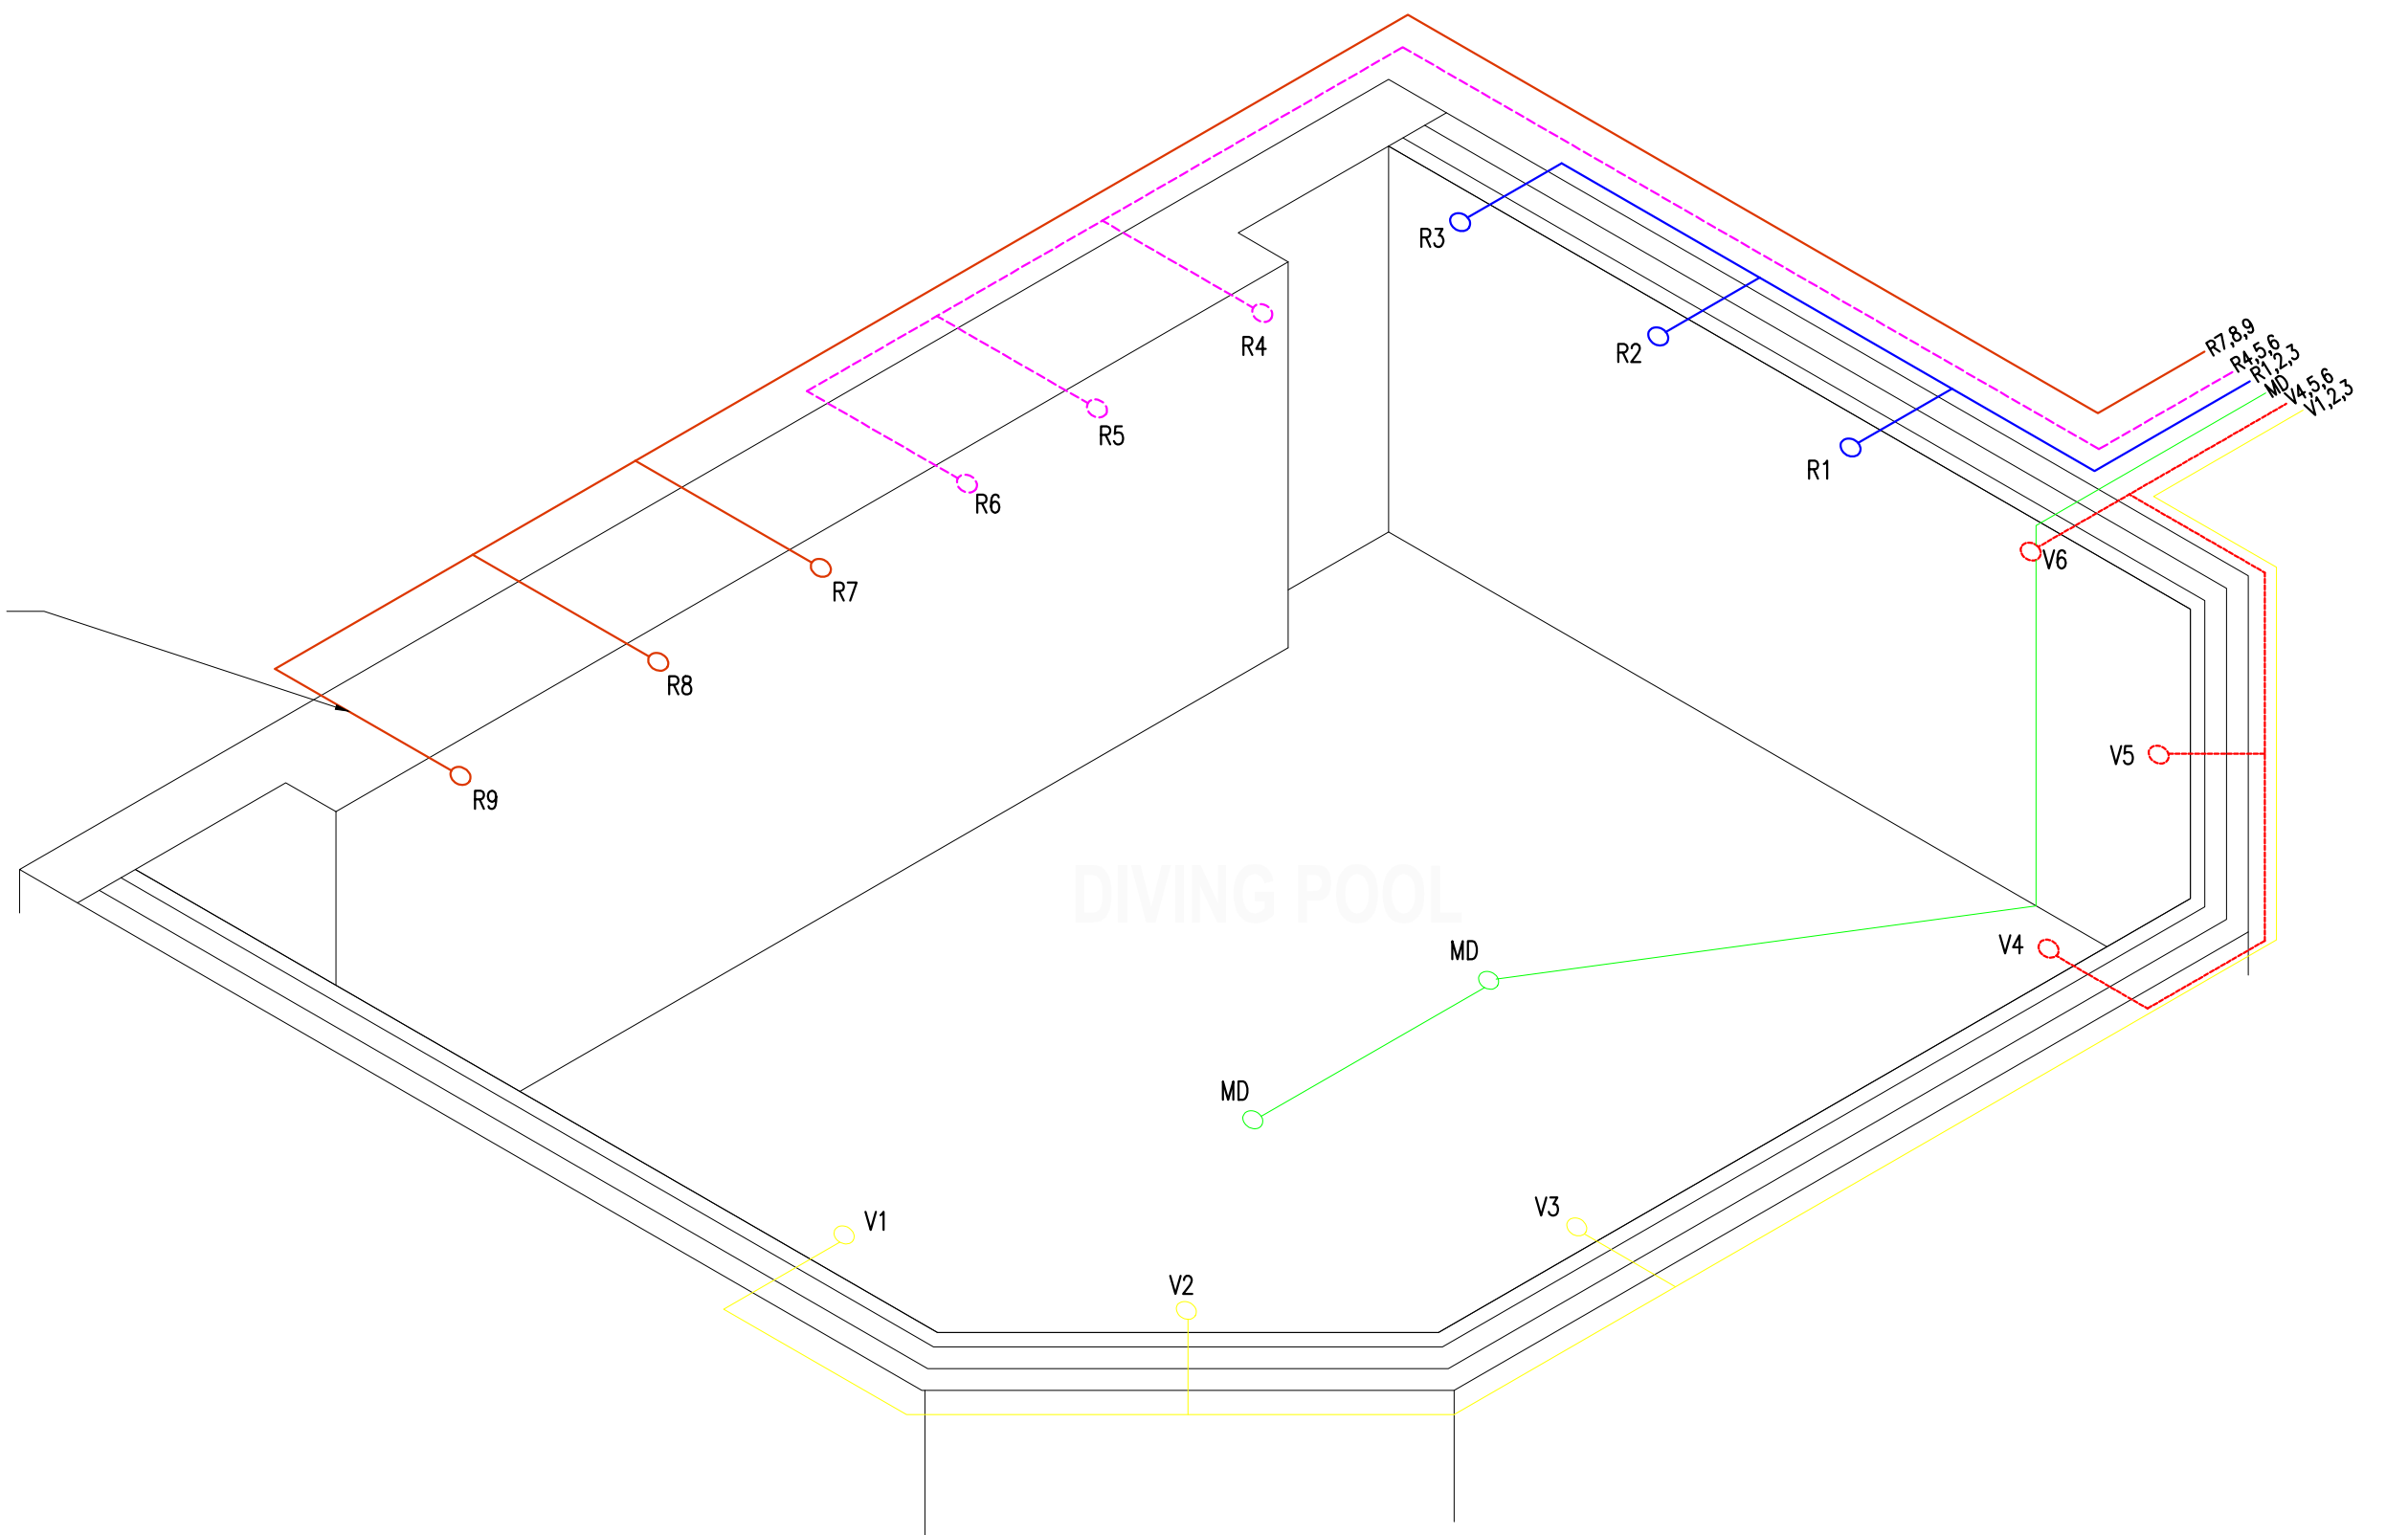

ISOMETRIC PIPING LAY-OUT
SCALE 1:100 MTS.

OWNER	PROJECT TITLE :	SUBMITTED BY :	RECOMMENDING APPROVAL :	APPROVED BY :	SHEET CONTENTS :	DESIGN BY :		SHEET NO :
<div><div></div><div>PHILIPPINE SPORTS COMMISSION RMSG, PABLO OCAMPO SR. ST., MALATE, MANILA</div></div>	<div>UPGRADING OF SWIMMING POOL, DIVING POOL, WARM UP POOL AND CONSTRUCTION OF NEW BLEACHERS,AND JACUZZI</div> <div>LOCATION: RMSG, PABLO OCAMPO SR. ST., MALATE, MANILA</div>	<div>ENGR. PEDRO I. PINEDA JR.</div> <div>HEAD - ENGINEERING UNIT</div>	<div>DIR. MERLITA R. IBAY</div> <div>DEPUTY EXECUTIVE DIRECTOR</div>	<div>HON. WILLIAM I. RAMIREZ</div> <div>CHAIRMAN</div>	AS SHOWN	DRAWN BY : CHECKED BY : DATE : APPROVED BY :		<div>P 1</div>