


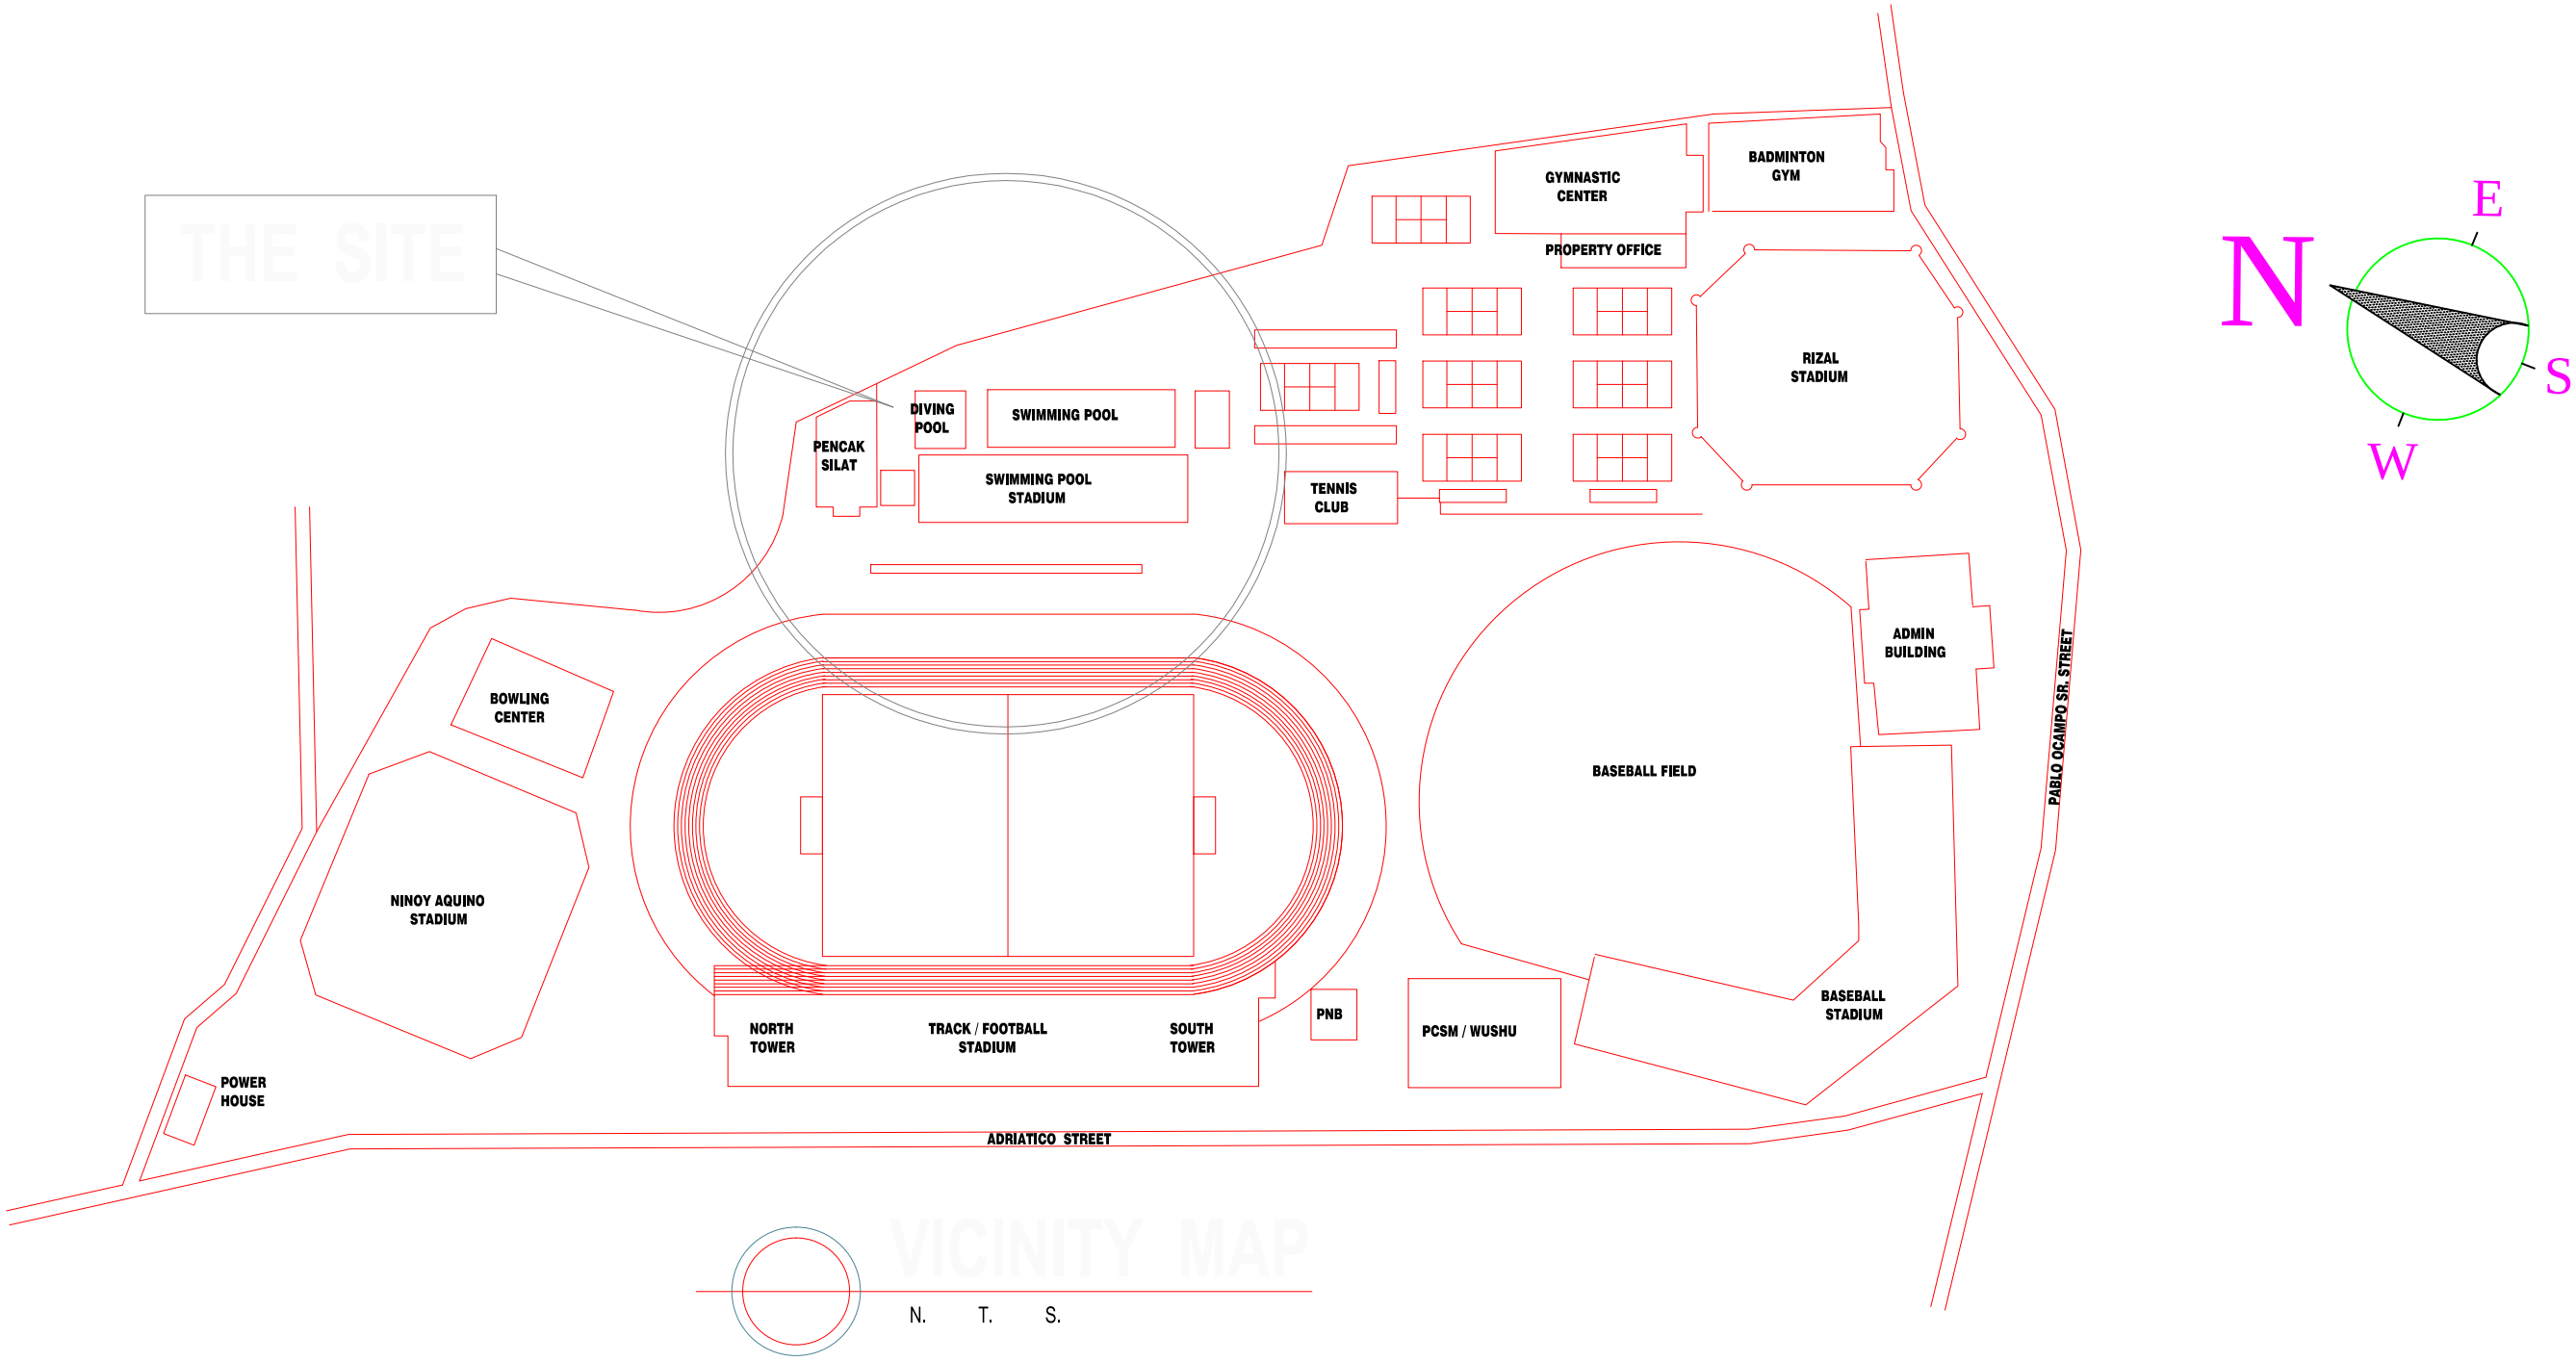


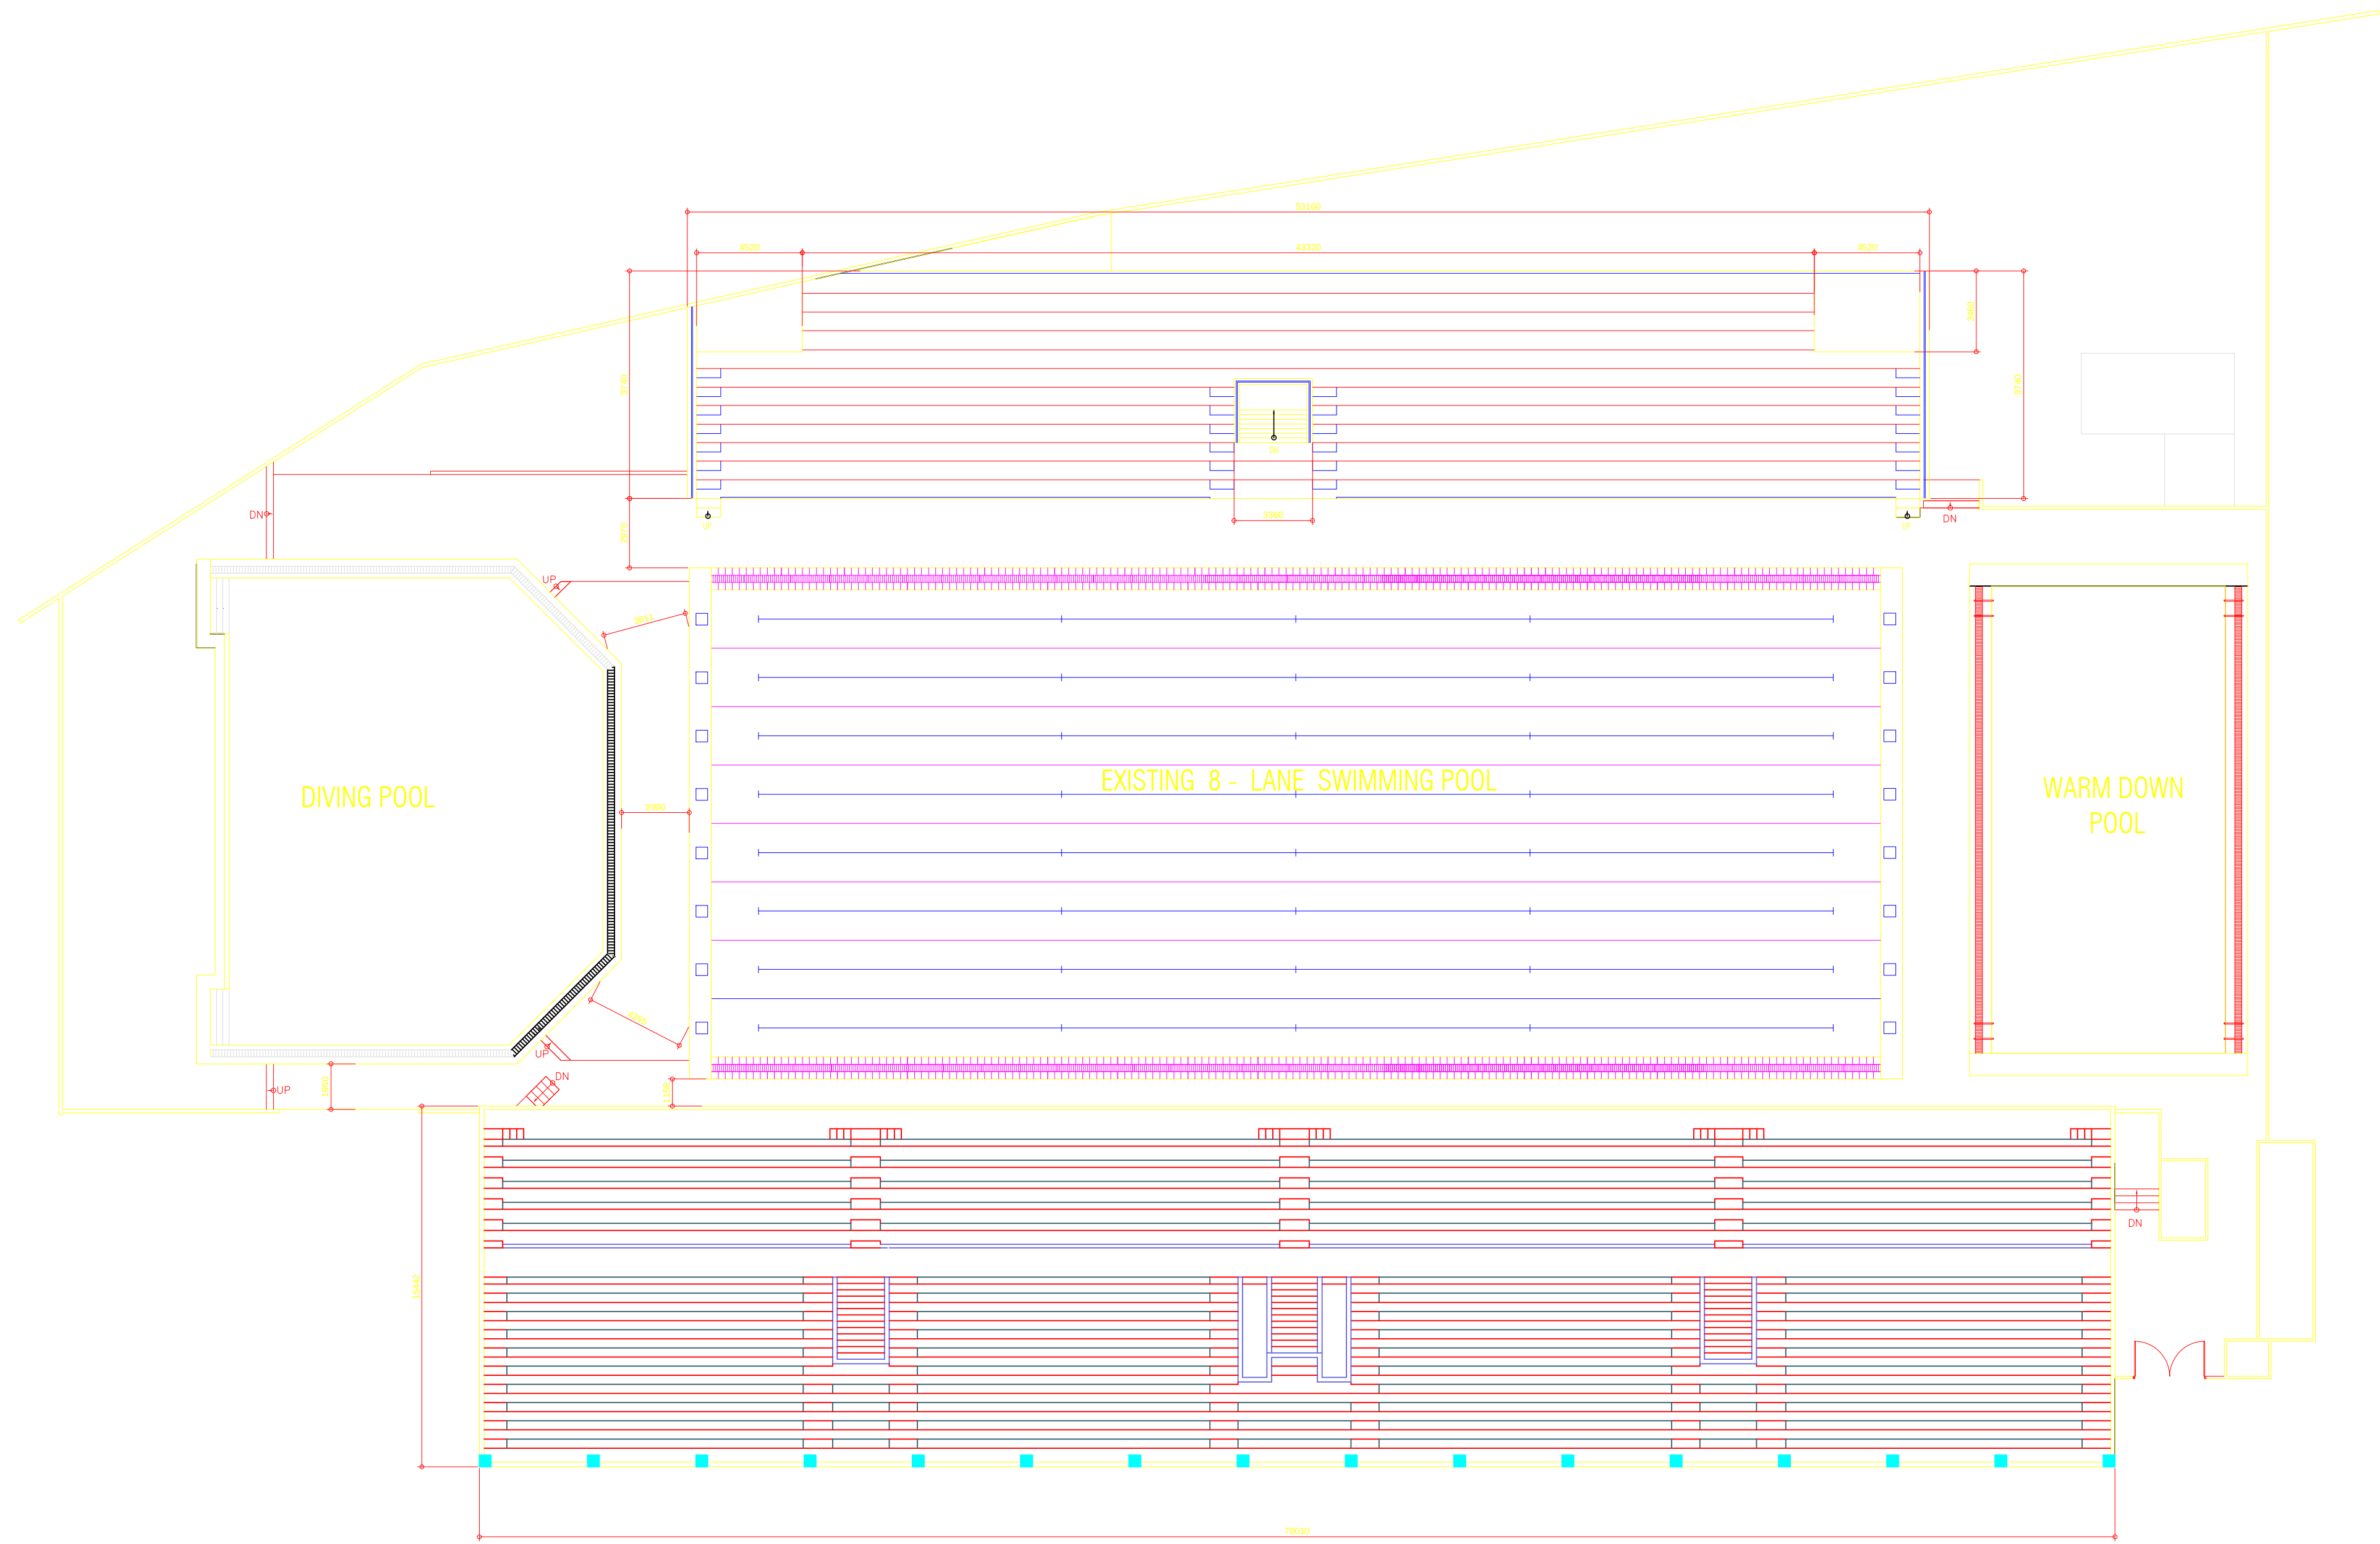

OWNER	PROJECT TITLE :	SUBMITTED BY :	RECOMMENDING APPROVAL :	APPROVED BY :	SHEET CONTENTS :	DESIGN BY :	CHECKED BY :	DATE :	APPROVED BY :	SHEET NO :
 PHILIPPINE SPORTS COMMISSION RMSG, PABLO OCAMPO SR. ST., MALATE, MANILA	UPGRADING OF SWIMMING POOL, DIVING POOL, WARM UP POOL AND CONSTRUCTION OF NEW BLEACHERS,AND JACUZZI LOCATION: RMSG, PABLO OCAMPO SR. ST., MALATE, MANILA	ENGR. PEDRO I. PINEDA JR. HEAD - ENGINEERING UNIT	DIR. MERLITA R. IBAY DEPUTY EXECUTIVE DIRECTOR	HON. WILLIAM I. RAMIREZ CHAIRMAN	AS SHOWN					A 1

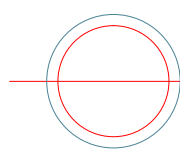


OWNER	PROJECT TITLE :	SUBMITTED BY :	RECOMMENDING APPROVAL :	APPROVED BY :	SHEET CONTENTS :	DESIGN BY :		SHEET NO :
 PHILIPPINE SPORTS COMMISSION RMSG, PABLO OCAMPO SR. ST., MALATE, MANILA	UPGRADING OF SWIMMING POOL, DIVING POOL, WARM UP POOL AND CONSTRUCTION OF NEW BLEACHERS,AND JACUZZI LOCATION: RMSG, PABLO OCAMPO SR. ST., MALATE, MANILA	ENGR. PEDRO I. PINEDA JR. HEAD - ENGINEERING UNIT	DIR. MERLITA R. IBAY DEPUTY EXECUTIVE DIRECTOR	HON. WILLIAM I. RAMIREZ CHAIRMAN	AS SHOWN	DRAWN BY :		A 2
						CHECKED BY :		
						DATE :		
						APPROVED BY :		

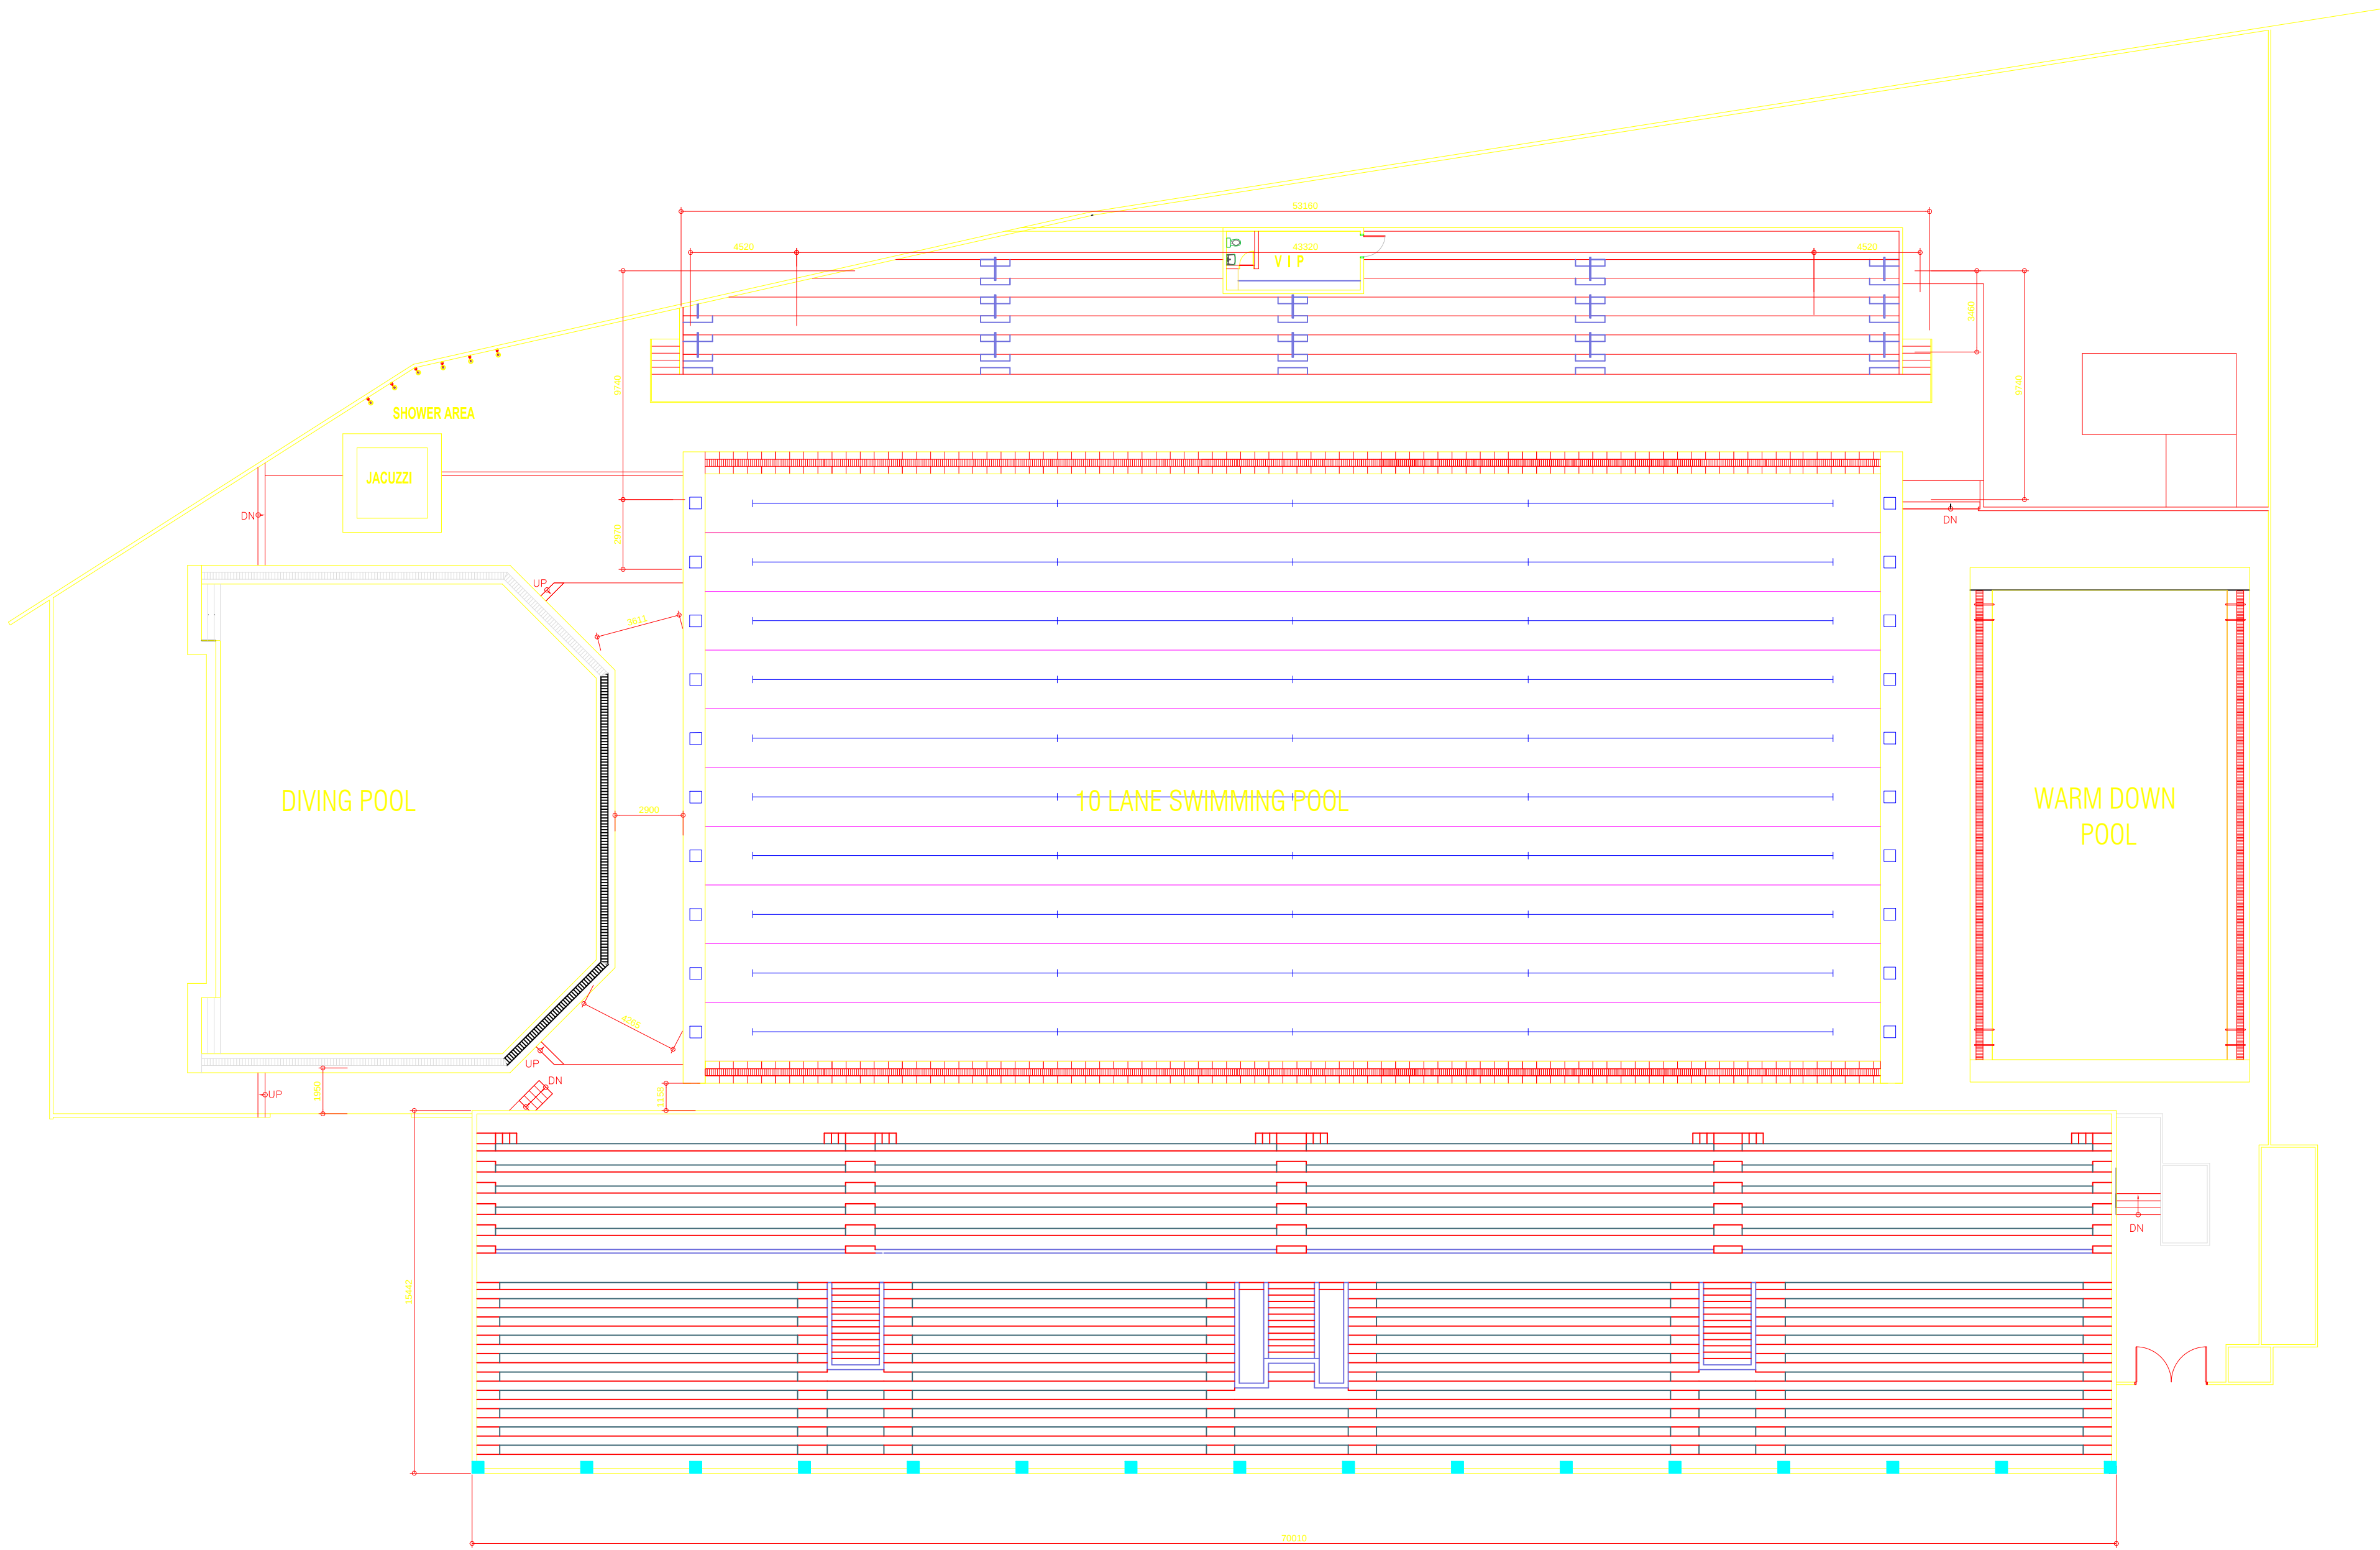

PROPOSED BLEACHERS GROUND FLOOR PLAN



SCALE 1 : 100 MTS.

OWNER	PROJECT TITLE :	SUBMITTED BY :	RECOMMENDING APPROVAL :	APPROVED BY :	SHEET CONTENTS :	DESIGN BY :	SHEET NO :
PHILIPPINE SPORTS COMMISSION RMSC, PABLO OCAMPO SR. ST., MALATE, MANILA	UPGRADING OF SWIMMING POOL, DIVING POOL, WARM UP POOL AND CONSTRUCTION OF NEW BLEACHERS,AND JACUZZI LOCATION: RMSC, PABLO OCAMPO SR. ST., MALATE, MANILA	ENGR. PEDRO I. PINEDA JR. HEAD - ENGINEERING UNIT	DIR. MERLITA R. IBAY DEPUTY EXECUTIVE DIRECTOR	HON. WILLIAM I. RAMIREZ CHAIRMAN	AS SHOWN	DRAWN BY :	A 3
						CHECKED BY :	
						DATE :	
						APPROVED BY :	

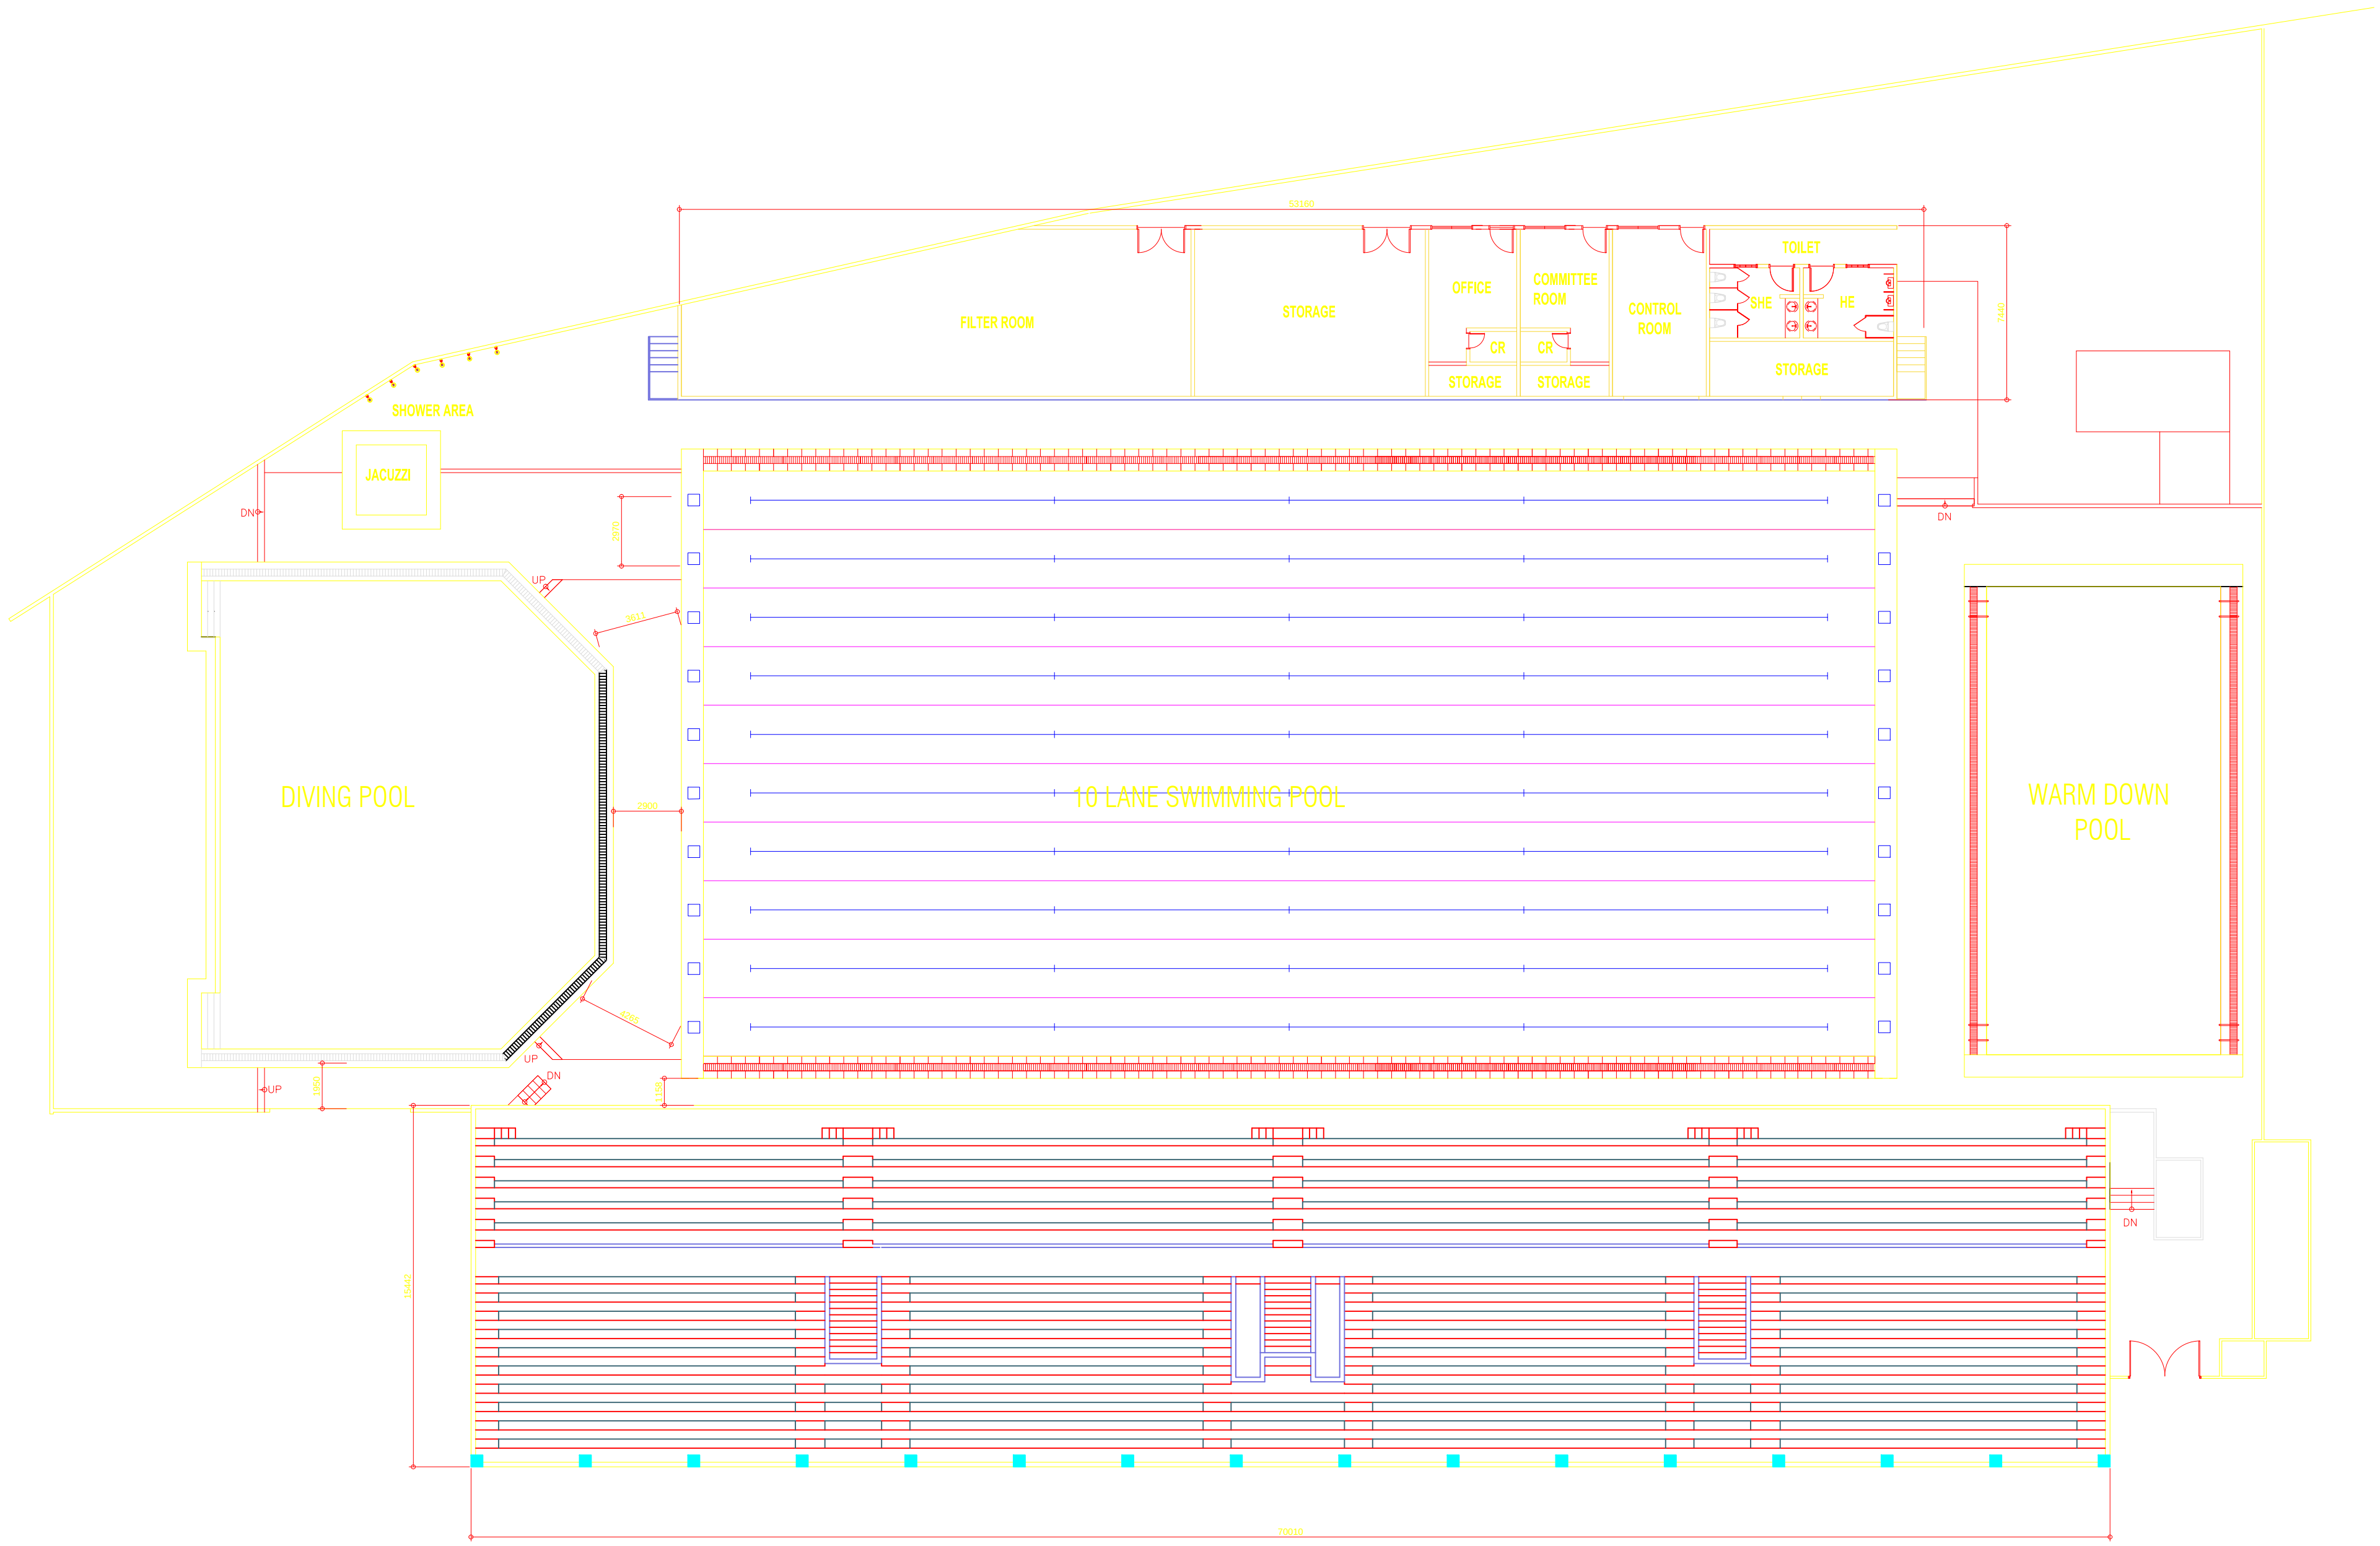


PROPOSED BLEACHERS GROUND FLOOR PLAN
SCALE 1 : 100 MTS.

OWNER	PROJECT TITLE :	SUBMITTED BY :	RECOMMENDING APPROVAL :	APPROVED BY :	SHEET CONTENTS :	DESIGN BY :		SHEET NO :
 PHILIPPINE SPORTS COMMISSION RMSG, PABLO OCAMPO SR. ST., MALATE, MANILA	UPGRADING OF SWIMMING POOL, DIVING POOL, WARM UP POOL AND CONSTRUCTION OF NEW BLEACHERS, AND JACUZZI LOCATION: RMSG, PABLO OCAMPO SR. ST., MALATE, MANILA	ENGR. PEDRO I. PINEDA JR. HEAD - ENGINEERING UNIT	DIR. MERLITA R. IBAY DEPUTY EXECUTIVE DIRECTOR	HON. WILLIAM I. RAMIREZ CHAIRMAN	AS SHOWN	DRAWN BY :		A 4
						CHECKED BY :		
						DATE :		
						APPROVED BY :		

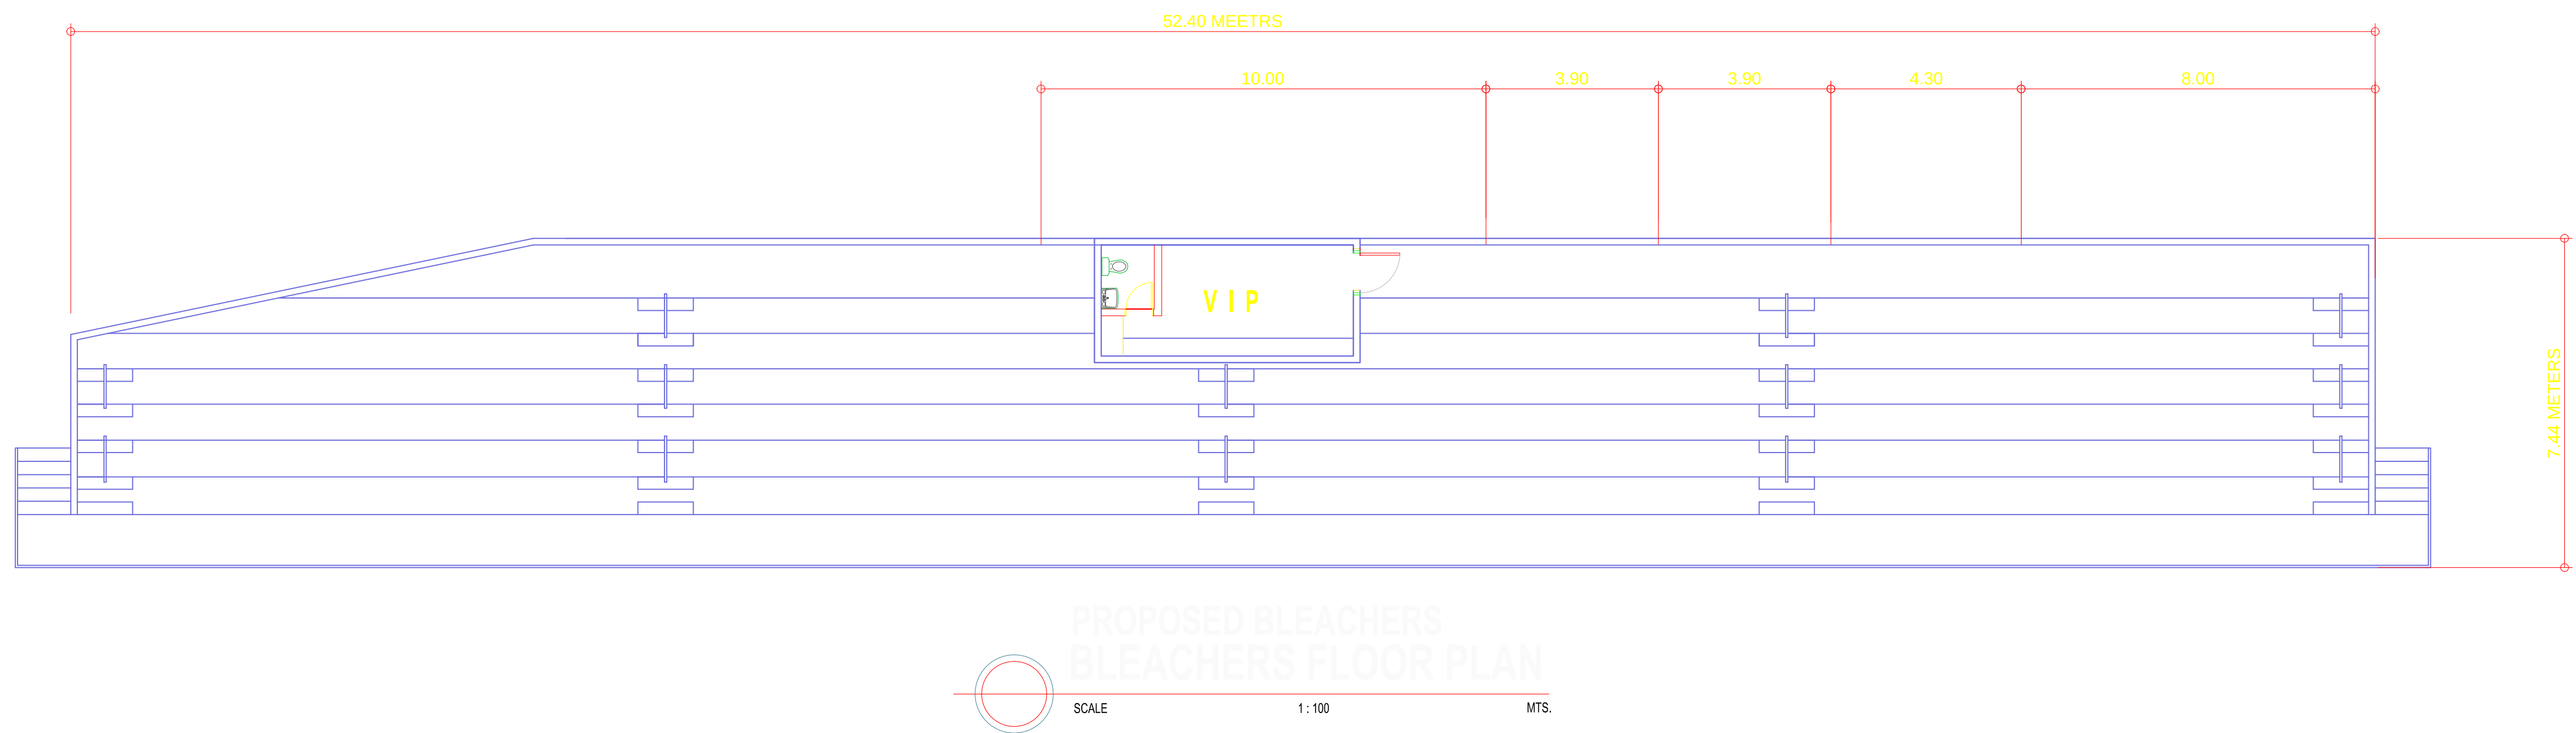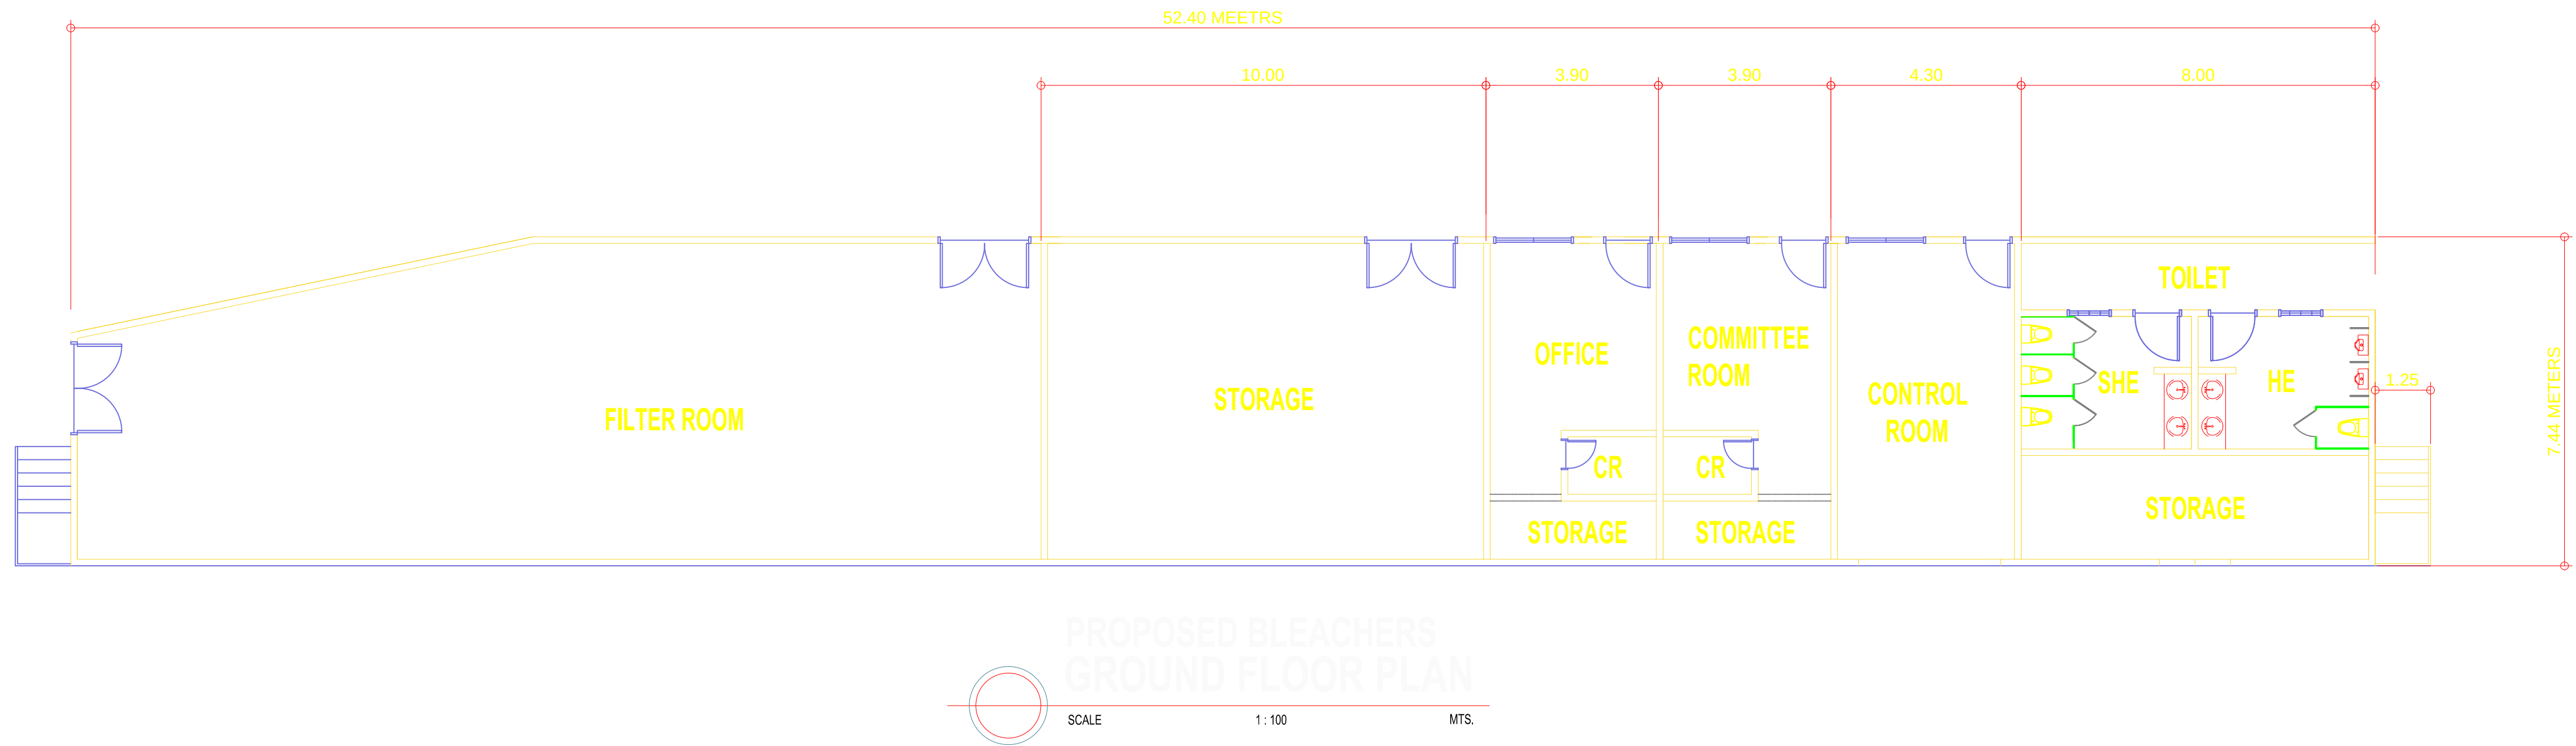


OWNER	PROJECT TITLE :	SUBMITTED BY :	RECOMMENDING APPROVAL :	APPROVED BY :	SHEET CONTENTS :	DESIGN BY :		SHEET NO :
 PHILIPPINE SPORTS COMMISSION RMSG, PABLO OCAMPO SR. ST., MALATE, MANILA	UPGRADING OF SWIMMING POOL, DIVING POOL, WARM UP POOL AND CONSTRUCTION OF NEW BLEACHERS,AND JACUZZI LOCATION: RMSG, PABLO OCAMPO SR. ST., MALATE, MANILA	ENGR. PEDRO I. PINEDA JR. HEAD - ENGINEERING UNIT	DIR. MERLITA R. IBAY DEPUTY EXECUTIVE DIRECTOR	HON. WILLIAM I. RAMIREZ CHAIRMAN	AS SHOWN	DRAWN BY :		A 6
						CHECKED BY :		
						DATE :		
						APPROVED BY :		

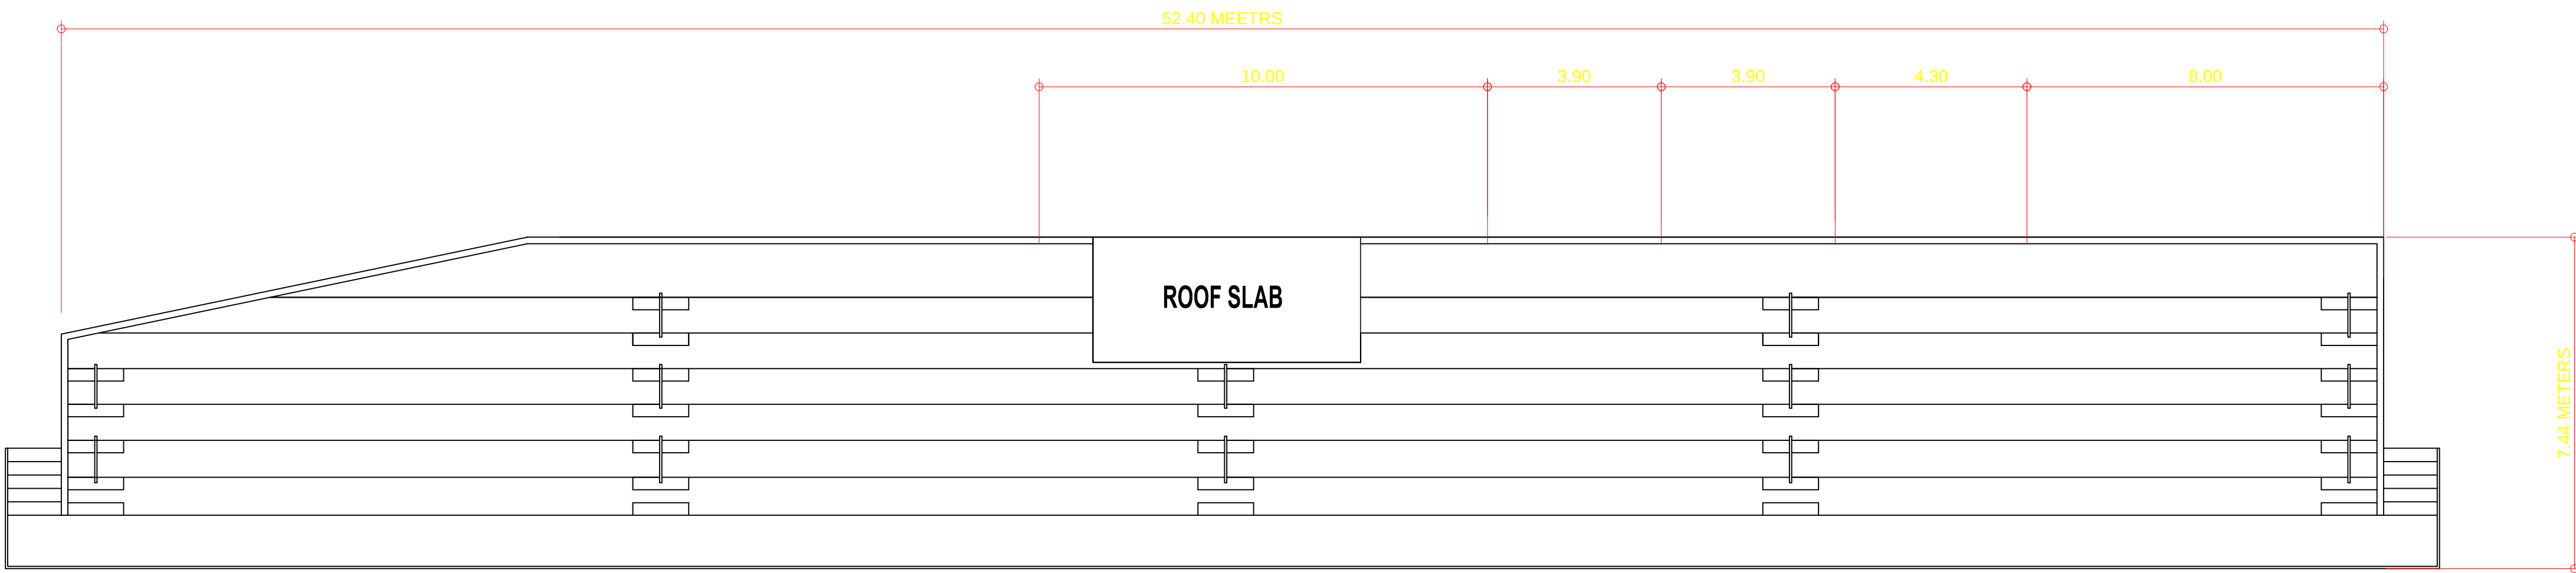

**PROPOSED BLEACHERS
VIP ROOF SLAB PLAN**



SCALE 1:100 MTS.

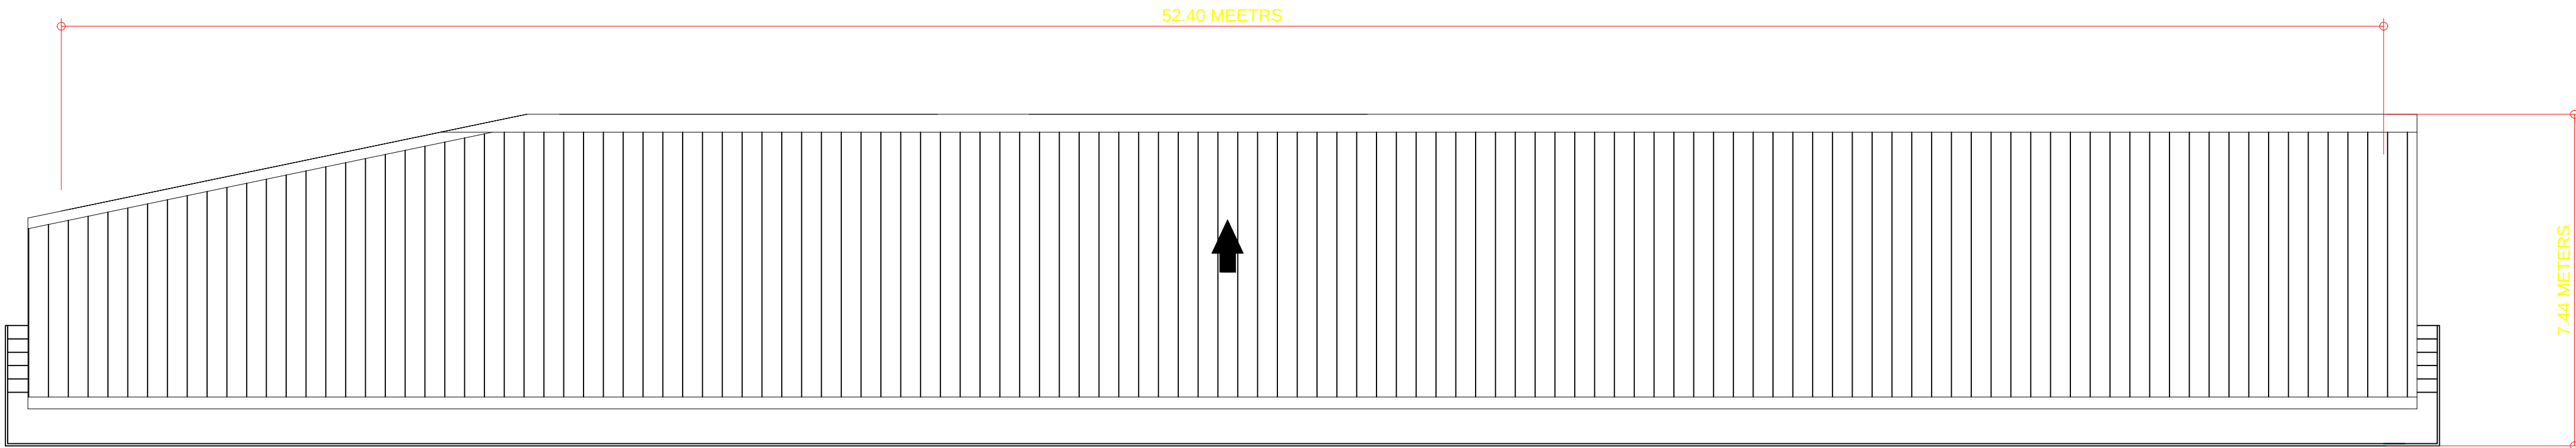



**PROPOSED BLEACHERS
ROOF PLAN**

SCALE 1:100 MTS.


OWNER	PROJECT TITLE :	SUBMITTED BY :	RECOMMENDING APPROVAL :	APPROVED BY :	SHEET CONTENTS :	DESIGN BY :		SHEET NO :
 PHILIPPINE SPORTS COMMISSION RMSG, PABLO OCAMPO SR. ST., MALATE, MANILA	UPGRADING OF SWIMMING POOL, DIVING POOL, WARM UP POOL AND CONSTRUCTION OF NEW BLEACHERS,AND JACUZZI LOCATION: RMSG, PABLO OCAMPO SR. ST., MALATE, MANILA	ENGR. PEDRO I. PINEDA JR. HEAD - ENGINEERING UNIT	DIR. MERLITA R. IBAY DEPUTY EXECUTIVE DIRECTOR	HON. WILLIAM I. RAMIREZ CHAIRMAN	AS SHOWN	DRAWN BY :		A 7
						CHECKED BY :		
						DATE :		
						APPROVED BY :		

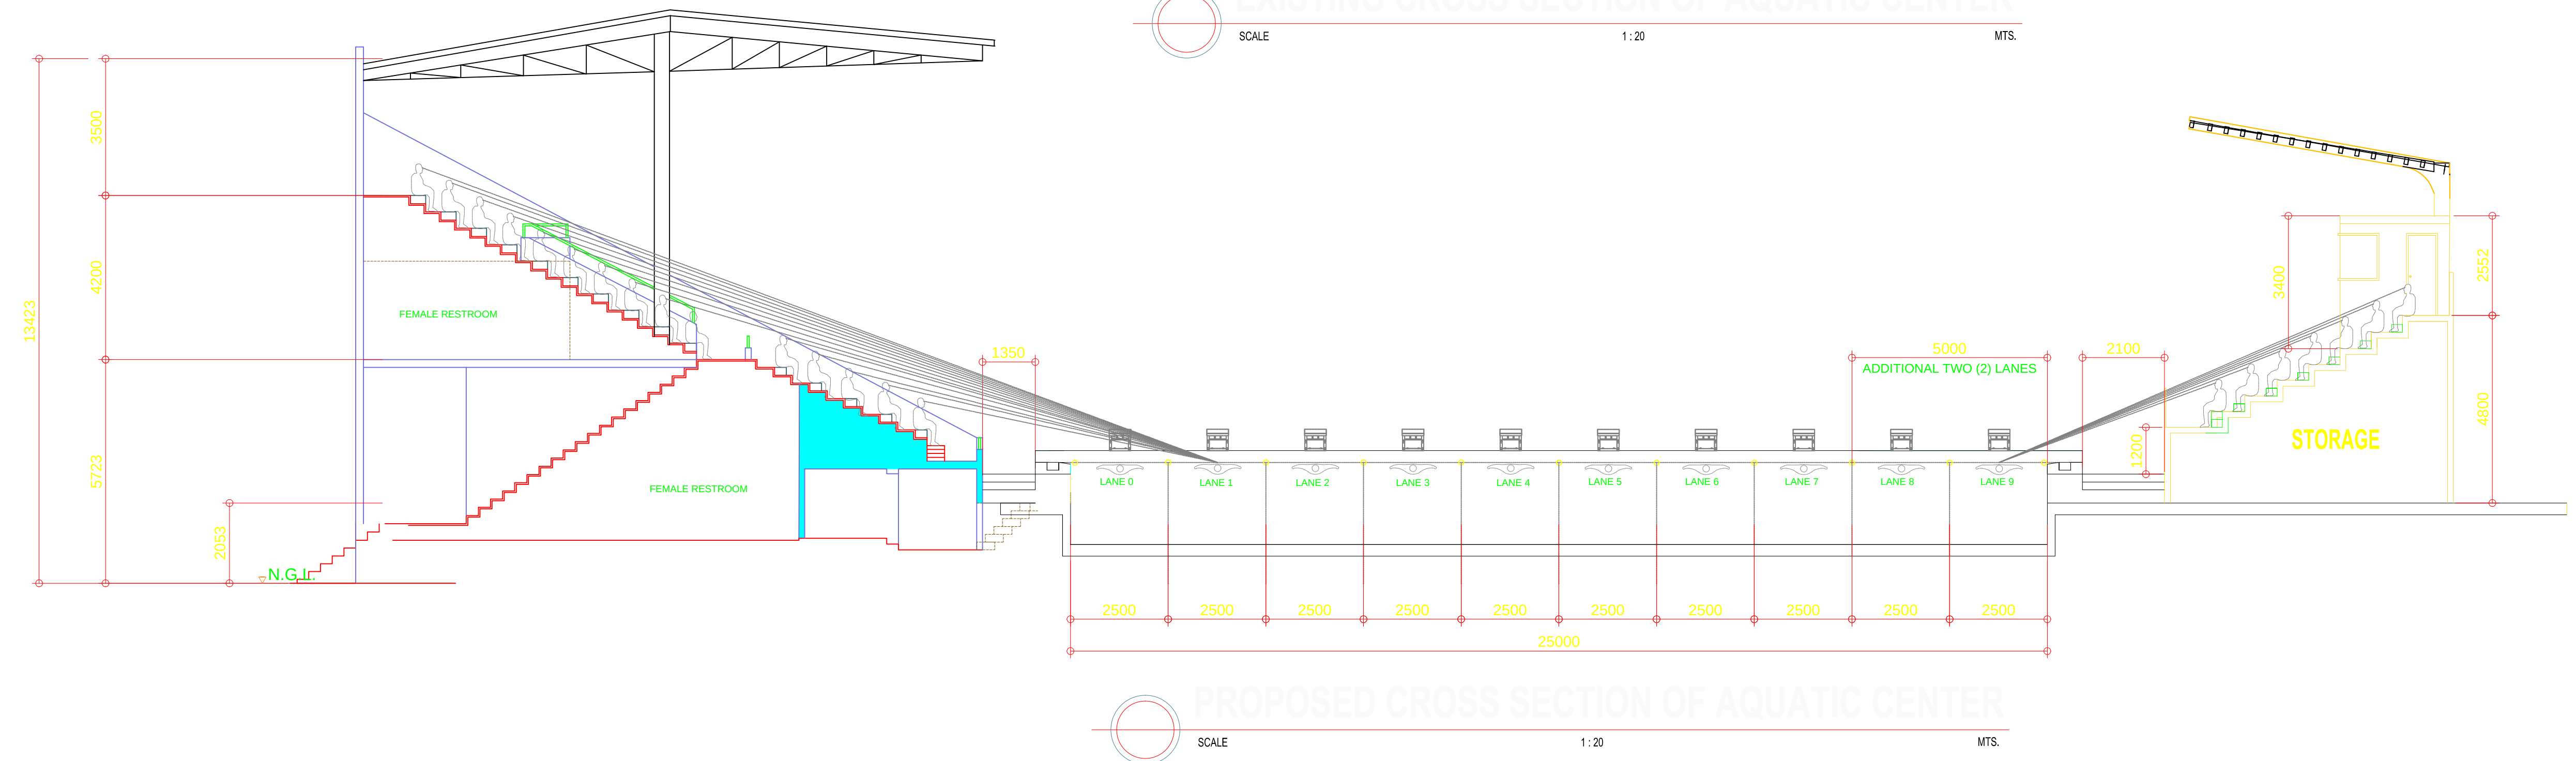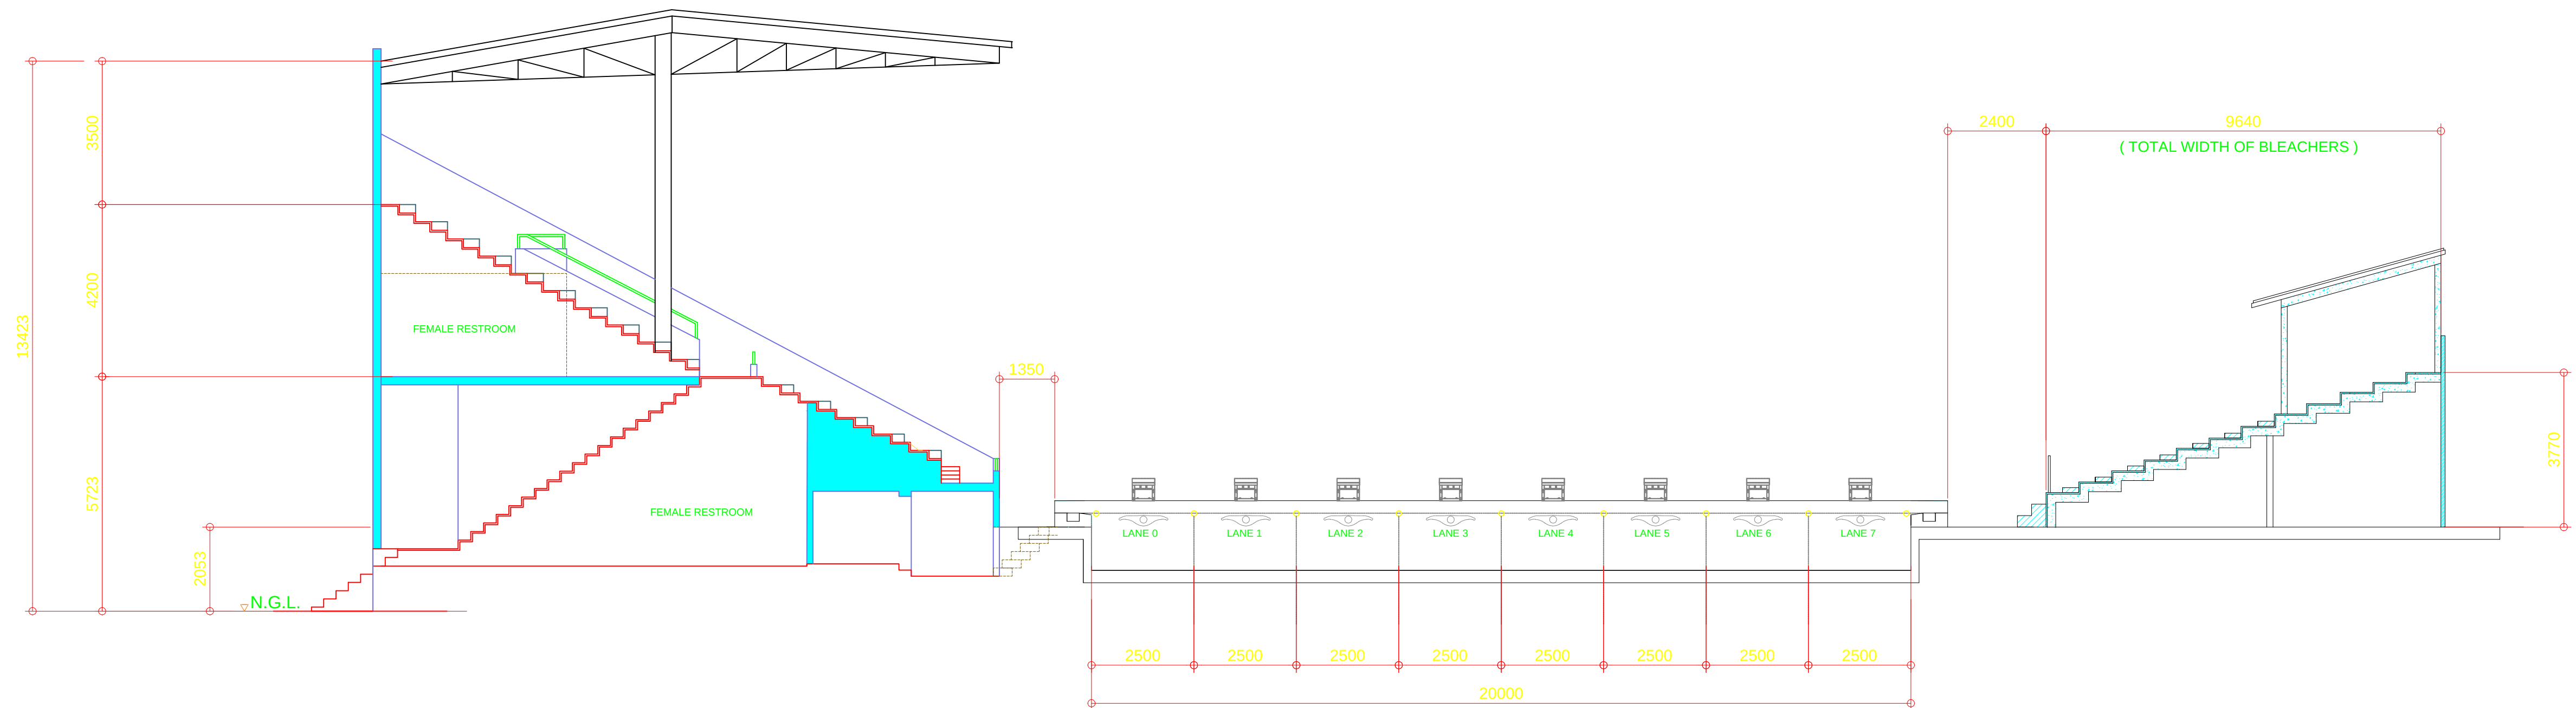

OWNER	PROJECT TITLE :	SUBMITTED BY :	RECOMMENDING APPROVAL :	APPROVED BY :	SHEET CONTENTS :	DESIGN BY :	SHEET NO :
PHILIPPINE SPORTS COMMISSION RMSC, PABLO OCAMPO SR. ST., MALATE, MANILA	UPGRADING OF SWIMMING POOL, DIVING POOL, WARM UP POOL AND CONSTRUCTION OF NEW BLEACHERS,AND JACUZZI LOCATION: RMSC, PABLO OCAMPO SR. ST., MALATE, MANILA	ENGR. PEDRO I. PINEDA JR. HEAD - ENGINEERING UNIT	DIR. MERLITA R. IBAY DEPUTY EXECUTIVE DIRECTOR	HON. WILLIAM I. RAMIREZ CHAIRMAN	AS SHOWN	DESIGN BY :	A 8
						DRAWN BY :	
						CHECKED BY :	
						DATE :	
						APPROVED BY :	

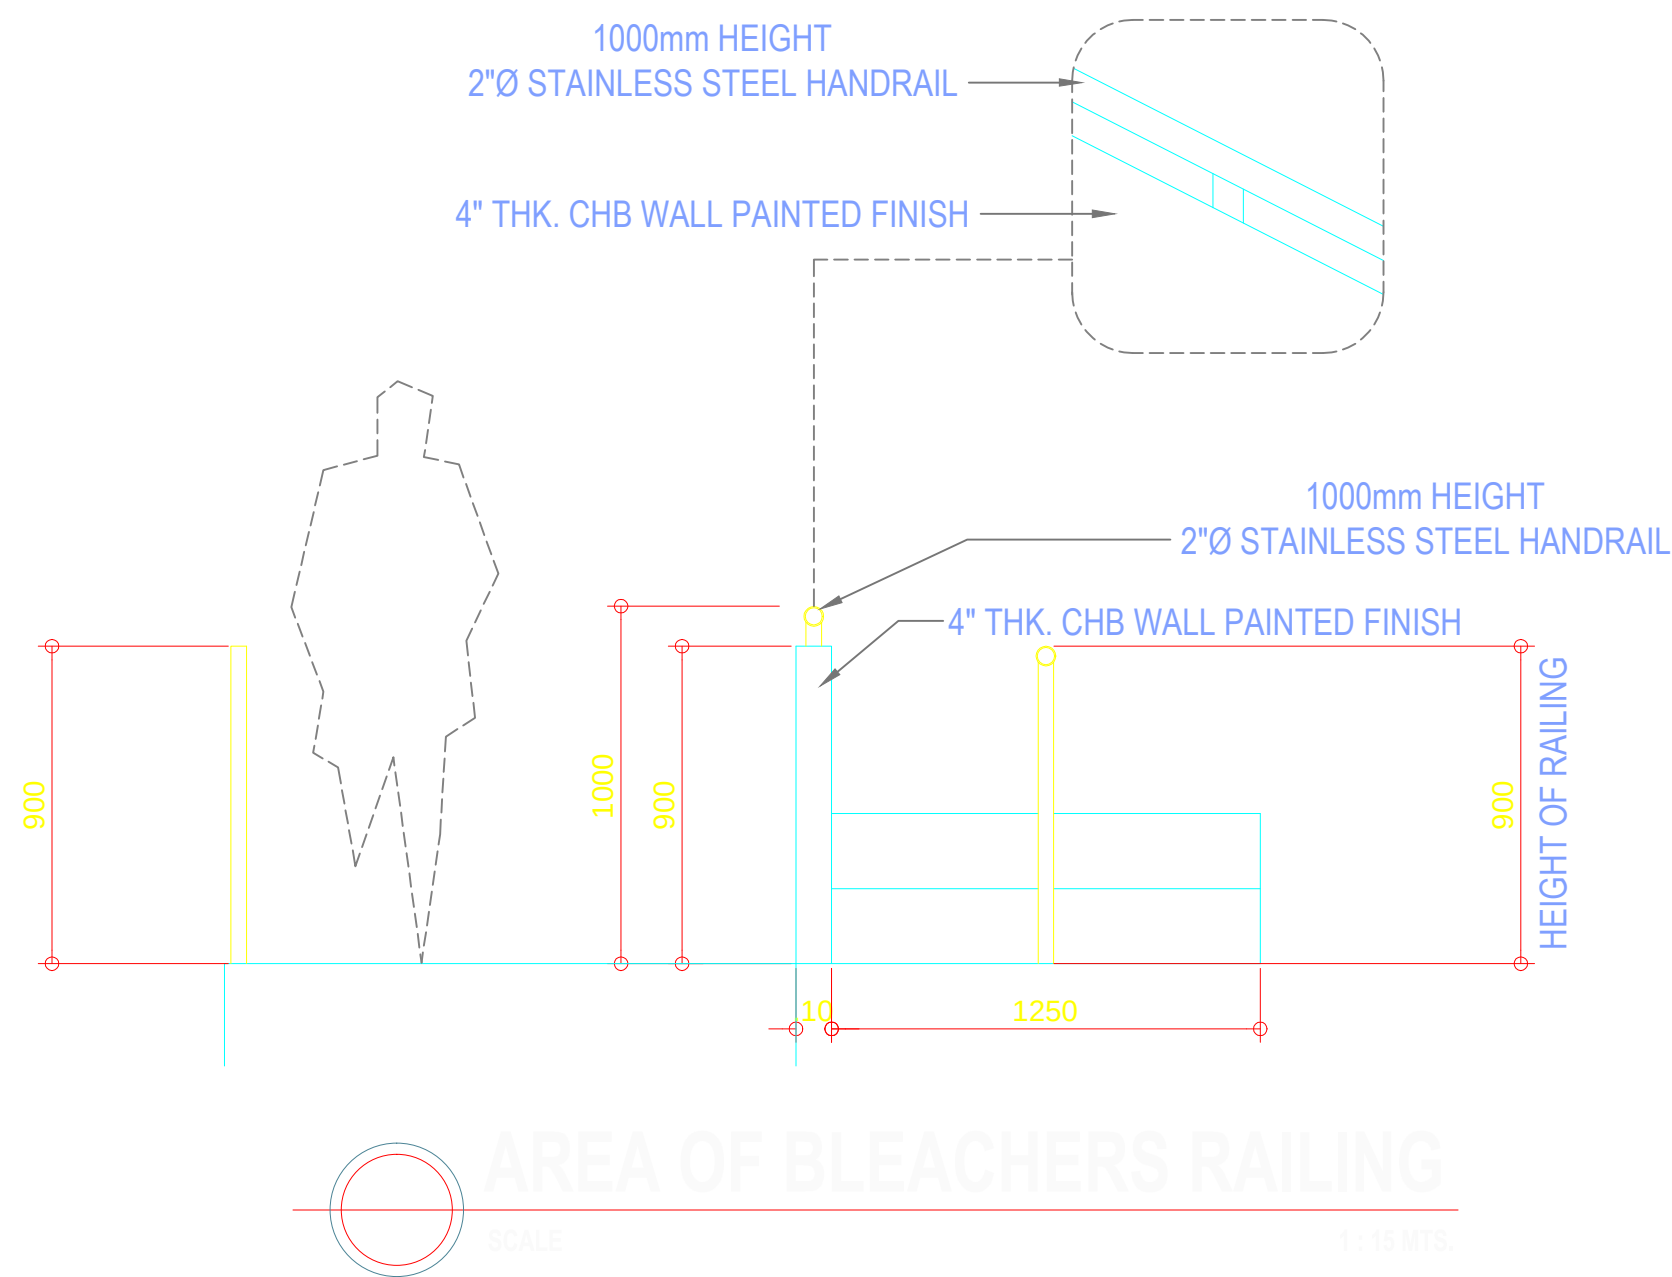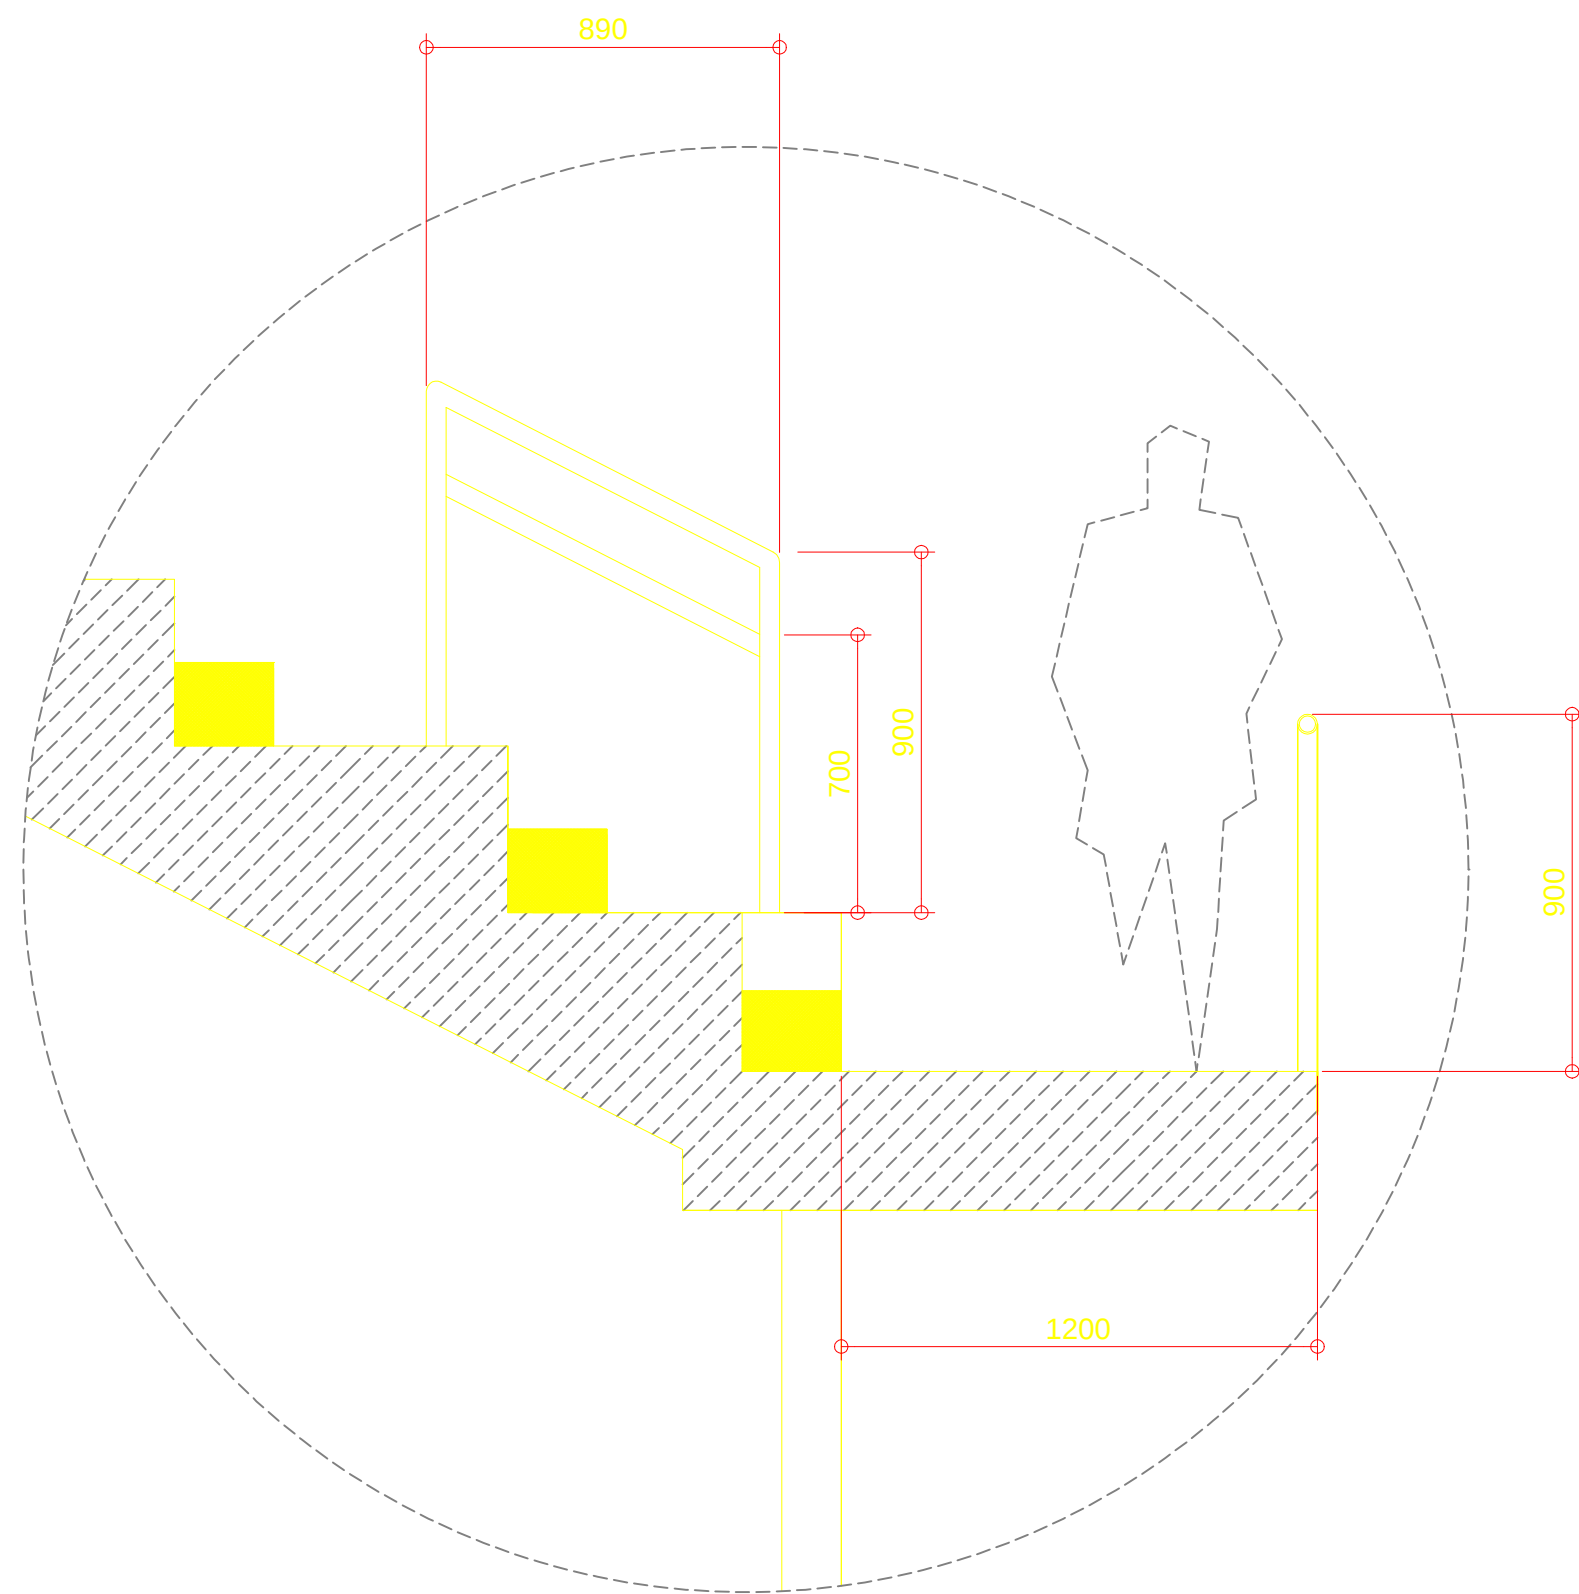


DETAIL OF RAILING @ BLEACHERS STEP
SCALE 1:15 MTS.

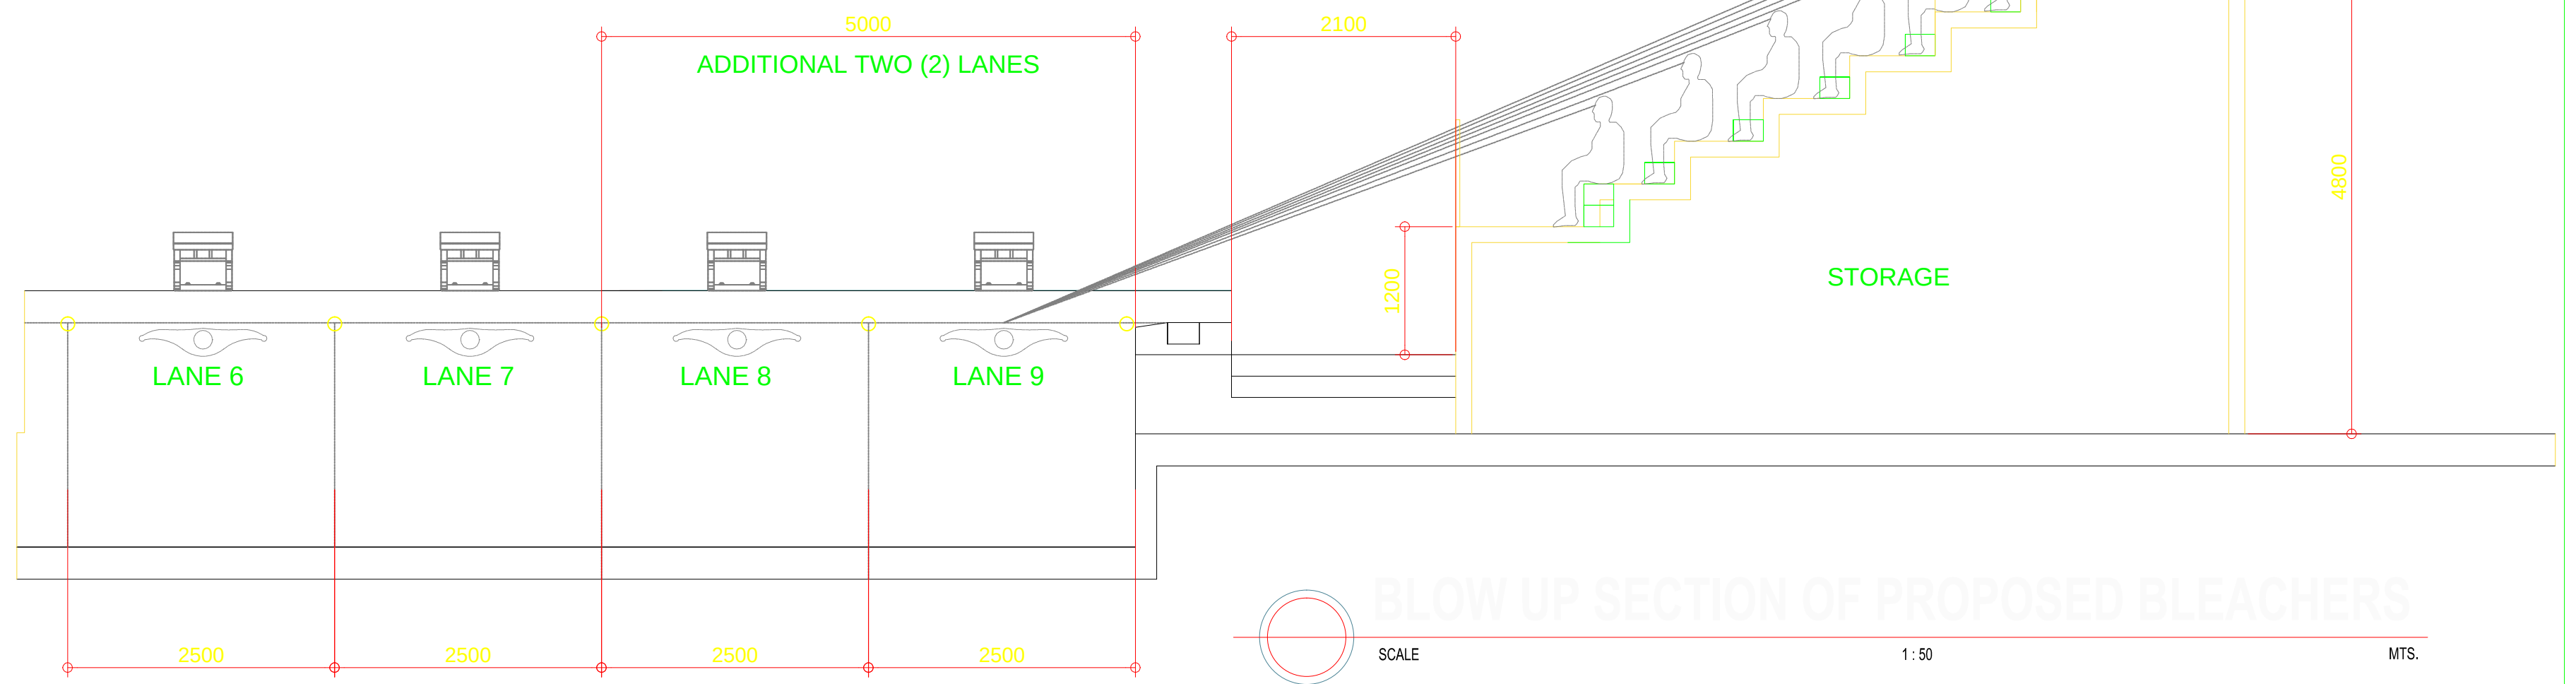


BLOW UP SECTION OF PROPOSED BLEACHERS
SCALE 1:50 MTS.

OWNER	PROJECT TITLE :	SUBMITTED BY :	RECOMMENDING APPROVAL :	APPROVED BY :	SHEET CONTENTS :	DESIGN BY :		SHEET NO :
 PHILIPPINE SPORTS COMMISSION RMSG, PABLO OCAMPO SR. ST., MALATE, MANILA	UPGRADING OF SWIMMING POOL, DIVING POOL, WARM UP POOL AND CONSTRUCTION OF NEW BLEACHERS, AND JACUZZI LOCATION: RMSG, PABLO OCAMPO SR. ST., MALATE, MANILA	ENGR. PEDRO I. PINEDA JR. HEAD - ENGINEERING UNIT	DIR. MERLITA R. IBAY DEPUTY EXECUTIVE DIRECTOR	HON. WILLIAM I. RAMIREZ CHAIRMAN	AS SHOWN	DESIGN BY :		A 9
						DRAWN BY :		
						CHECKED BY :		
						DATE :		
						APPROVED BY :		

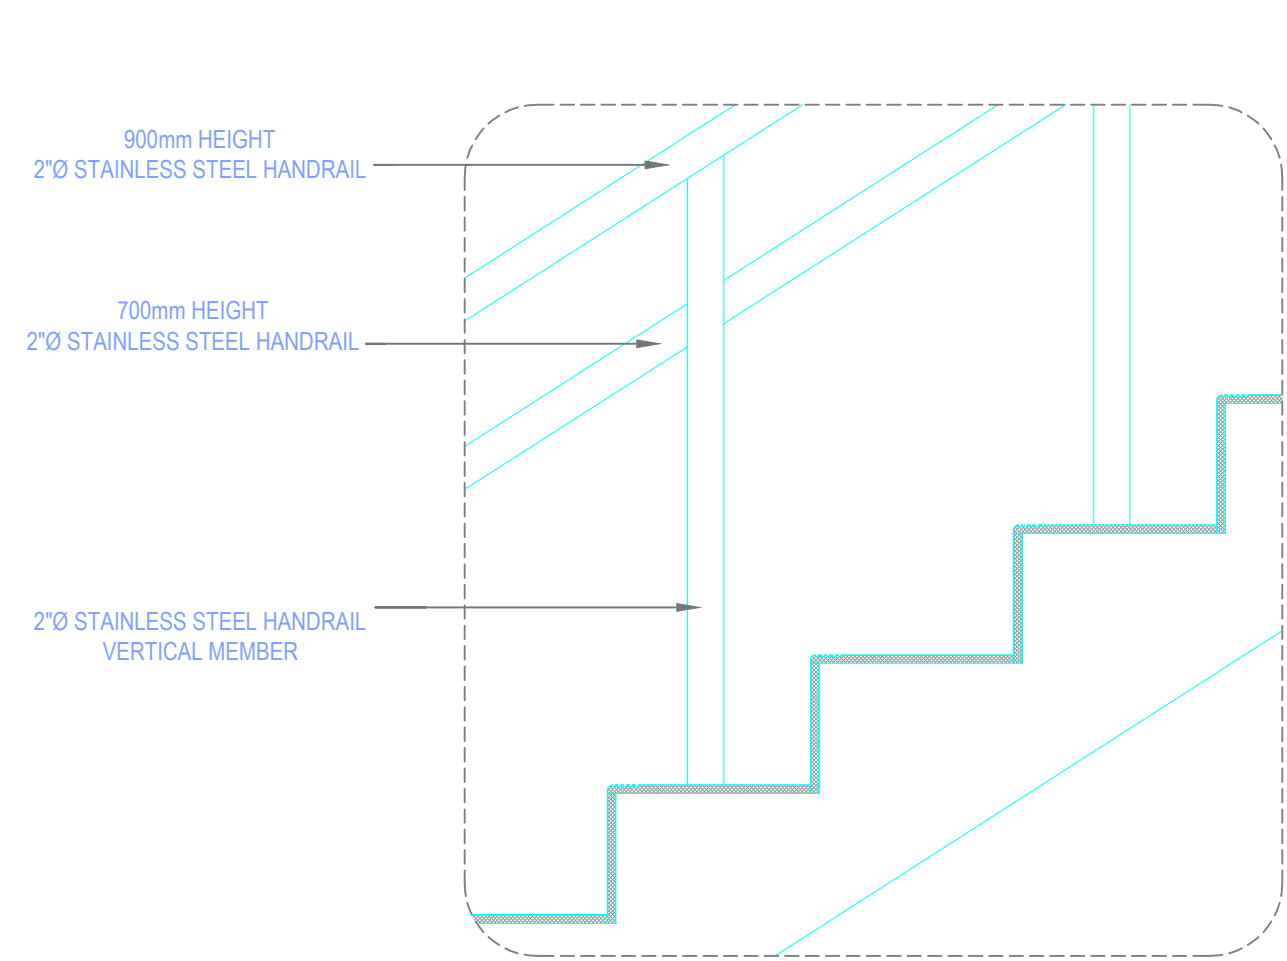


DETAIL OF RAILING

N. T. S.

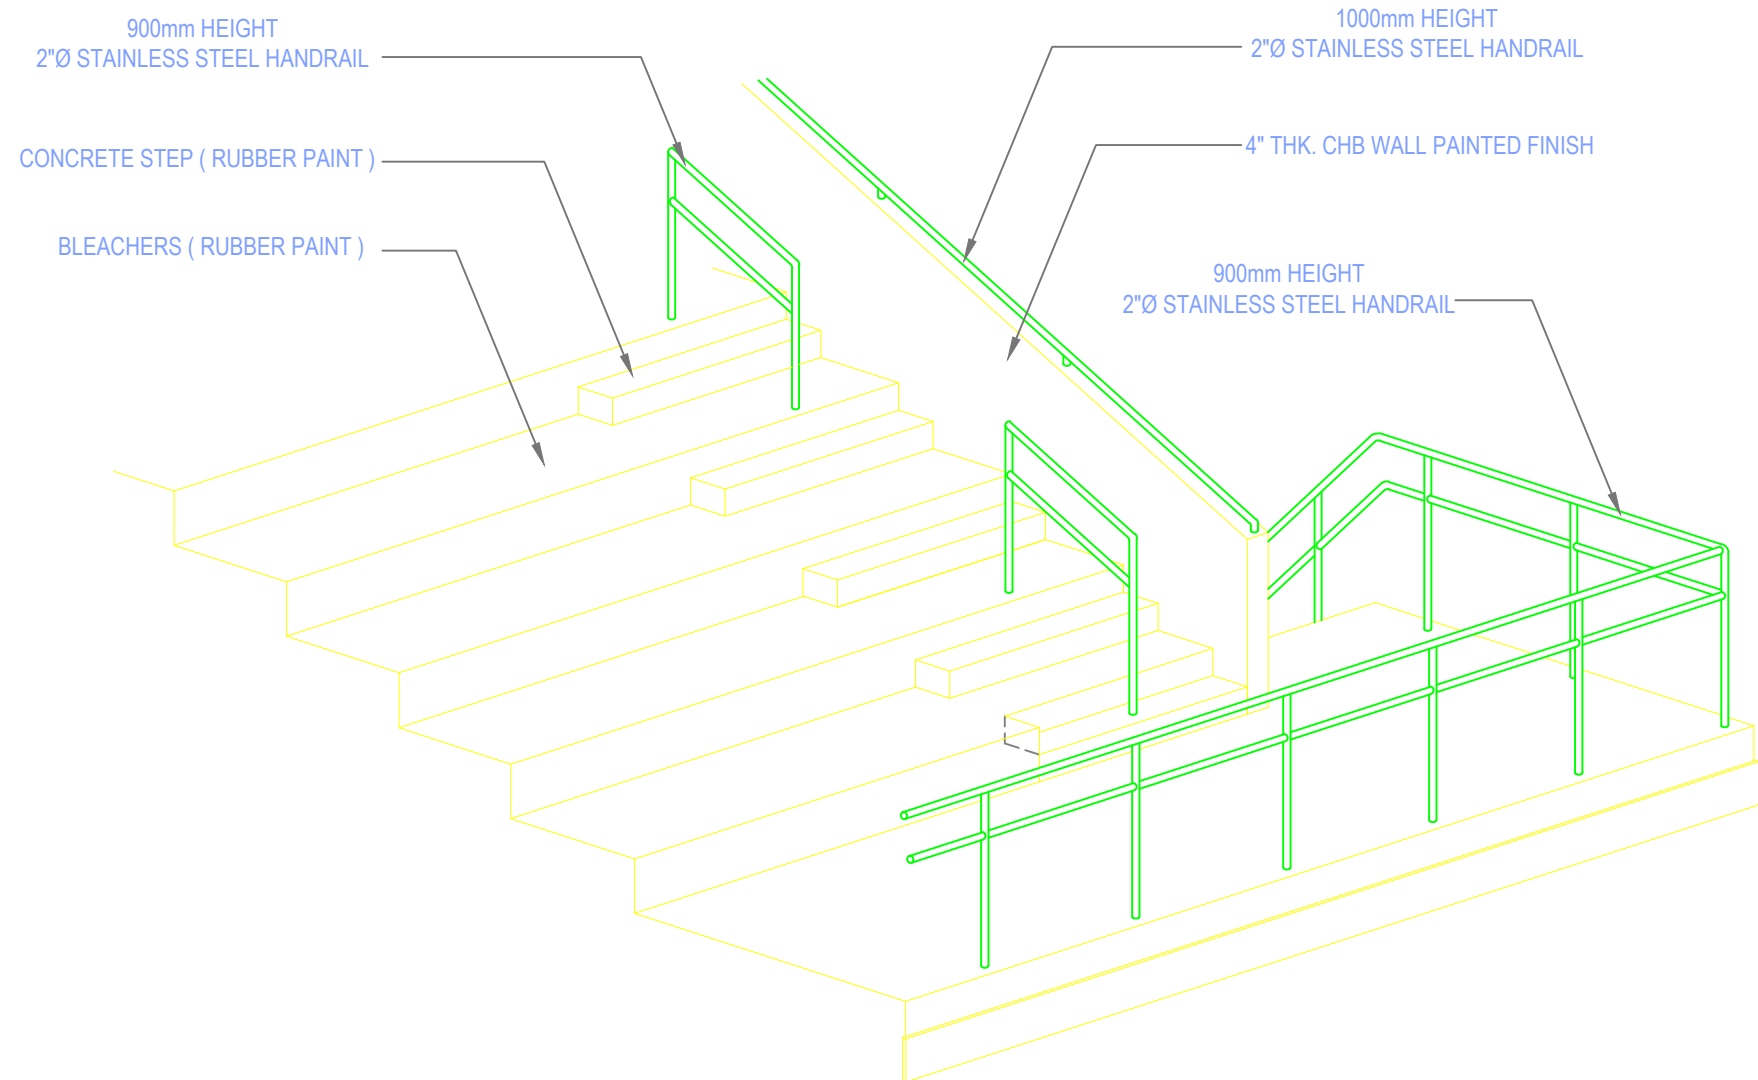

ISOMETRIC VIEW OF BLEACHERS


N. T. S.

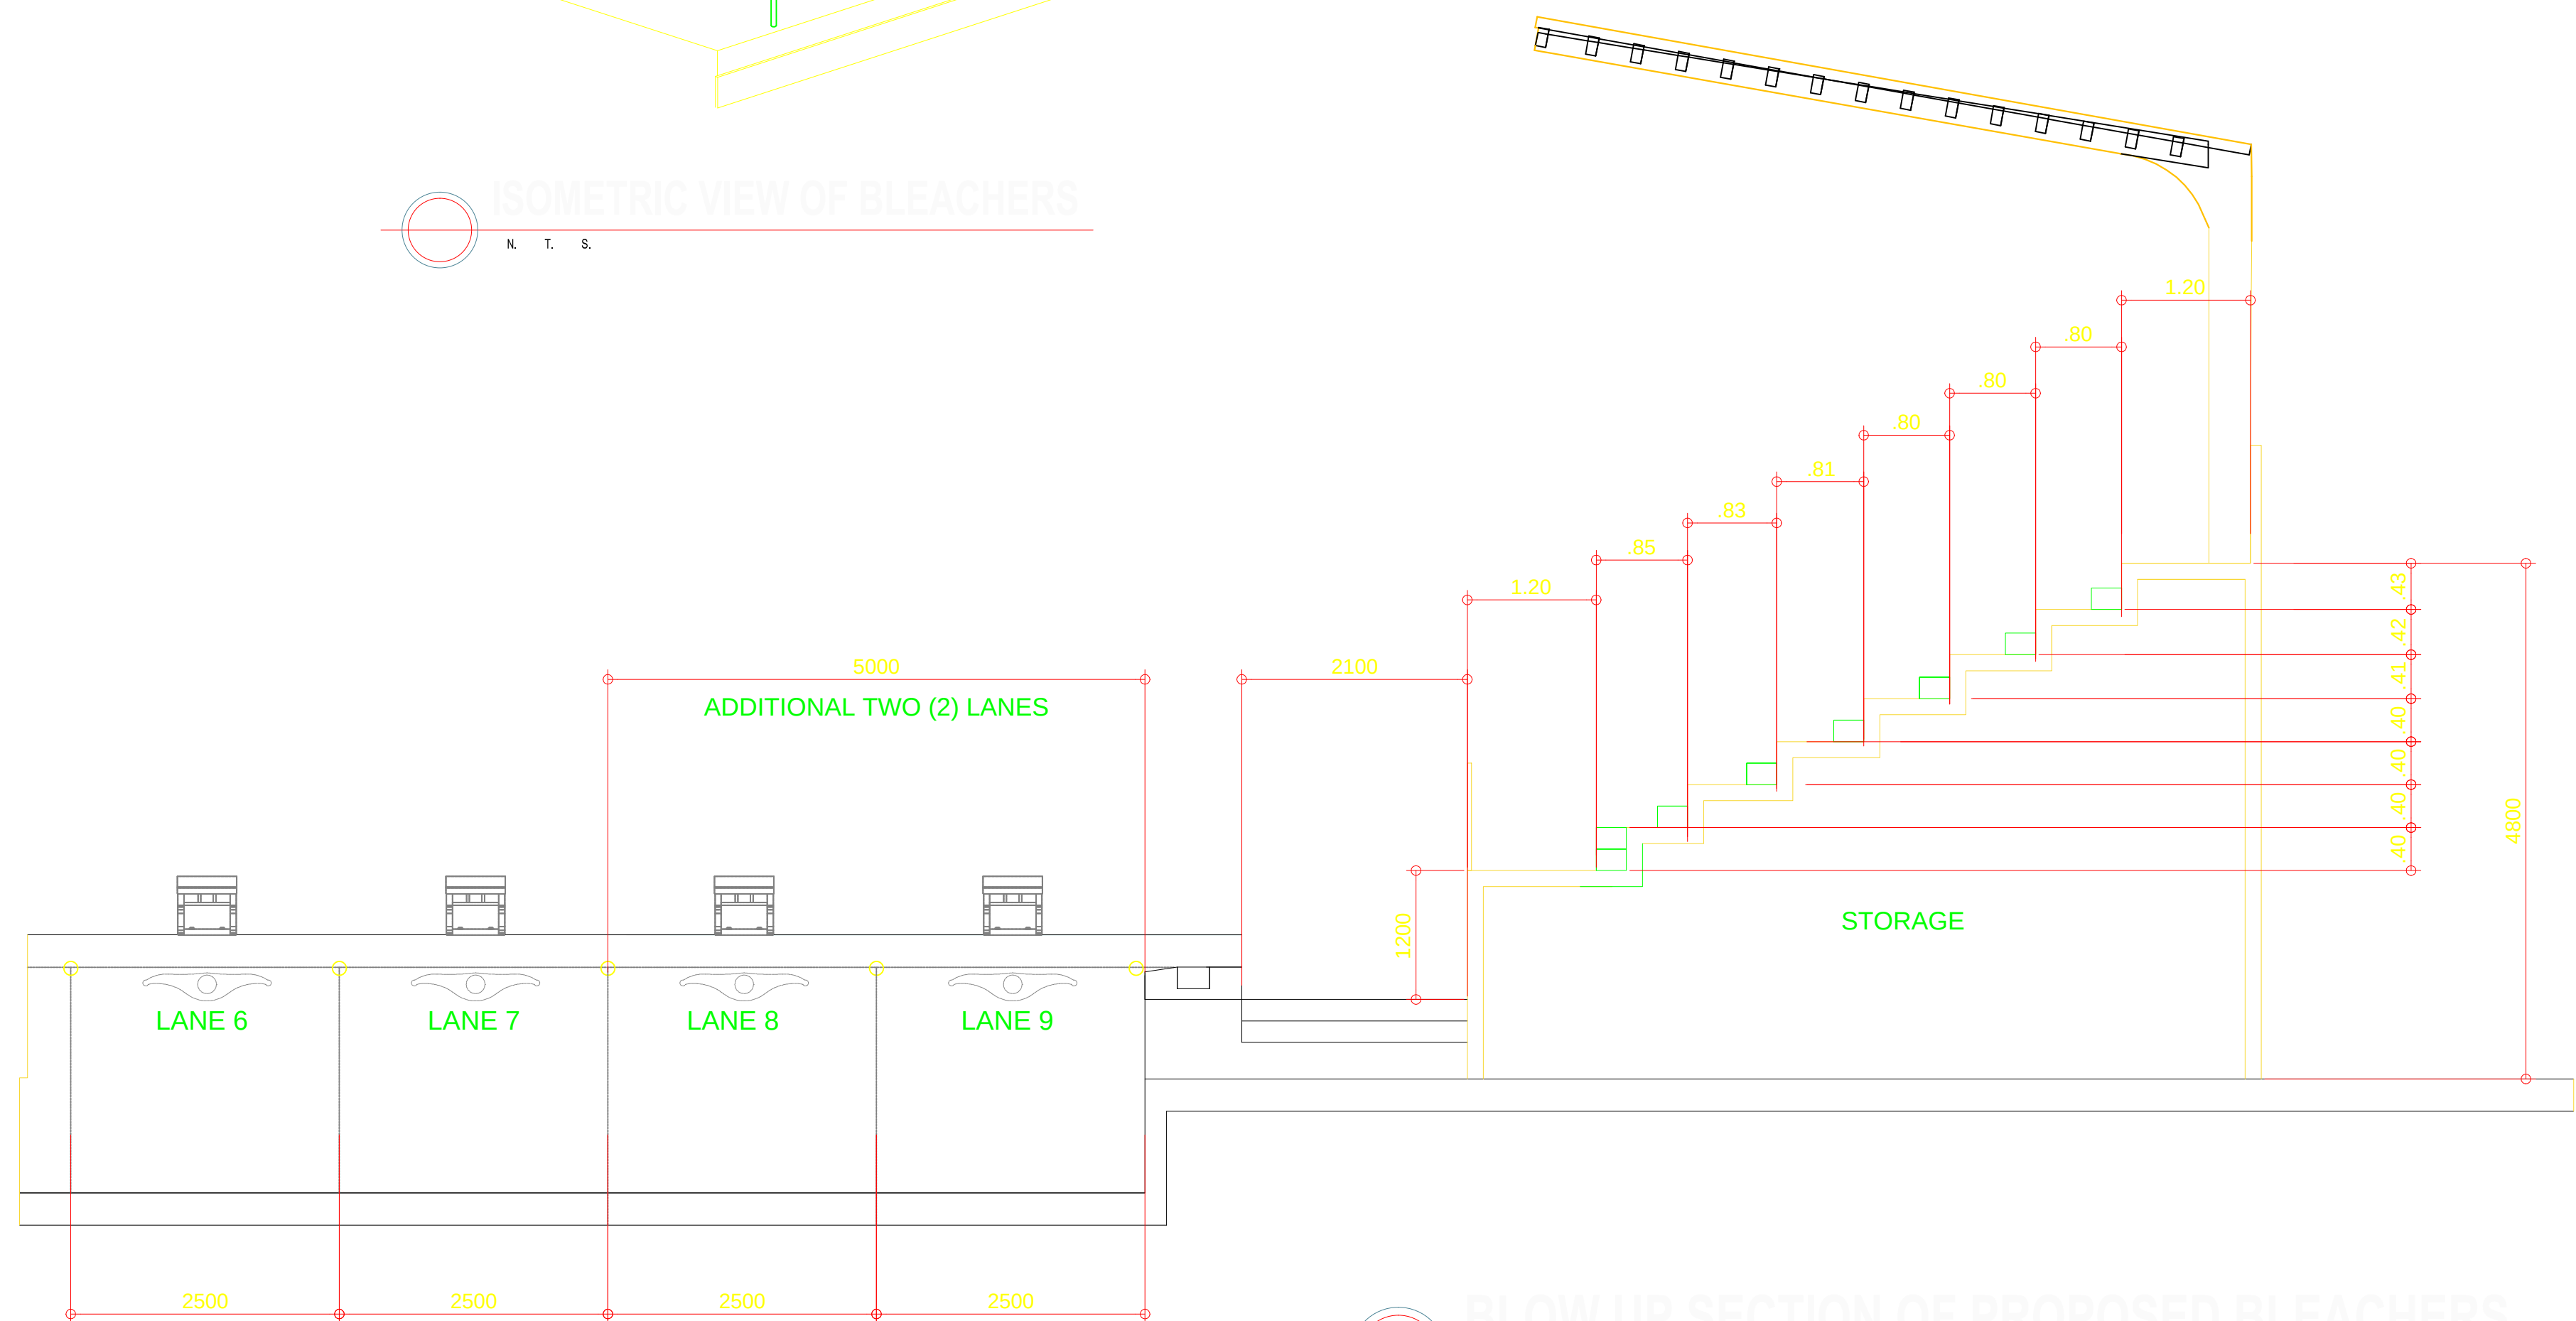

BLOW UP SECTION OF PROPOSED BLEACHERS

SCALE 1 : 50 MTS.


OWNER	PROJECT TITLE :	SUBMITTED BY :	RECOMMENDING APPROVAL :	APPROVED BY :	SHEET CONTENTS :	DESIGN BY :		SHEET NO :
 PHILIPPINE SPORTS COMMISSION RMSG, PABLO OCAMPO SR. ST., MALATE, MANILA	UPGRADING OF SWIMMING POOL, DIVING POOL, WARM UP POOL AND CONSTRUCTION OF NEW BLEACHERS,AND JACUZZI LOCATION: RMSG, PABLO OCAMPO SR. ST., MALATE, MANILA	ENGR. PEDRO I. PINEDA JR. HEAD - ENGINEERING UNIT	DIR. MERLITA R. IBAY DEPUTY EXECUTIVE DIRECTOR	HON. WILLIAM I. RAMIREZ CHAIRMAN	AS SHOWN	DRAWN BY :		A 10
						CHECKED BY :		
						DATE :		
						APPROVED BY :		

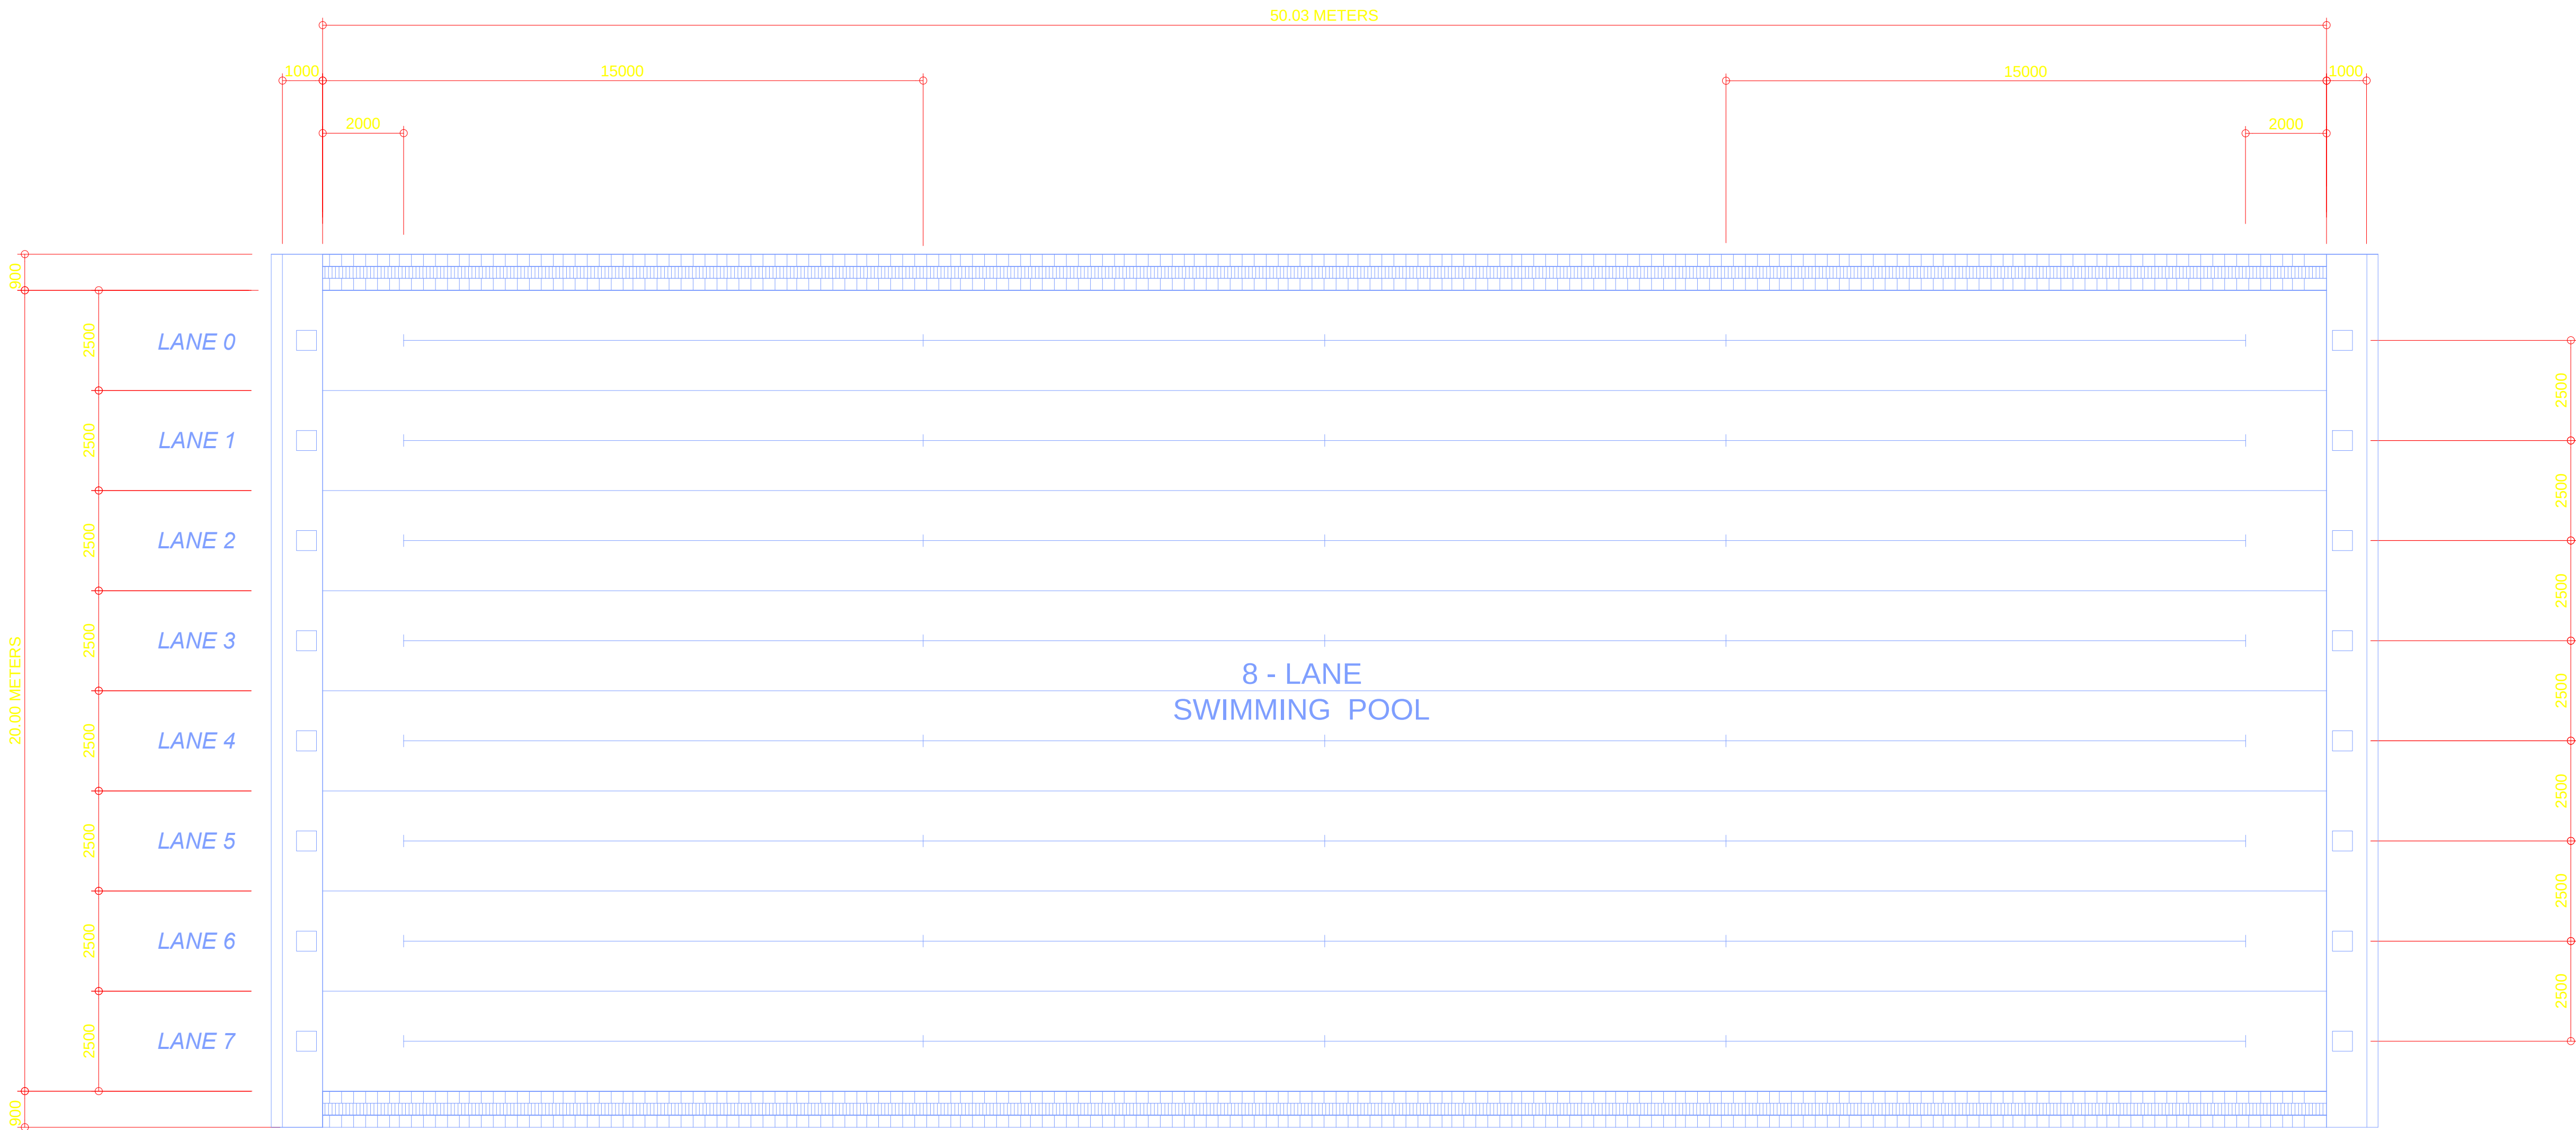

FLOOR PLAN
EXISTING SWIMMING POOL (50.03m. x 20.00m.)

SCALE 1 : 100 MTS.


OWNER	PROJECT TITLE :	SUBMITTED BY :	RECOMMENDING APPROVAL :	APPROVED BY :	SHEET CONTENTS :	DESIGN BY :		SHEET NO :
 PHILIPPINE SPORTS COMMISSION RMSG, PABLO OCAMPO SR. ST., MALATE, MANILA	UPGRADING OF SWIMMING POOL, DIVING POOL, WARM UP POOL AND CONSTRUCTION OF NEW BLEACHERS,AND JACUZZI LOCATION: RMSG, PABLO OCAMPO SR. ST., MALATE, MANILA	ENGR. PEDRO I. PINEDA JR. HEAD - ENGINEERING UNIT	DIR. MERLITA R. IBAY DEPUTY EXECUTIVE DIRECTOR	HON. WILLIAM I. RAMIREZ CHAIRMAN	AS SHOWN	DRAWN BY :		A 11
						CHECKED BY :		
						DATE :		
						APPROVED BY :		

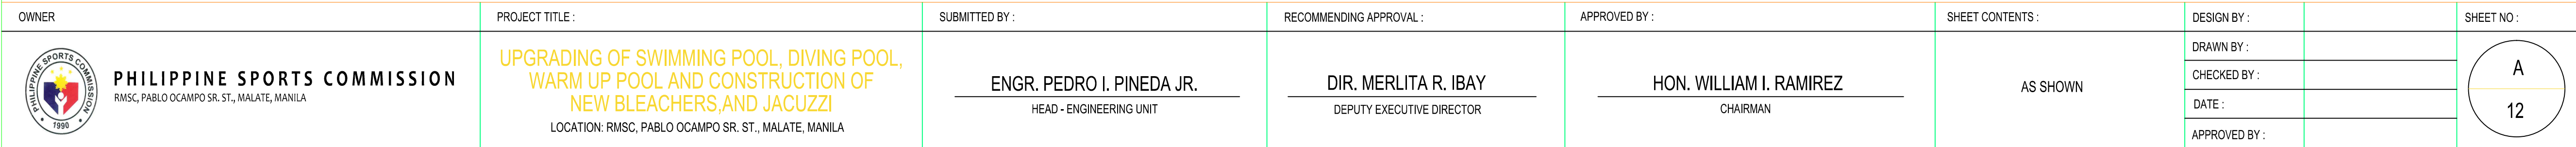




A Venn diagram with two overlapping circles, A and B. The intersection of A and B is shaded in light blue and contains the number 13.


NOTE:
1. THE FLOATER OR LANE LINE SHALL BE ANTI-WAVE AND WITH APPROPRIATE CLAMP ROPE HOOK.

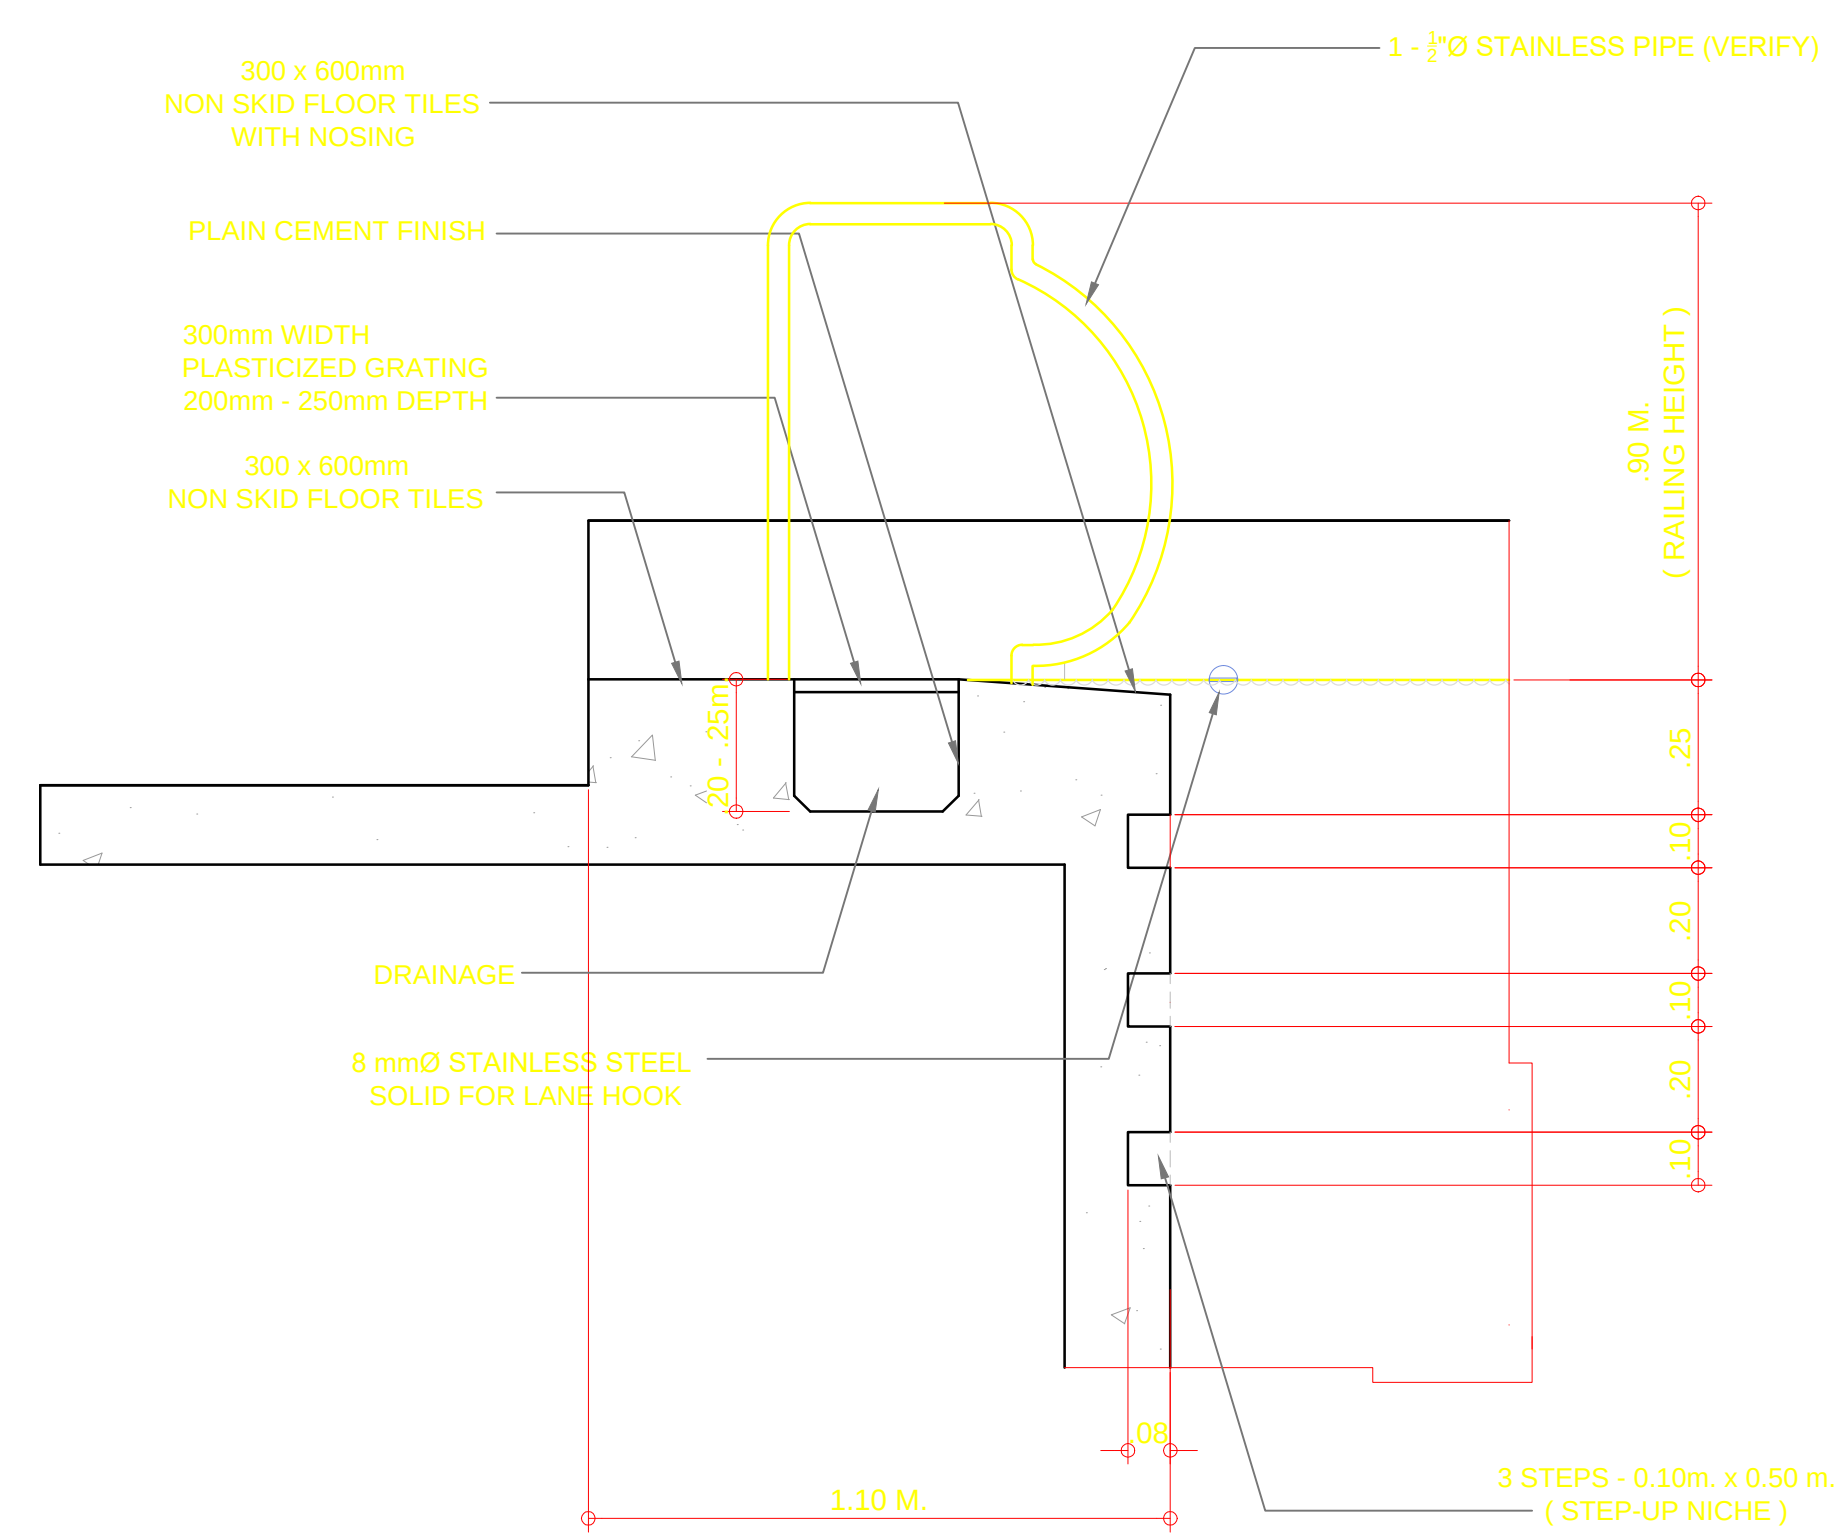



DETAIL OF RAILING AND POOL STEPS
SCALE 1:10 MTS.

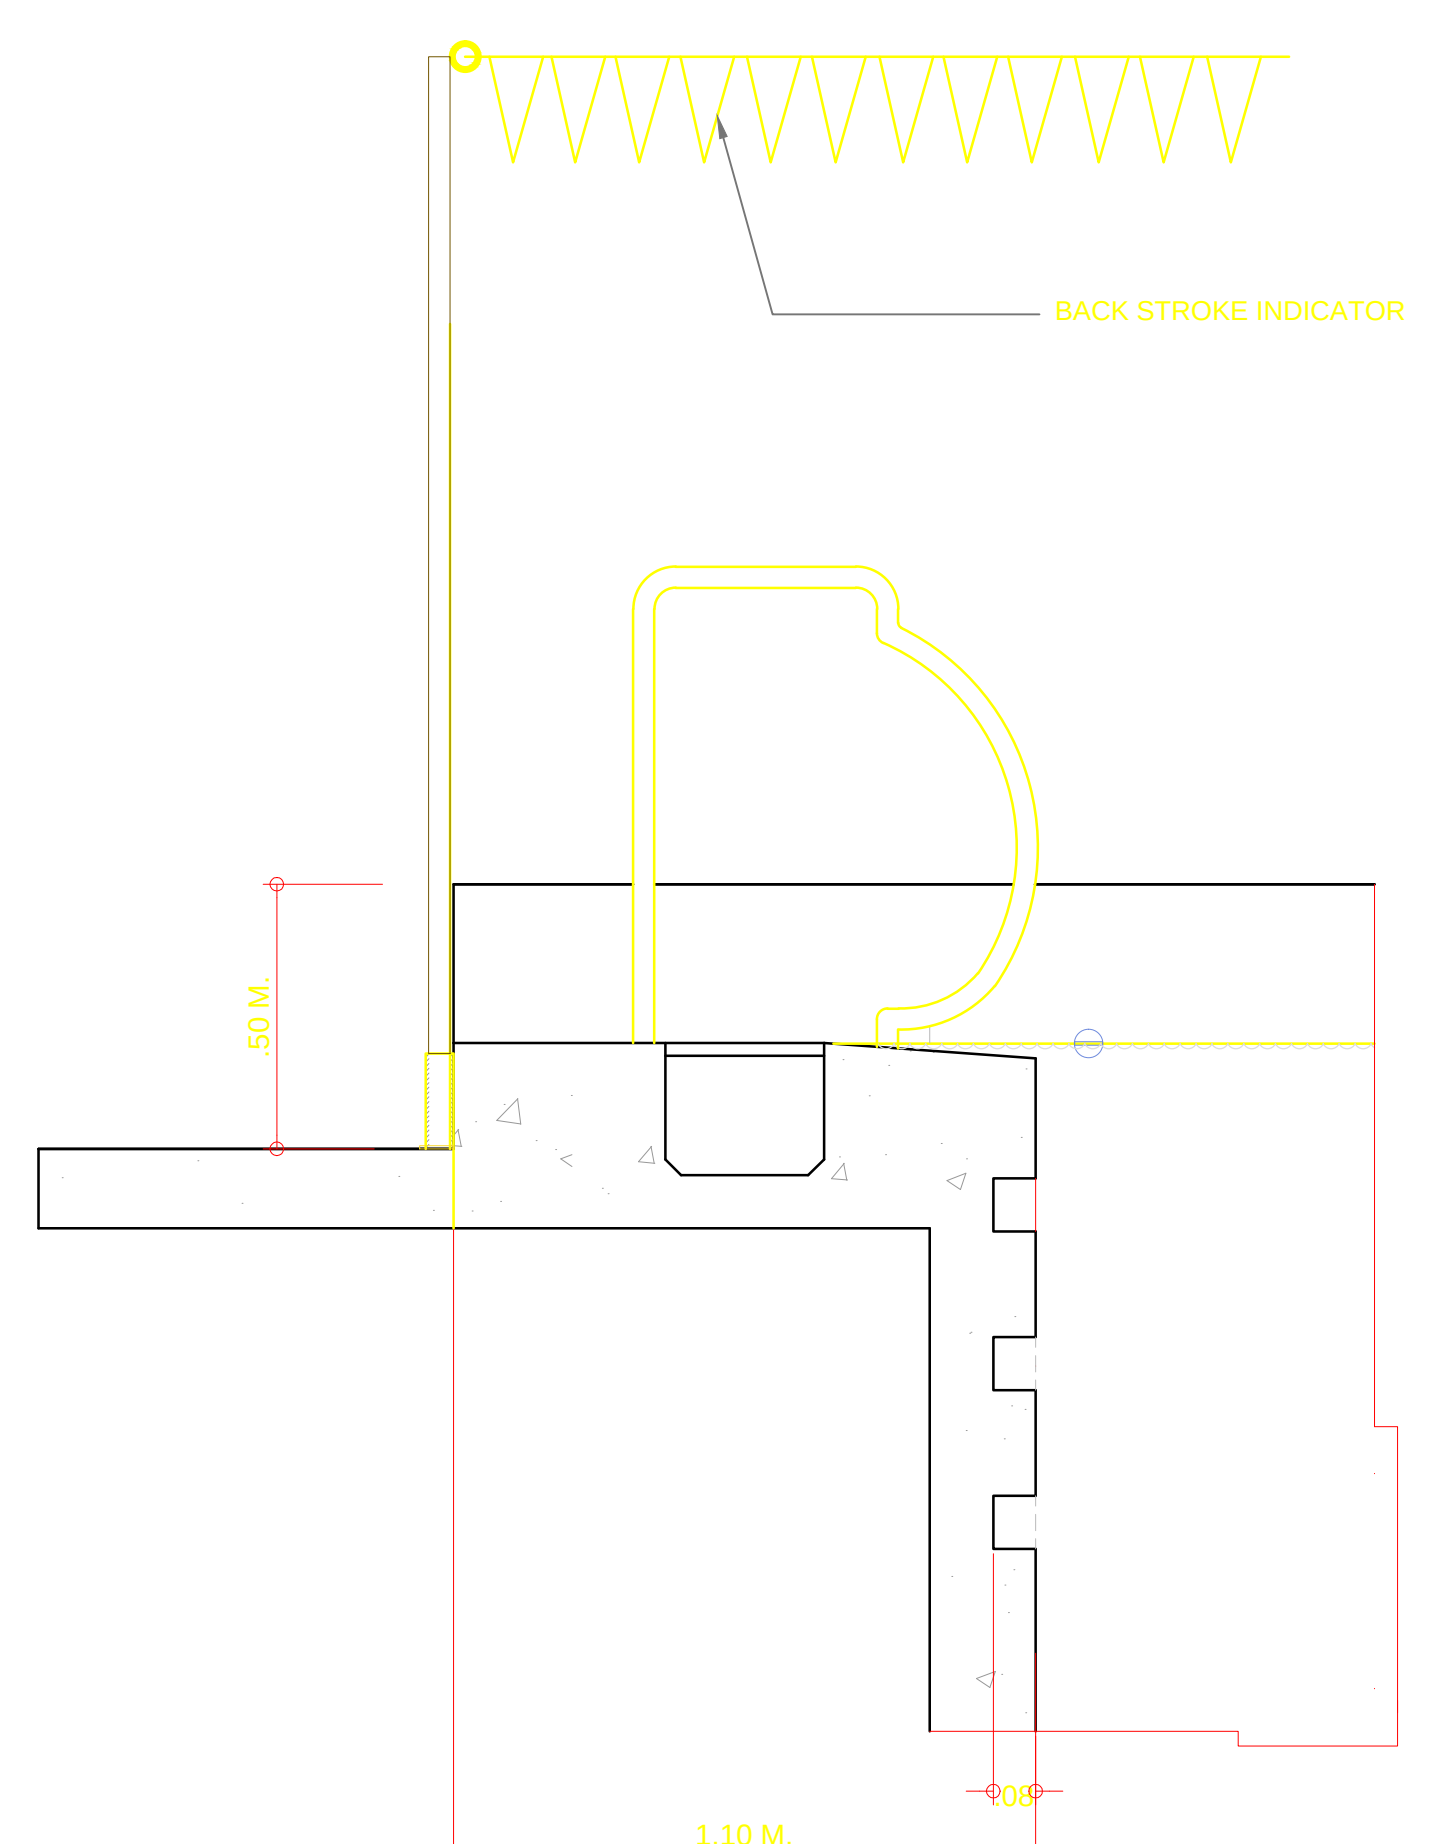


BACKSTROKE INDICATOR
SCALE 1:10 MTS.

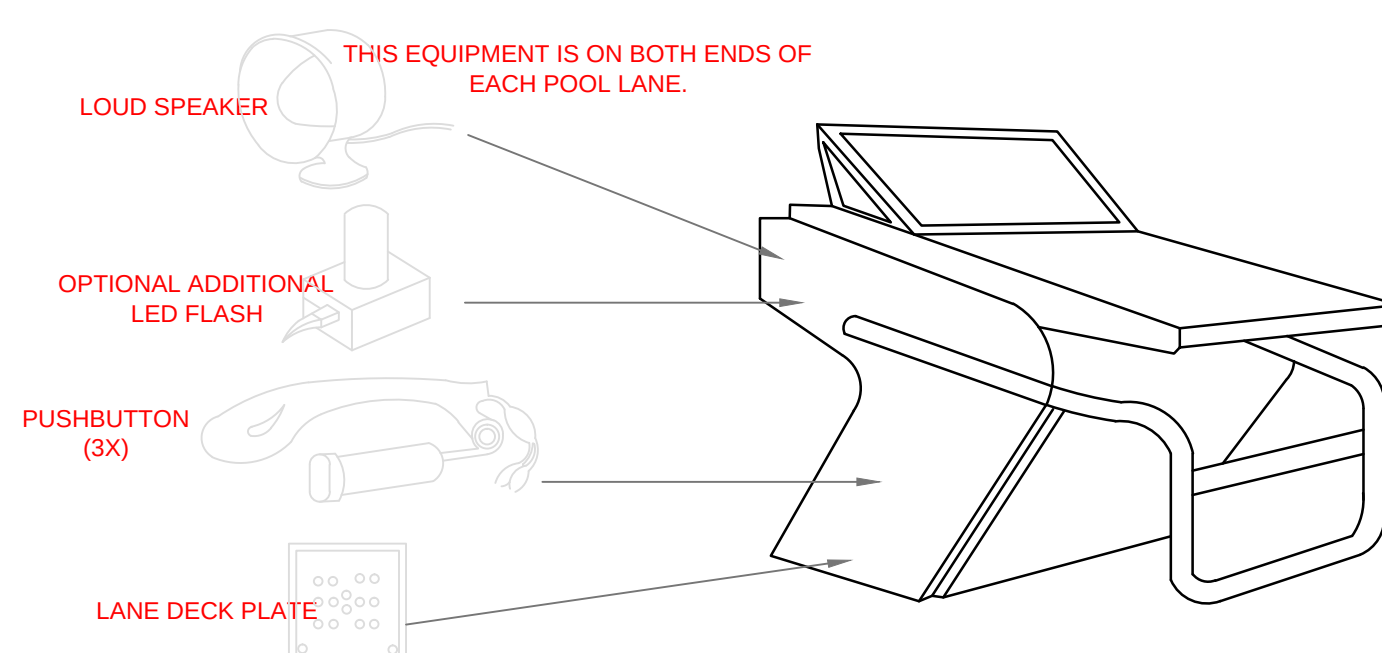


DETAIL OF STARTING BLOCK
N. T. S.

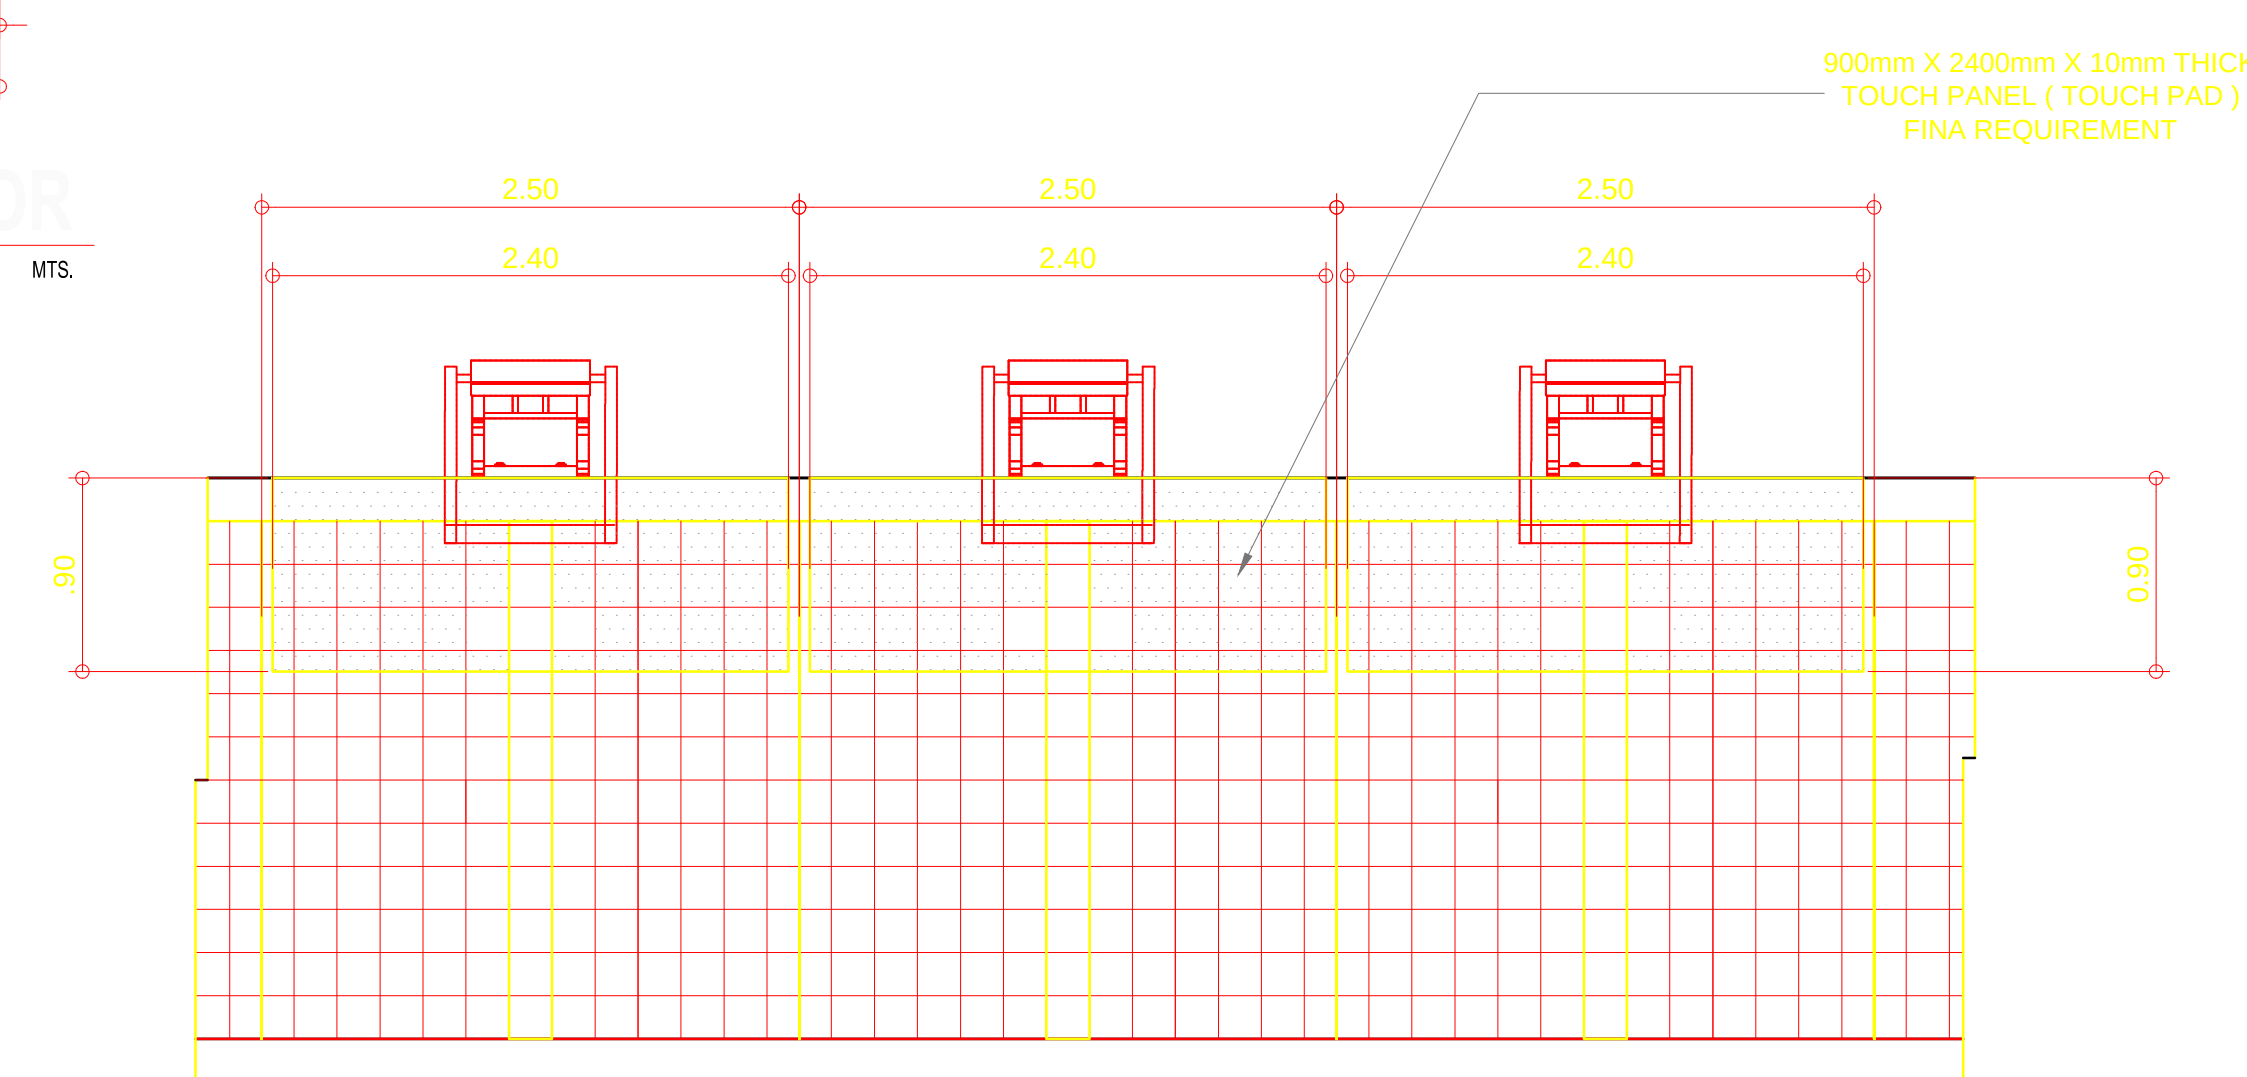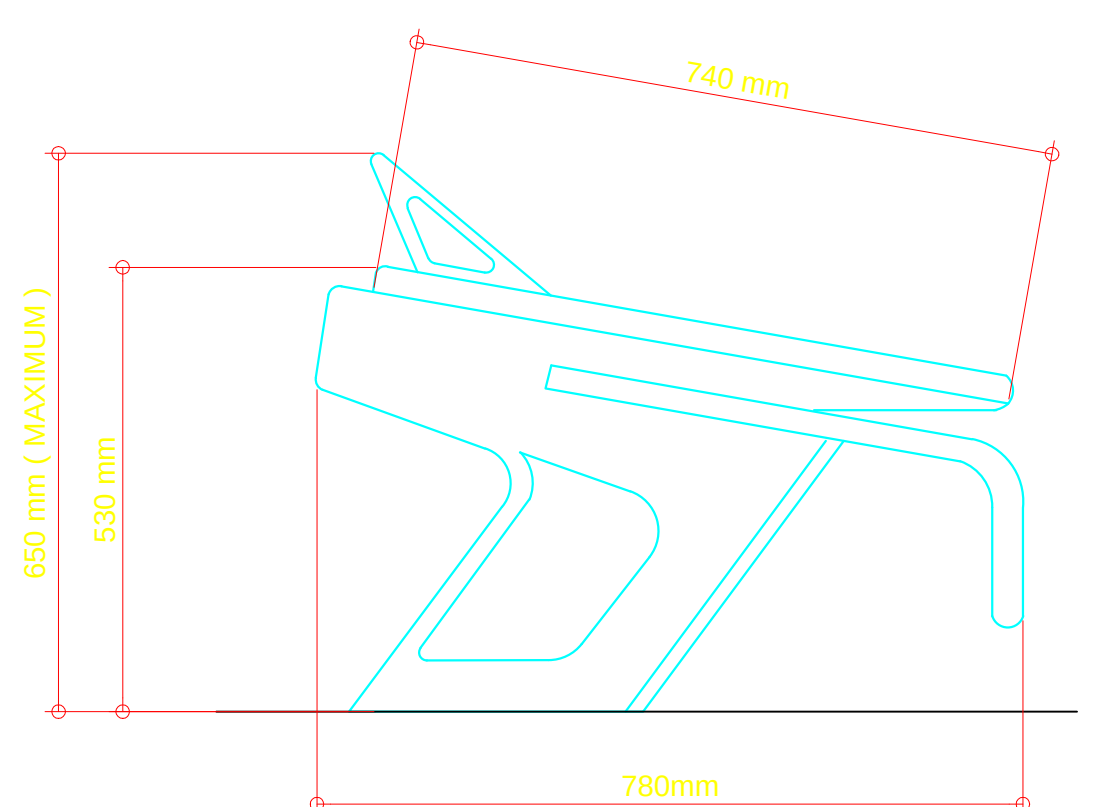



FRONT VIEW
DETAIL OF TOUCH PANEL
N. T. S.

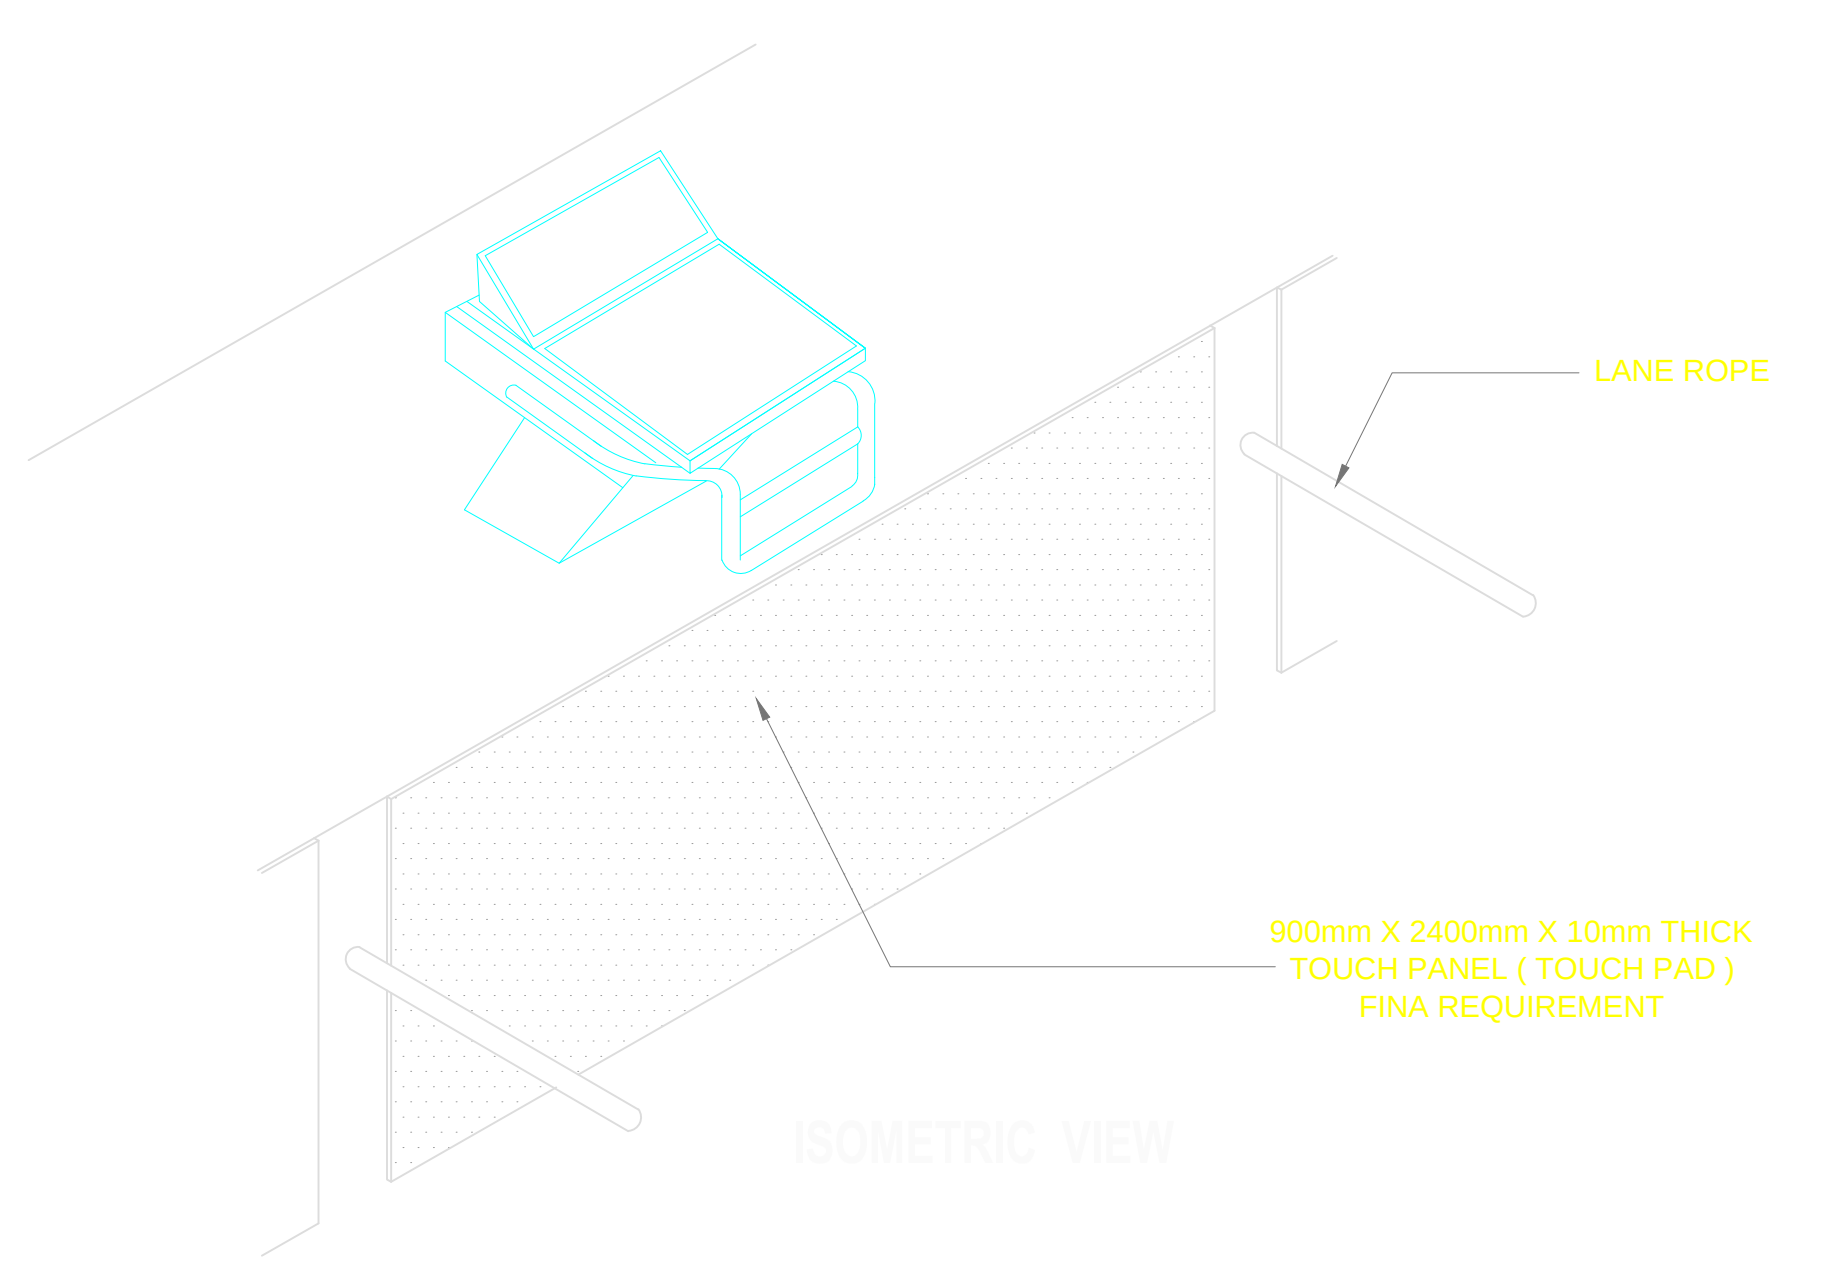


OWNER	PROJECT TITLE :	SUBMITTED BY :	RECOMMENDING APPROVAL :	APPROVED BY :	SHEET CONTENTS :	DESIGN BY :	SHEET NO :
 PHILIPPINE SPORTS COMMISSION RMSC, PABLO OCAMPO SR. ST., MALATE, MANILA	UPGRADING OF SWIMMING POOL, DIVING POOL, WARM UP POOL AND CONSTRUCTION OF NEW BLEACHERS,AND JACUZZI LOCATION: RMSC, PABLO OCAMPO SR. ST., MALATE, MANILA	ENGR. PEDRO I. PINEDA JR. HEAD - ENGINEERING UNIT	DIR. MERLITA R. IBAY DEPUTY EXECUTIVE DIRECTOR	HON. WILLIAM I. RAMIREZ CHAIRMAN	AS SHOWN	DRAWN BY :	A 14
						CHECKED BY :	
						DATE :	
						APPROVED BY :	

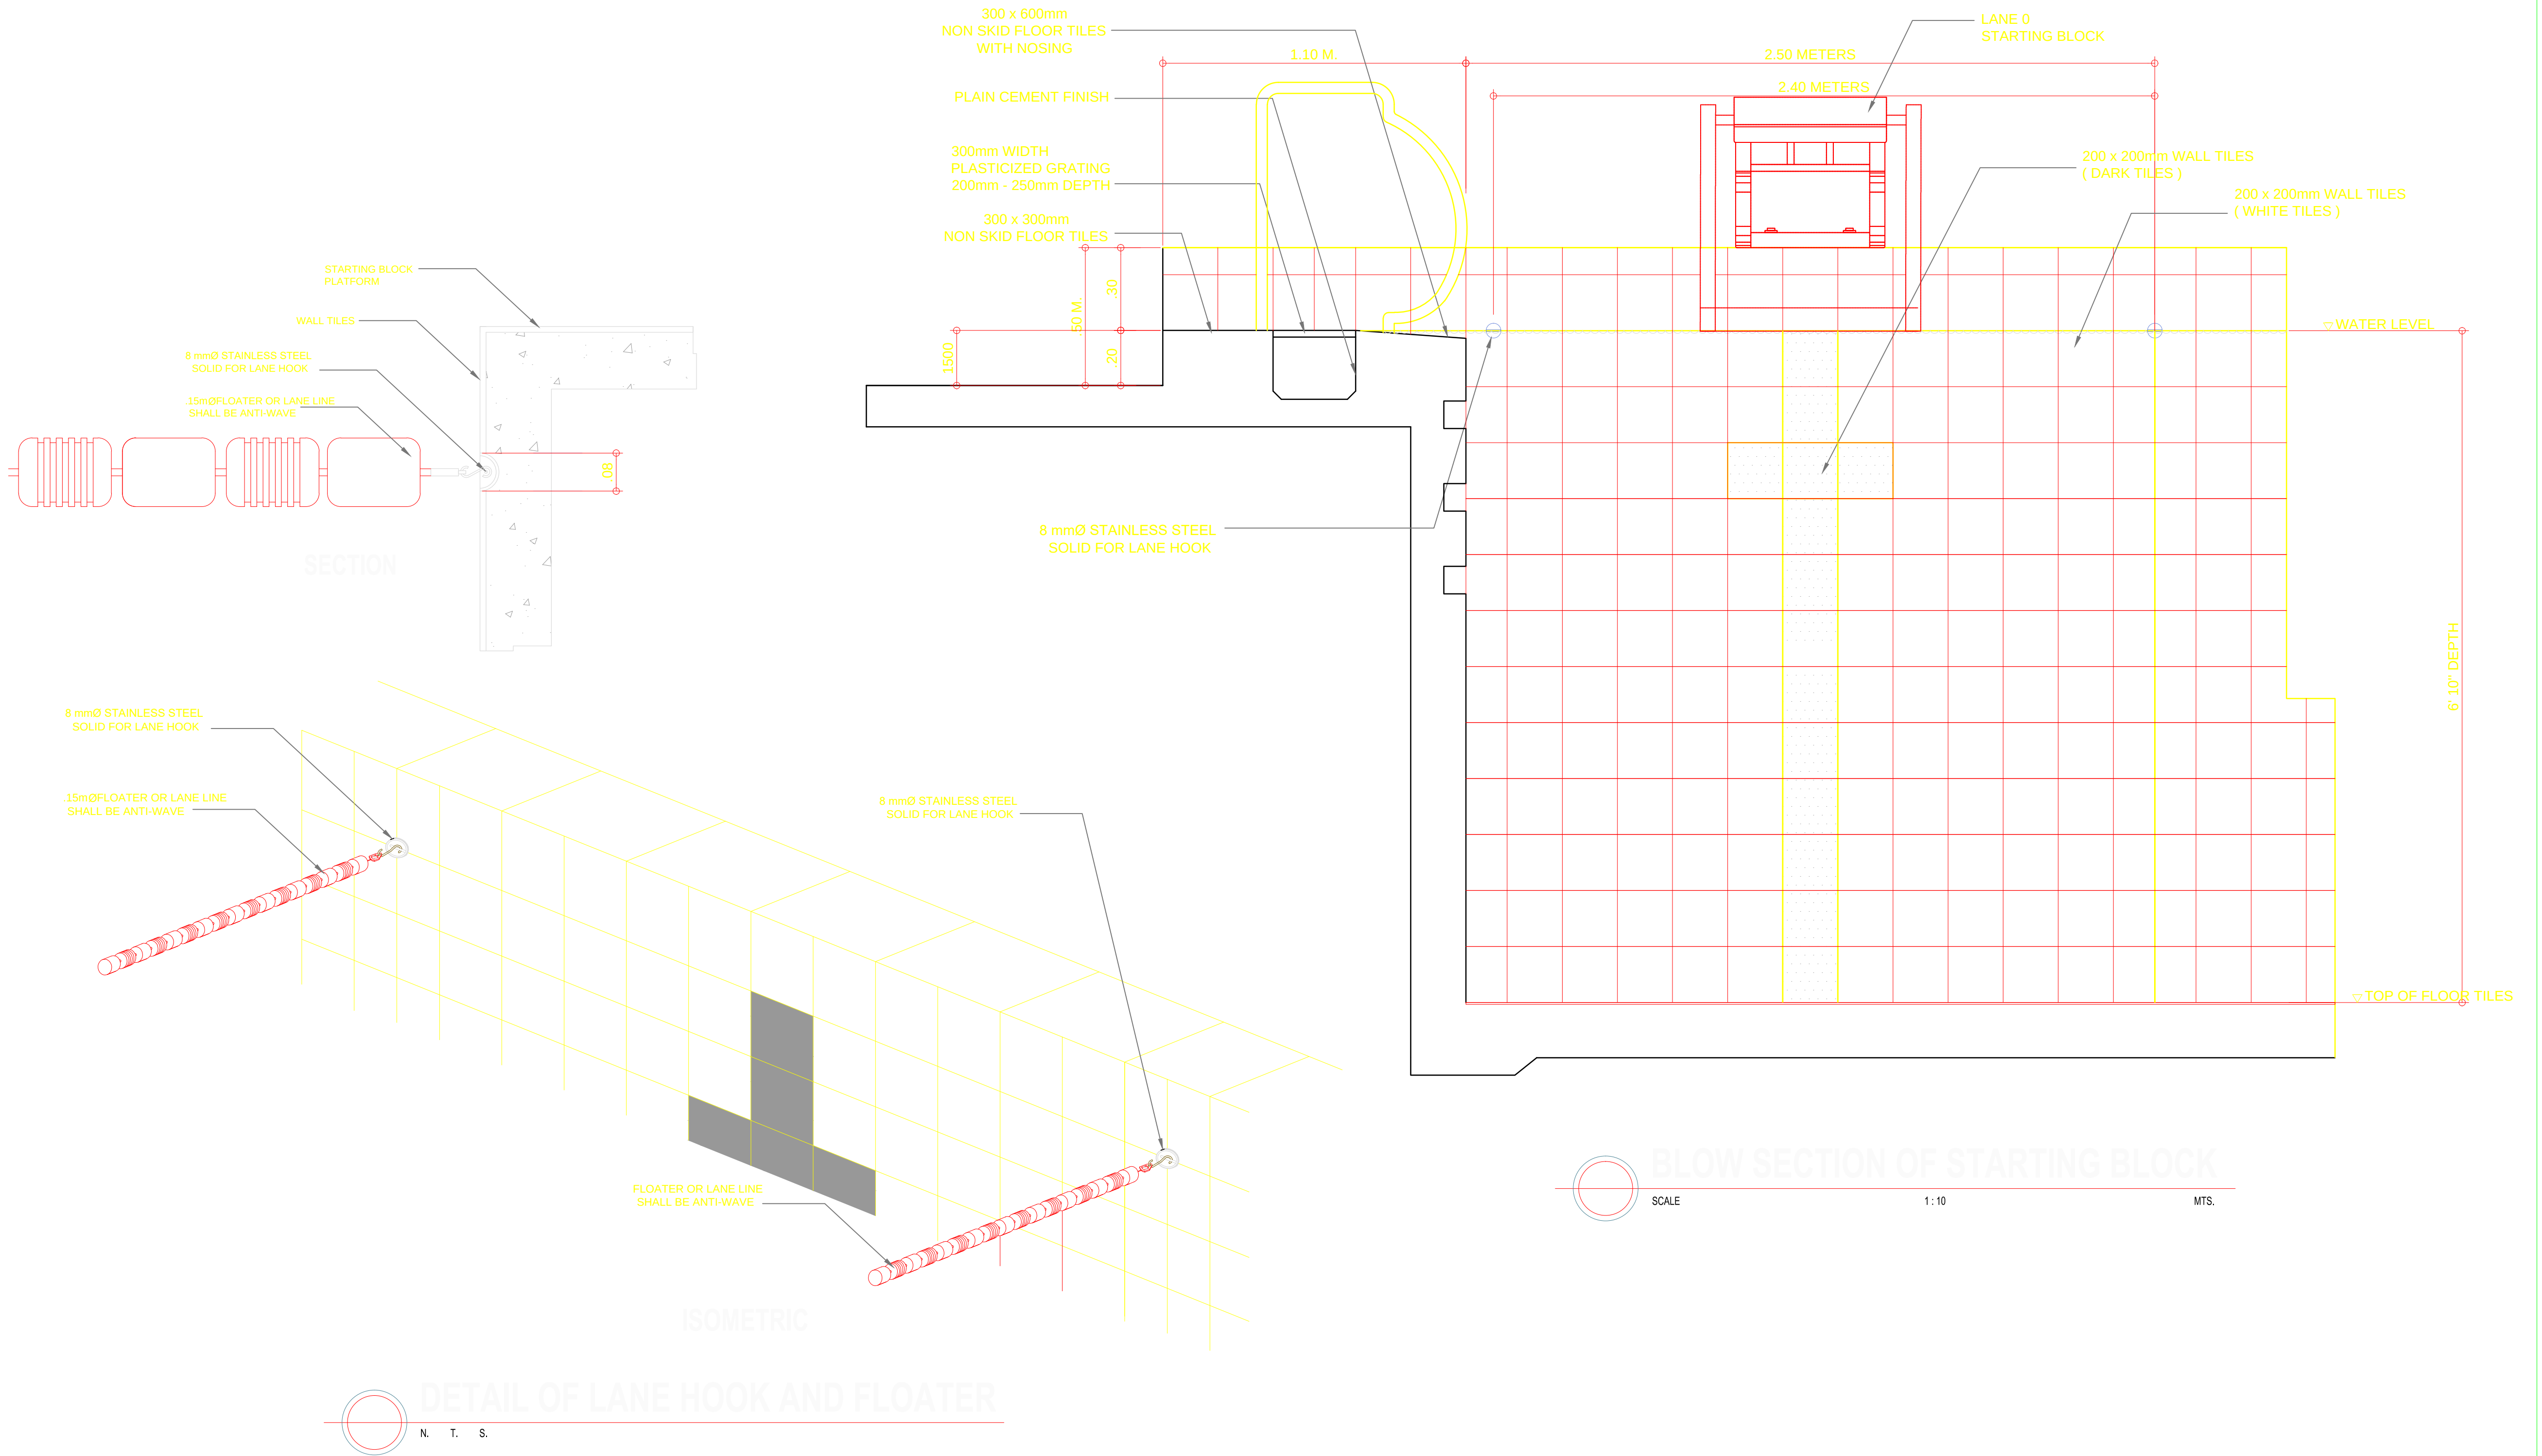

 
OWNER	PROJECT TITLE :	SUBMITTED BY :	RECOMMENDING APPROVAL :	APPROVED BY :	SHEET CONTENTS :	DESIGN BY :	SHEET NO :
 PHILIPPINE SPORTS COMMISSION RMSC, PABLO OCAMPO SR. ST., MALATE, MANILA	UPGRADING OF SWIMMING POOL, DIVING POOL, WARM UP POOL AND CONSTRUCTION OF NEW BLEACHERS,AND JACUZZI LOCATION: RMSC, PABLO OCAMPO SR. ST., MALATE, MANILA	ENGR. PEDRO I. PINEDA JR. HEAD - ENGINEERING UNIT	DIR. MERLITA R. IBAY DEPUTY EXECUTIVE DIRECTOR	HON. WILLIAM I. RAMIREZ CHAIRMAN	AS SHOWN	DRAWN BY :	A 15
						CHECKED BY :	
						DATE :	
						APPROVED BY :	

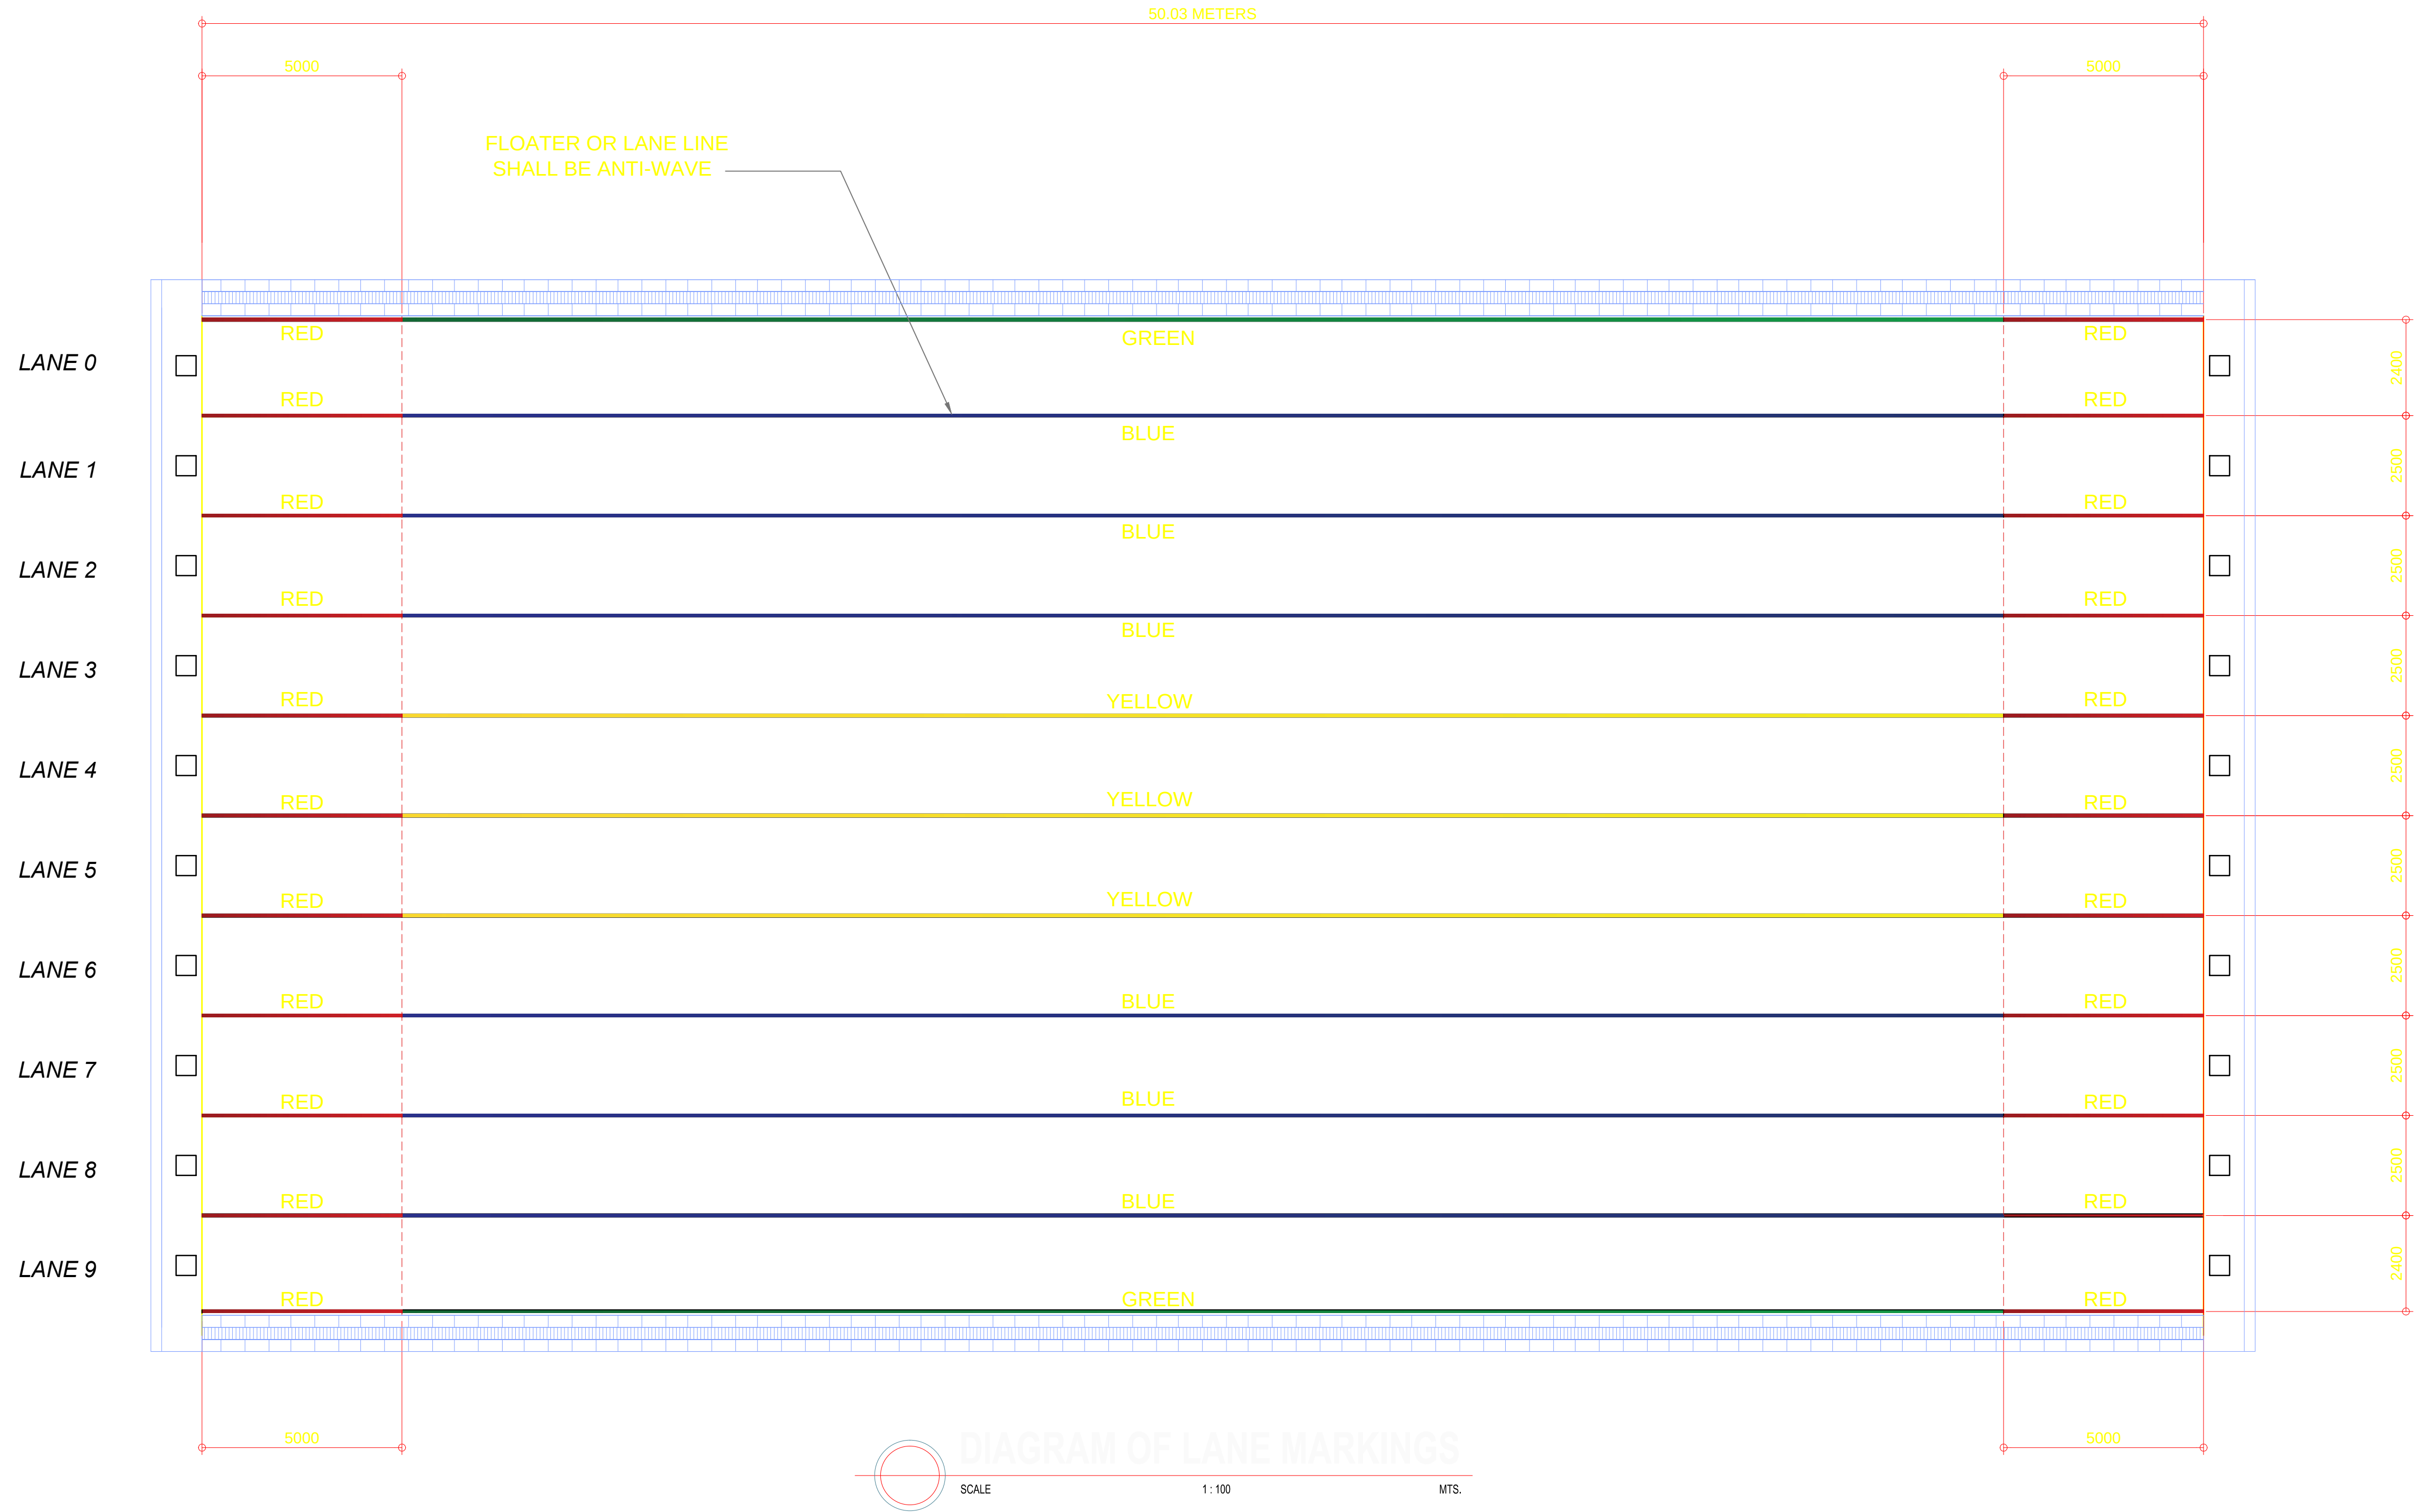


OWNER	PROJECT TITLE :	SUBMITTED BY :	RECOMMENDING APPROVAL :	APPROVED BY :	SHEET CONTENTS :	DESIGN BY :		SHEET NO :
 PHILIPPINE SPORTS COMMISSION RMSG, PABLO OCAMPO SR. ST., MALATE, MANILA	UPGRADING OF SWIMMING POOL, DIVING POOL, WARM UP POOL AND CONSTRUCTION OF NEW BLEACHERS,AND JACUZZI LOCATION: RMSG, PABLO OCAMPO SR. ST., MALATE, MANILA	ENGR. PEDRO I. PINEDA JR. HEAD - ENGINEERING UNIT	DIR. MERLITA R. IBAY DEPUTY EXECUTIVE DIRECTOR	HON. WILLIAM I. RAMIREZ CHAIRMAN	AS SHOWN	DRAWN BY :		A 16
						CHECKED BY :		
						DATE :		
						APPROVED BY :		

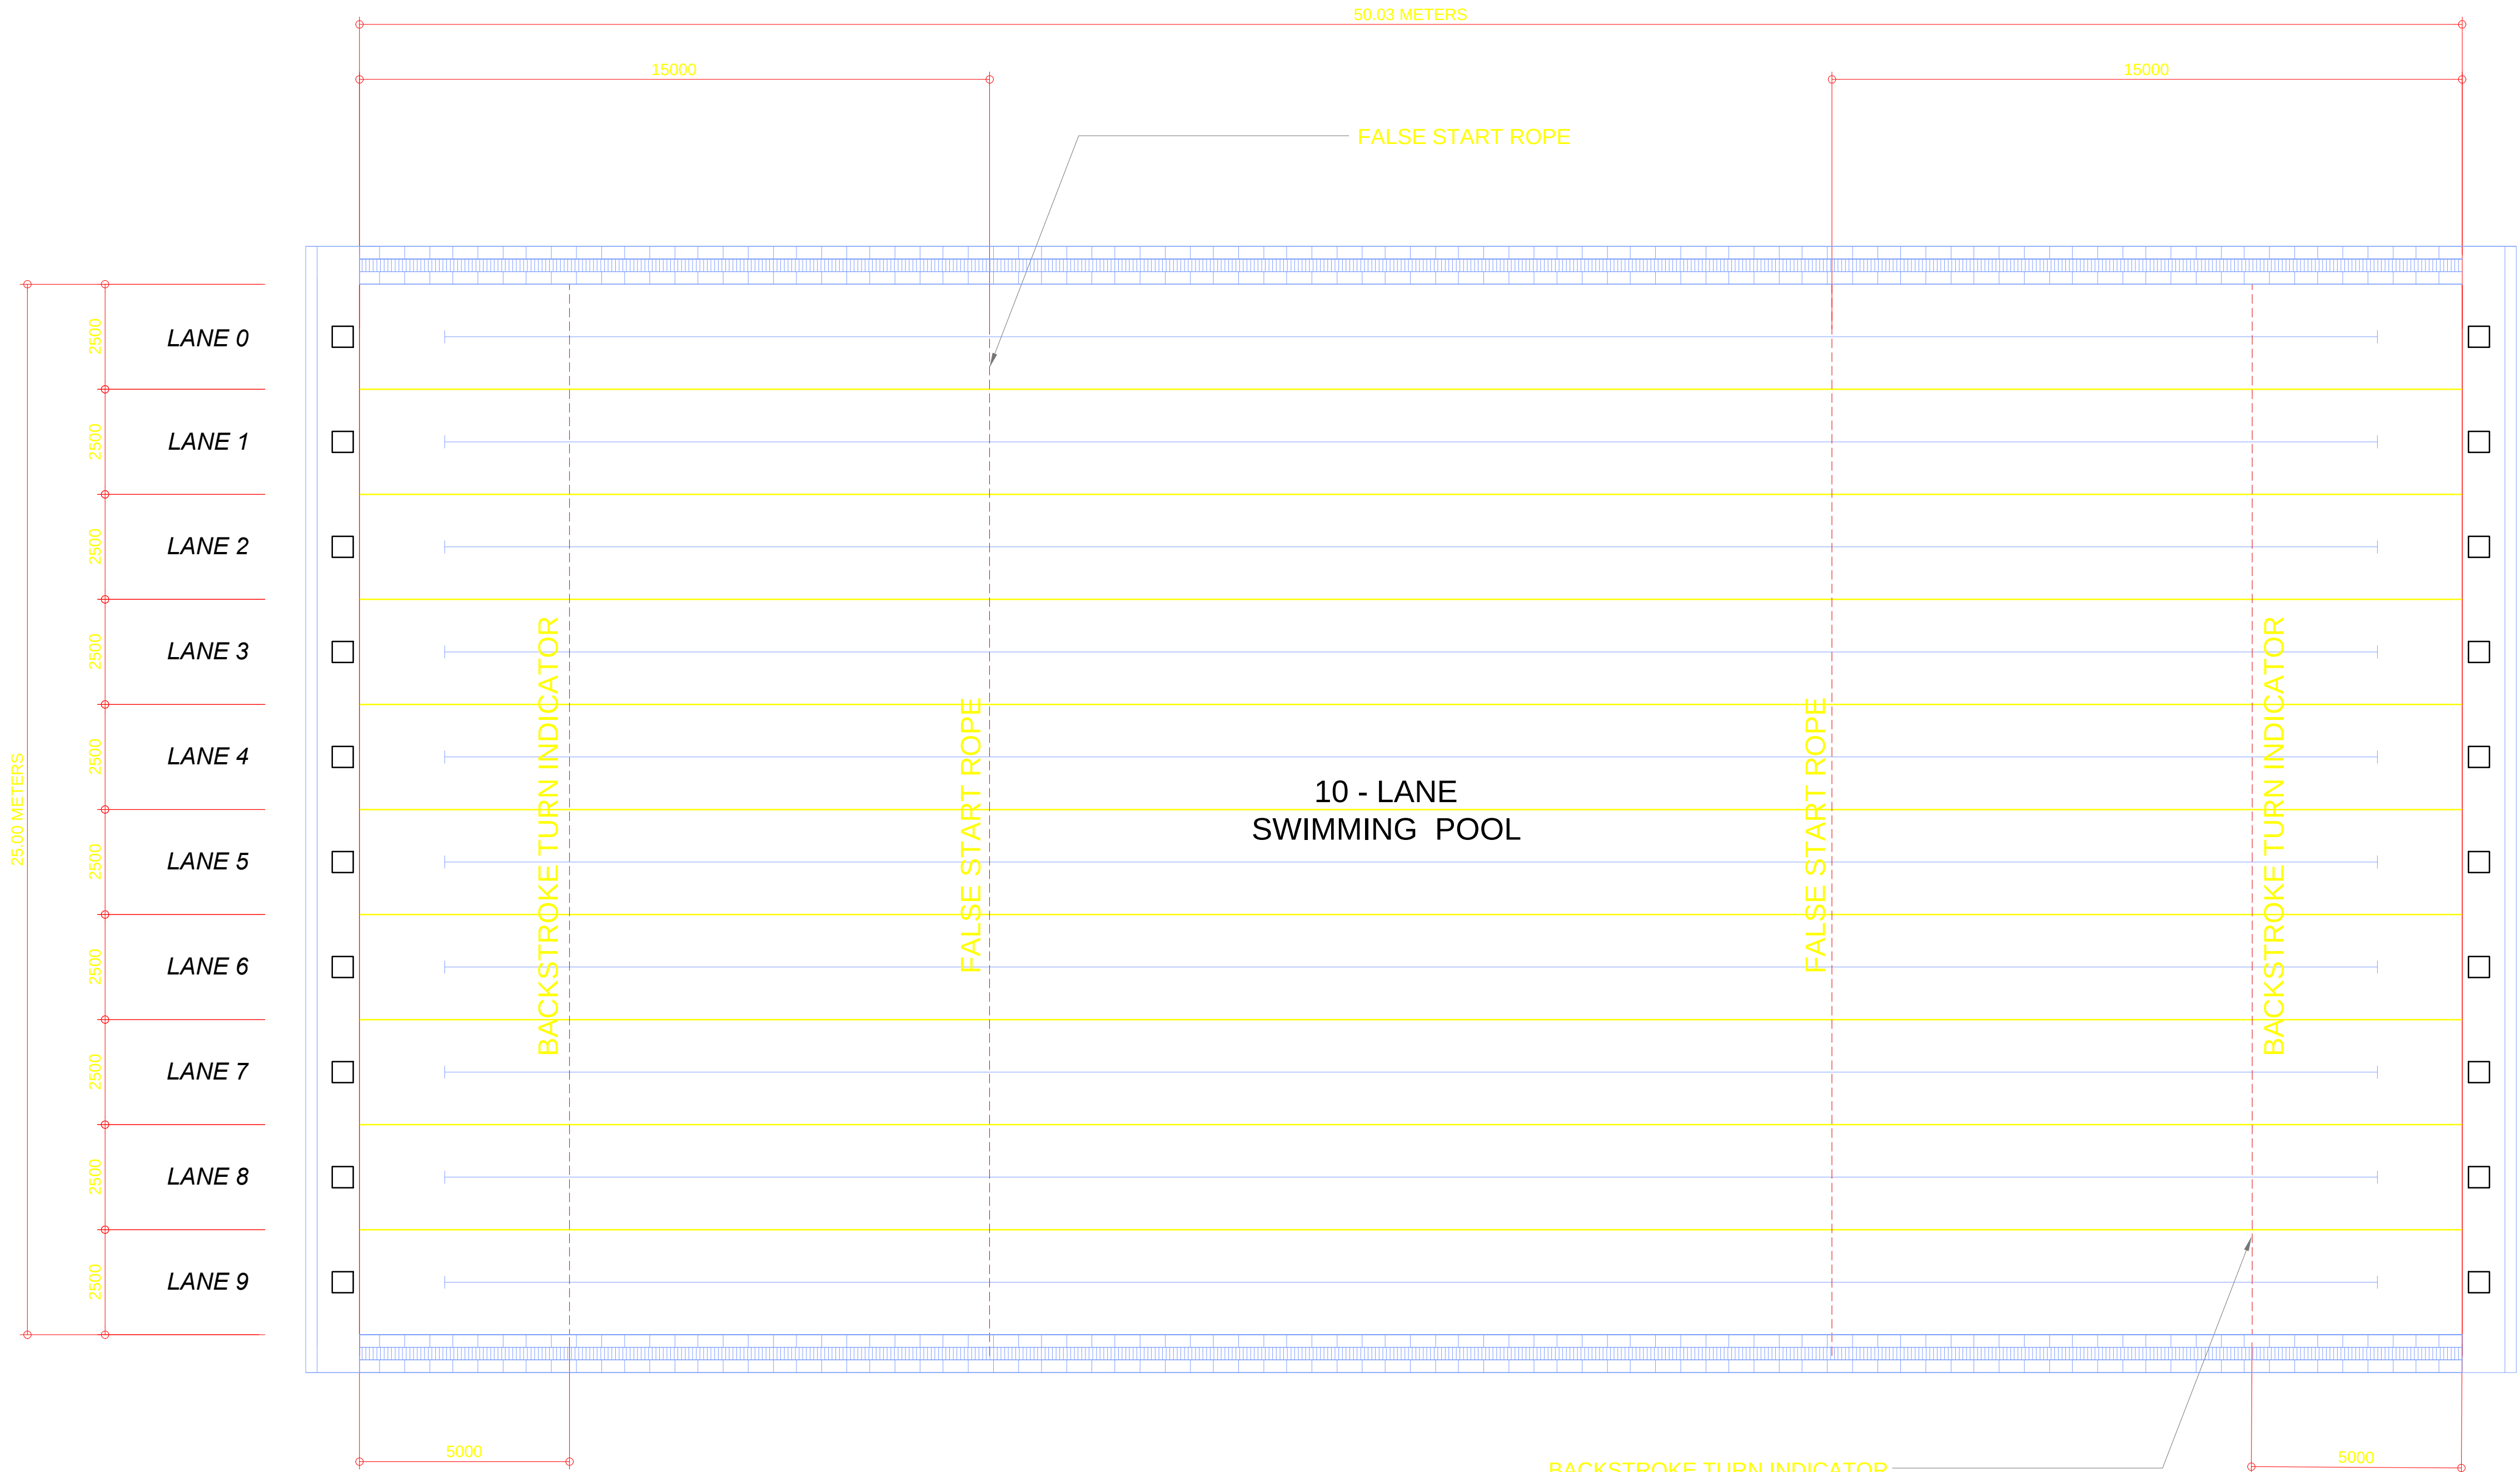


OWNER	PROJECT TITLE :	SUBMITTED BY :	RECOMMENDING APPROVAL :	APPROVED BY :	SHEET CONTENTS :	DESIGN BY :		SHEET NO :
 PHILIPPINE SPORTS COMMISSION RMSC, PABLO OCAMPO SR. ST., MALATE, MANILA	UPGRADING OF SWIMMING POOL, DIVING POOL, WARM UP POOL AND CONSTRUCTION OF NEW BLEACHERS,AND JACUZZI LOCATION: RMSC, PABLO OCAMPO SR. ST., MALATE, MANILA	ENGR. PEDRO I. PINEDA JR. HEAD - ENGINEERING UNIT	DIR. MERLITA R. IBAY DEPUTY EXECUTIVE DIRECTOR	HON. WILLIAM I. RAMIREZ CHAIRMAN	AS SHOWN	DRAWN BY :		A 17
						CHECKED BY :		
						DATE :		
						APPROVED BY :		

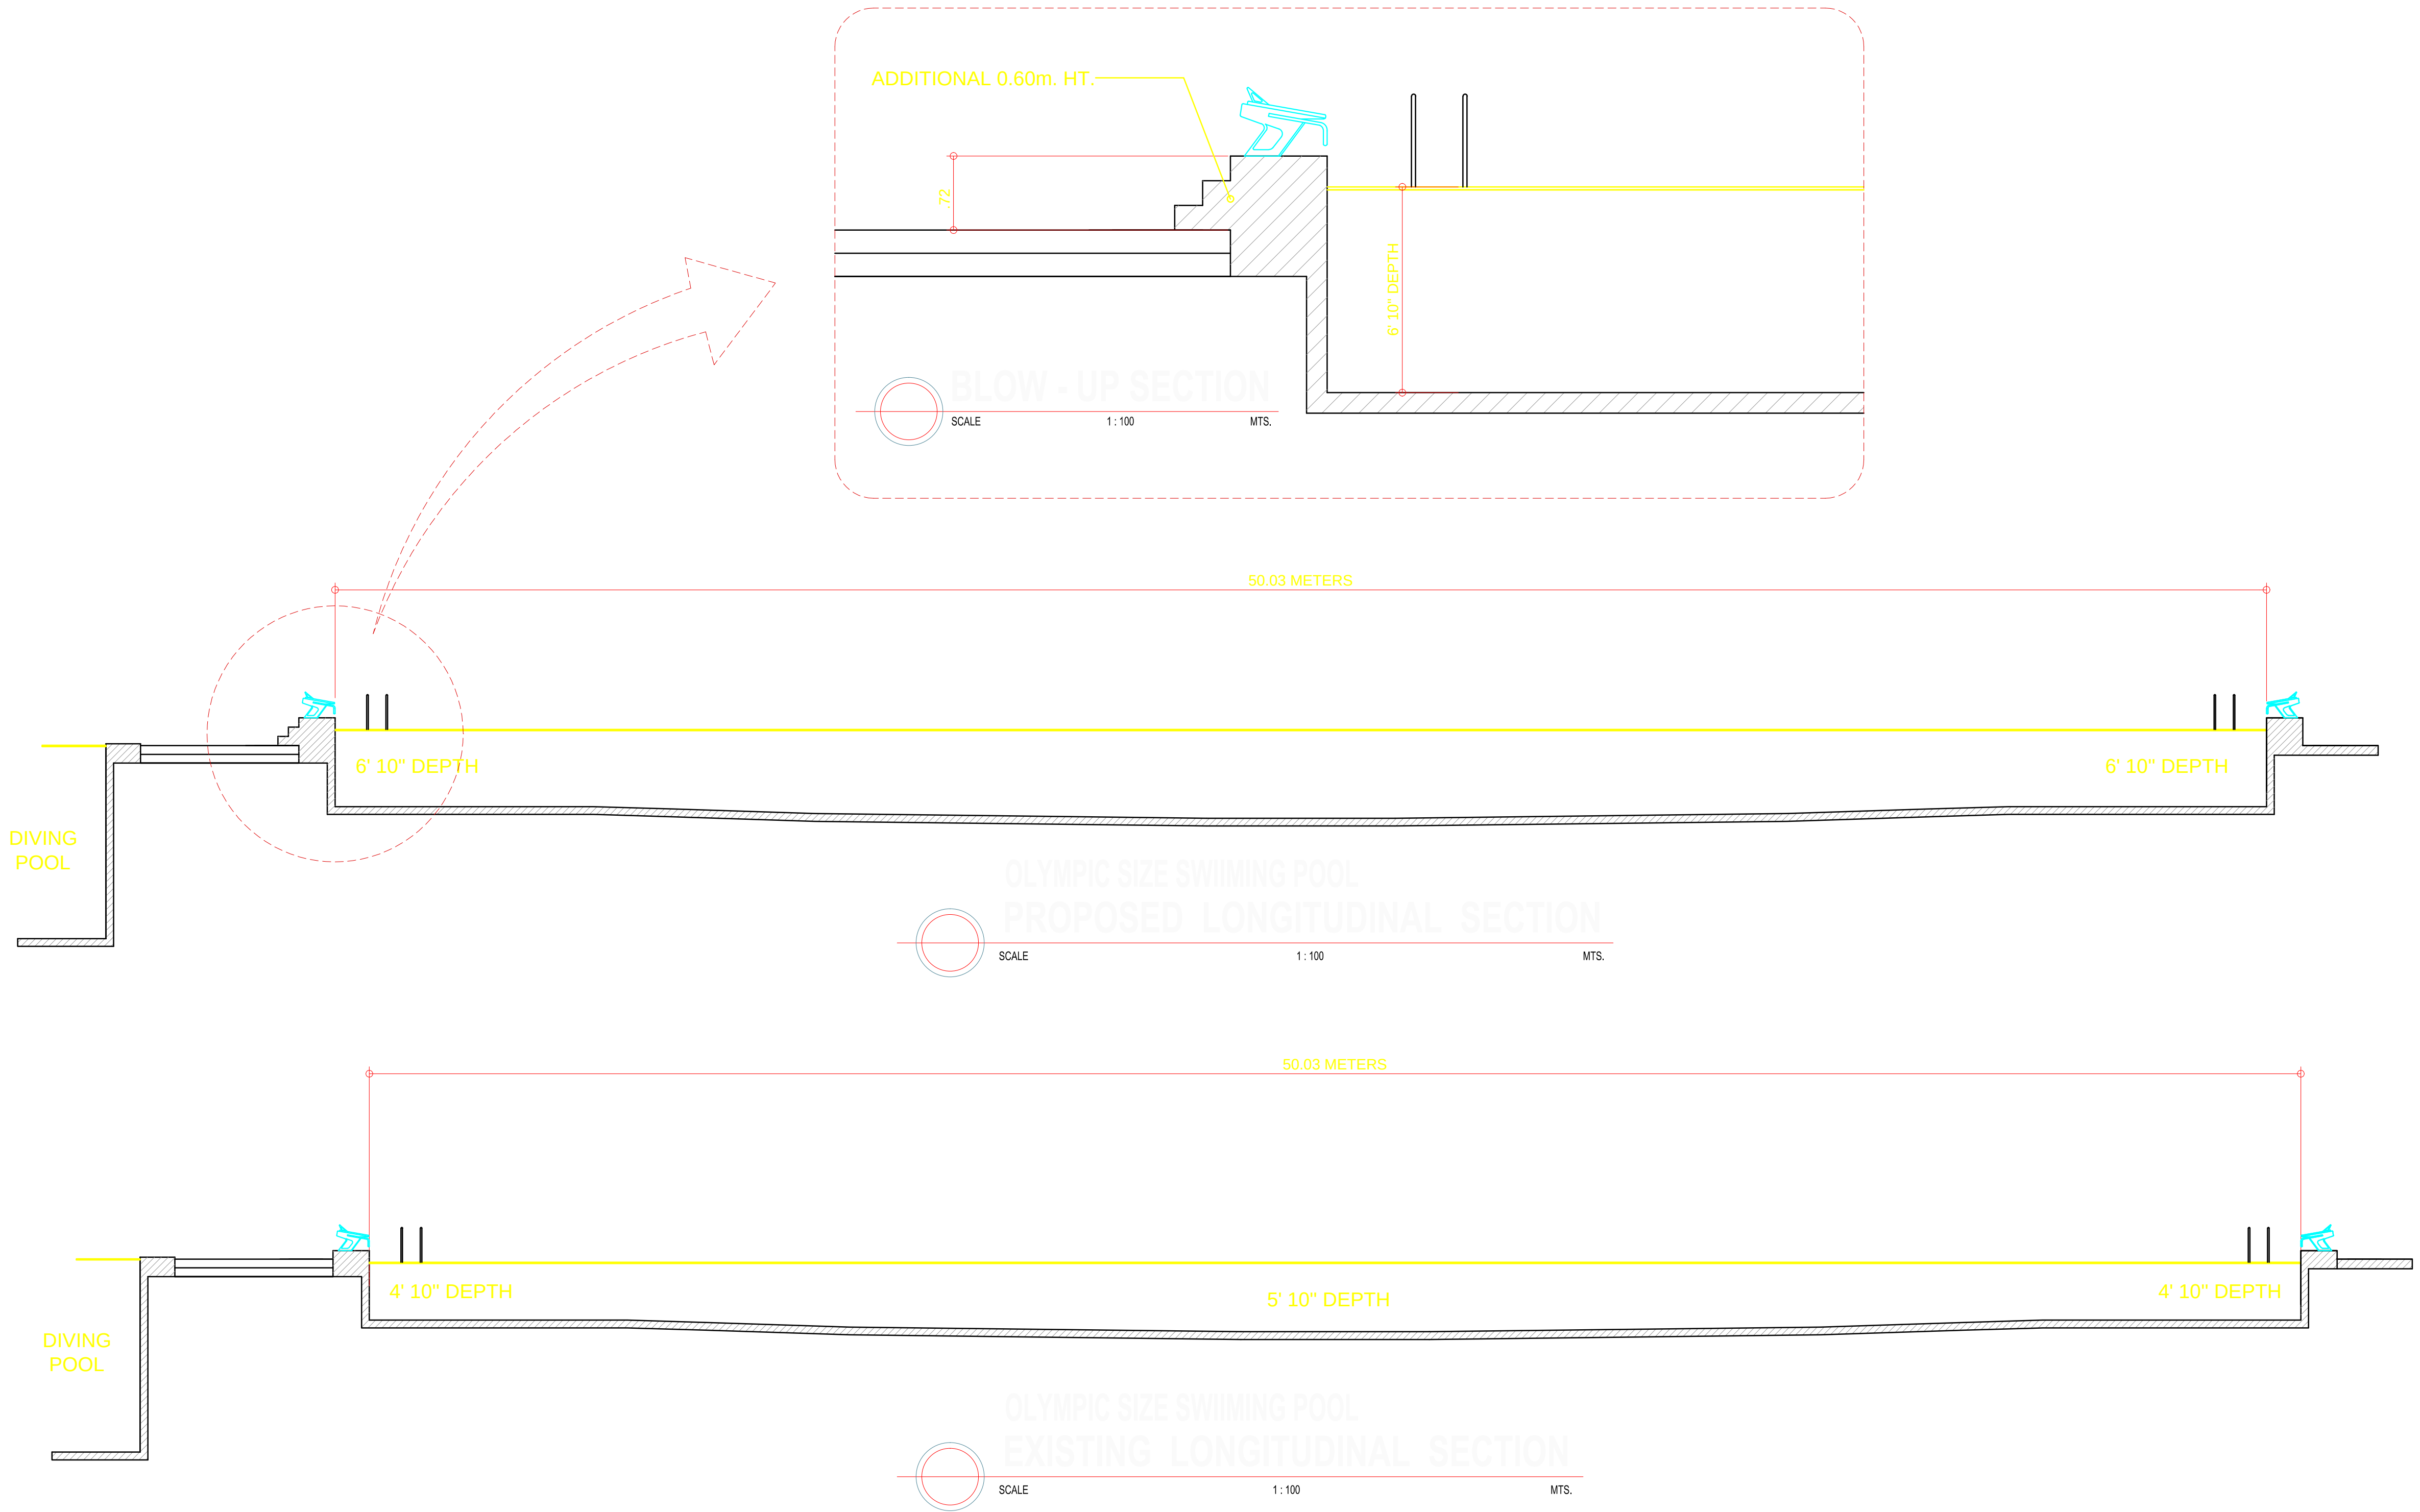

OWNER	PROJECT TITLE :	SUBMITTED BY :	RECOMMENDING APPROVAL :	APPROVED BY :	SHEET CONTENTS :	DESIGN BY :		SHEET NO :
 PHILIPPINE SPORTS COMMISSION RMSG, PABLO OCAMPO SR. ST., MALATE, MANILA	UPGRADING OF SWIMMING POOL, DIVING POOL, WARM UP POOL AND CONSTRUCTION OF NEW BLEACHERS,AND JACUZZI LOCATION: RMSG, PABLO OCAMPO SR. ST., MALATE, MANILA	ENGR. PEDRO I. PINEDA JR. HEAD - ENGINEERING UNIT	DIR. MERLITA R. IBAY DEPUTY EXECUTIVE DIRECTOR	HON. WILLIAM I. RAMIREZ CHAIRMAN	AS SHOWN	DRAWN BY :		A
						CHECKED BY :		18
						DATE :		
						APPROVED BY :		

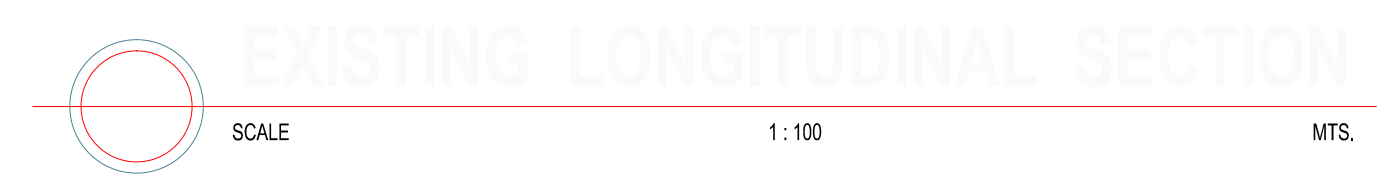


OWNER	PROJECT TITLE :	SUBMITTED BY :	RECOMMENDING APPROVAL :	APPROVED BY :	SHEET CONTENTS :	DESIGN BY :	SHEET NO :
 PHILIPPINE SPORTS COMMISSION RMSC, PABLO OCAMPO SR. ST., MALATE, MANILA	UPGRADING OF SWIMMING POOL, DIVING POOL, WARM UP POOL AND CONSTRUCTION OF NEW BLEACHERS, AND JACUZZI LOCATION: RMSC, PABLO OCAMPO SR. ST., MALATE, MANILA	ENGR. PEDRO I. PINEDA JR. HEAD - ENGINEERING UNIT	DIR. MERLITA R. IBAY DEPUTY EXECUTIVE DIRECTOR	HON. WILLIAM I. RAMIREZ CHAIRMAN	AS SHOWN	DRAWN BY :	A 19
						CHECKED BY :	
						DATE :	
						APPROVED BY :	

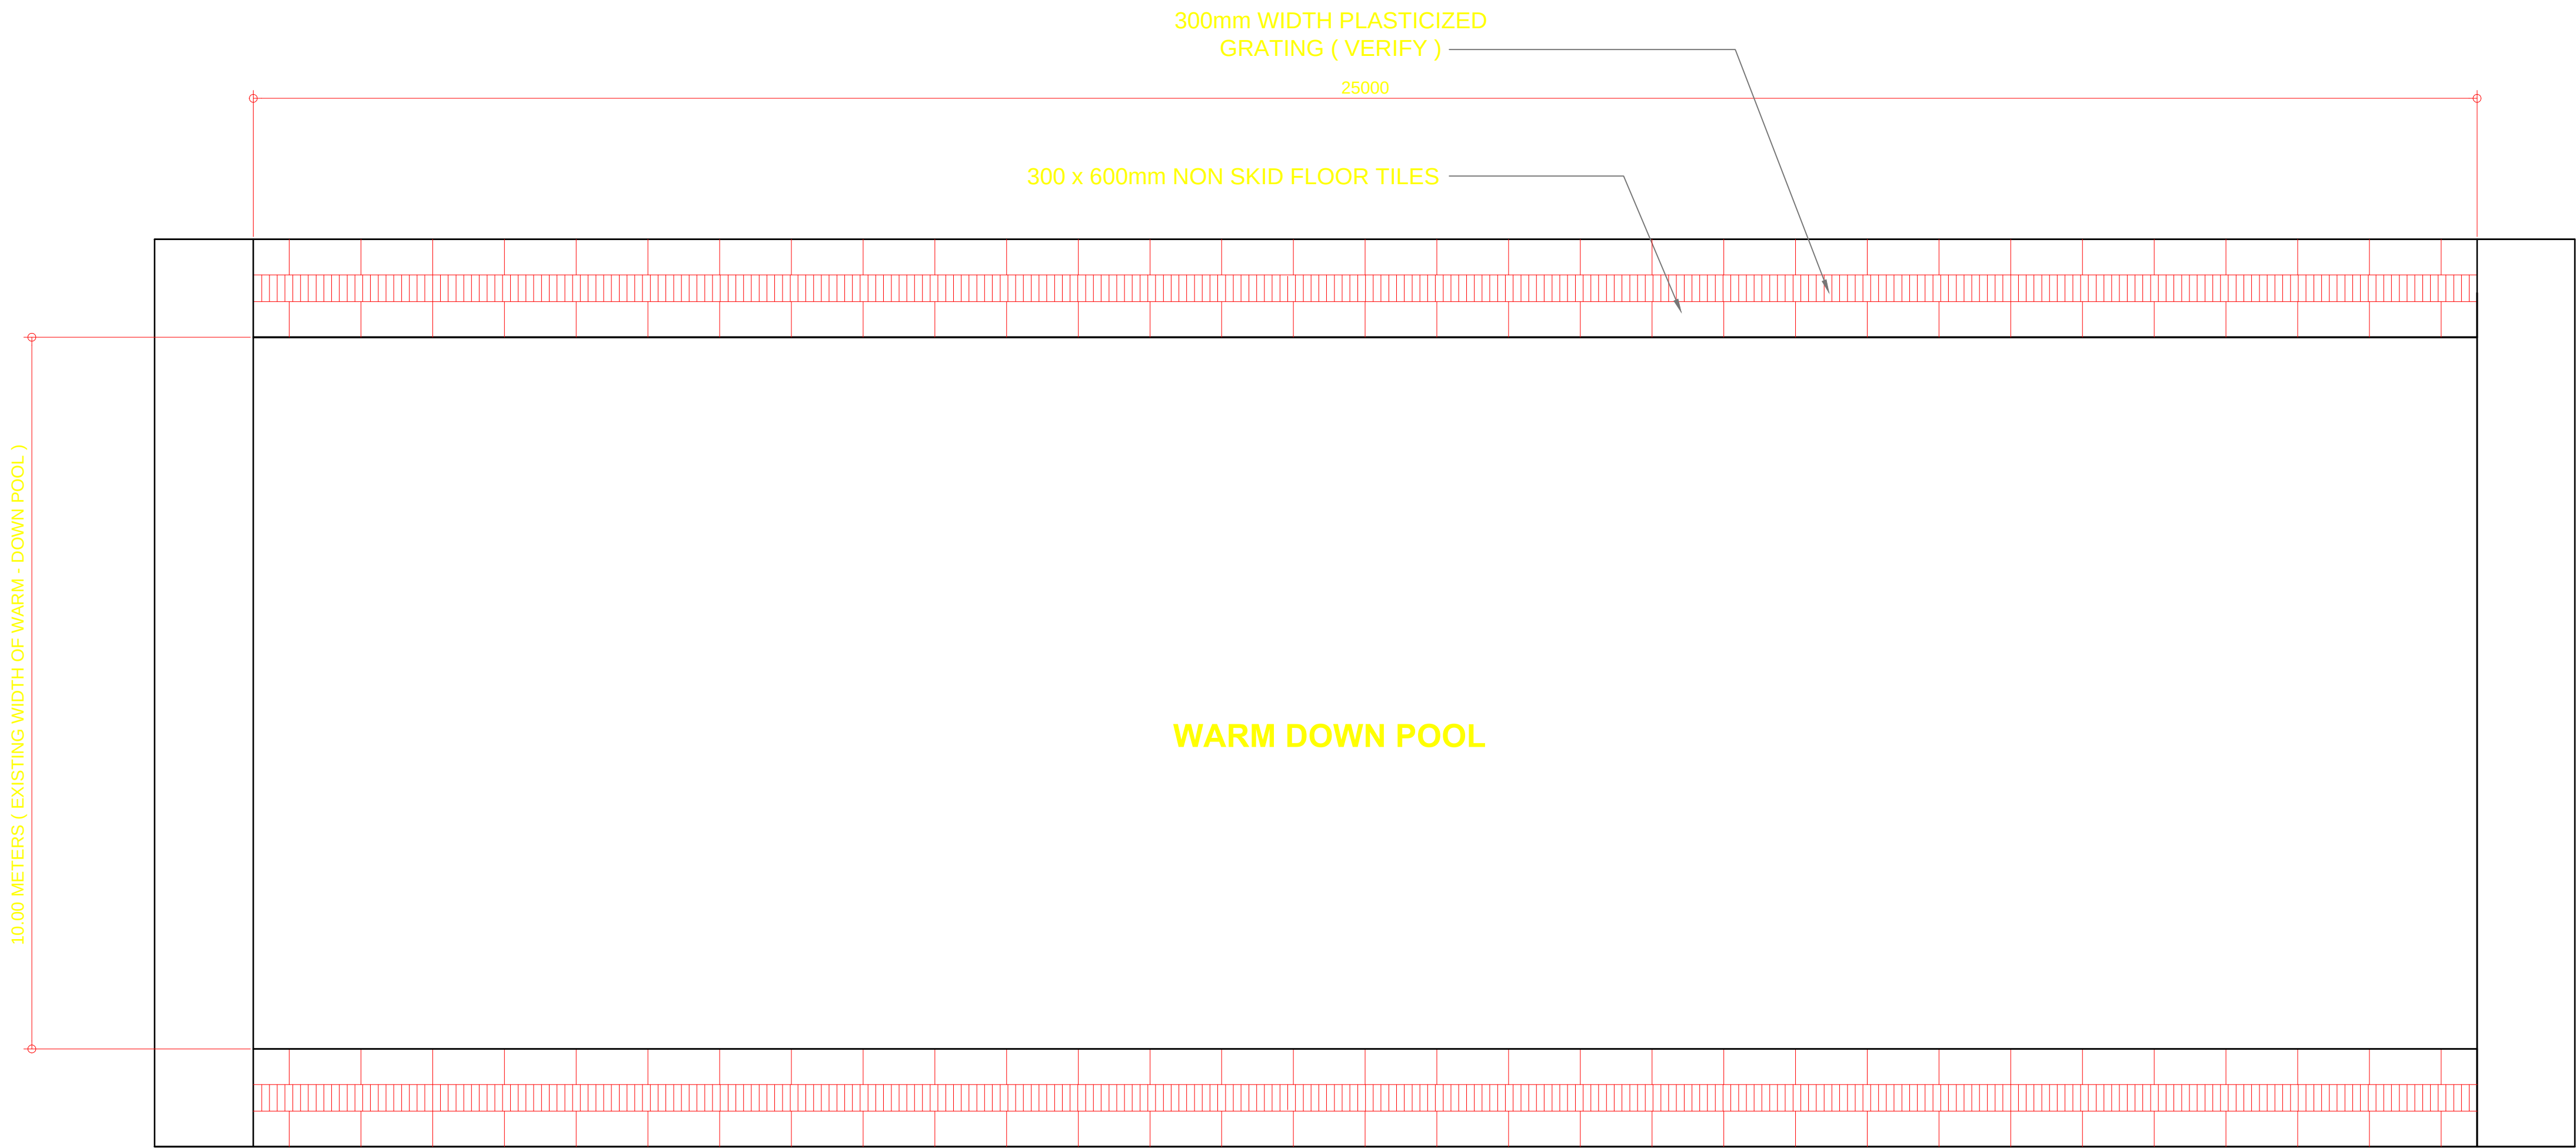

FLOOR PLAN (WARM - DOWN POOL)


SCALE 1 : 50 MTS.

OWNER	PROJECT TITLE :	SUBMITTED BY :	RECOMMENDING APPROVAL :	APPROVED BY :	SHEET CONTENTS :	DESIGN BY :		SHEET NO :
 PHILIPPINE SPORTS COMMISSION RMSG, PABLO OCAMPO SR. ST., MALATE, MANILA UPGRADING OF SWIMMING POOL, DIVING POOL, WARM UP POOL AND CONSTRUCTION OF NEW BLEACHERS,AND JACUZZI LOCATION: RMSG, PABLO OCAMPO SR. ST., MALATE, MANILA		ENGR. PEDRO I. PINEDA JR. HEAD - ENGINEERING UNIT	DIR. MERLITA R. IBAY DEPUTY EXECUTIVE DIRECTOR	HON. WILLIAM I. RAMIREZ CHAIRMAN	AS SHOWN	DRAWN BY :		A 20
						CHECKED BY :		
						DATE :		
						APPROVED BY :		

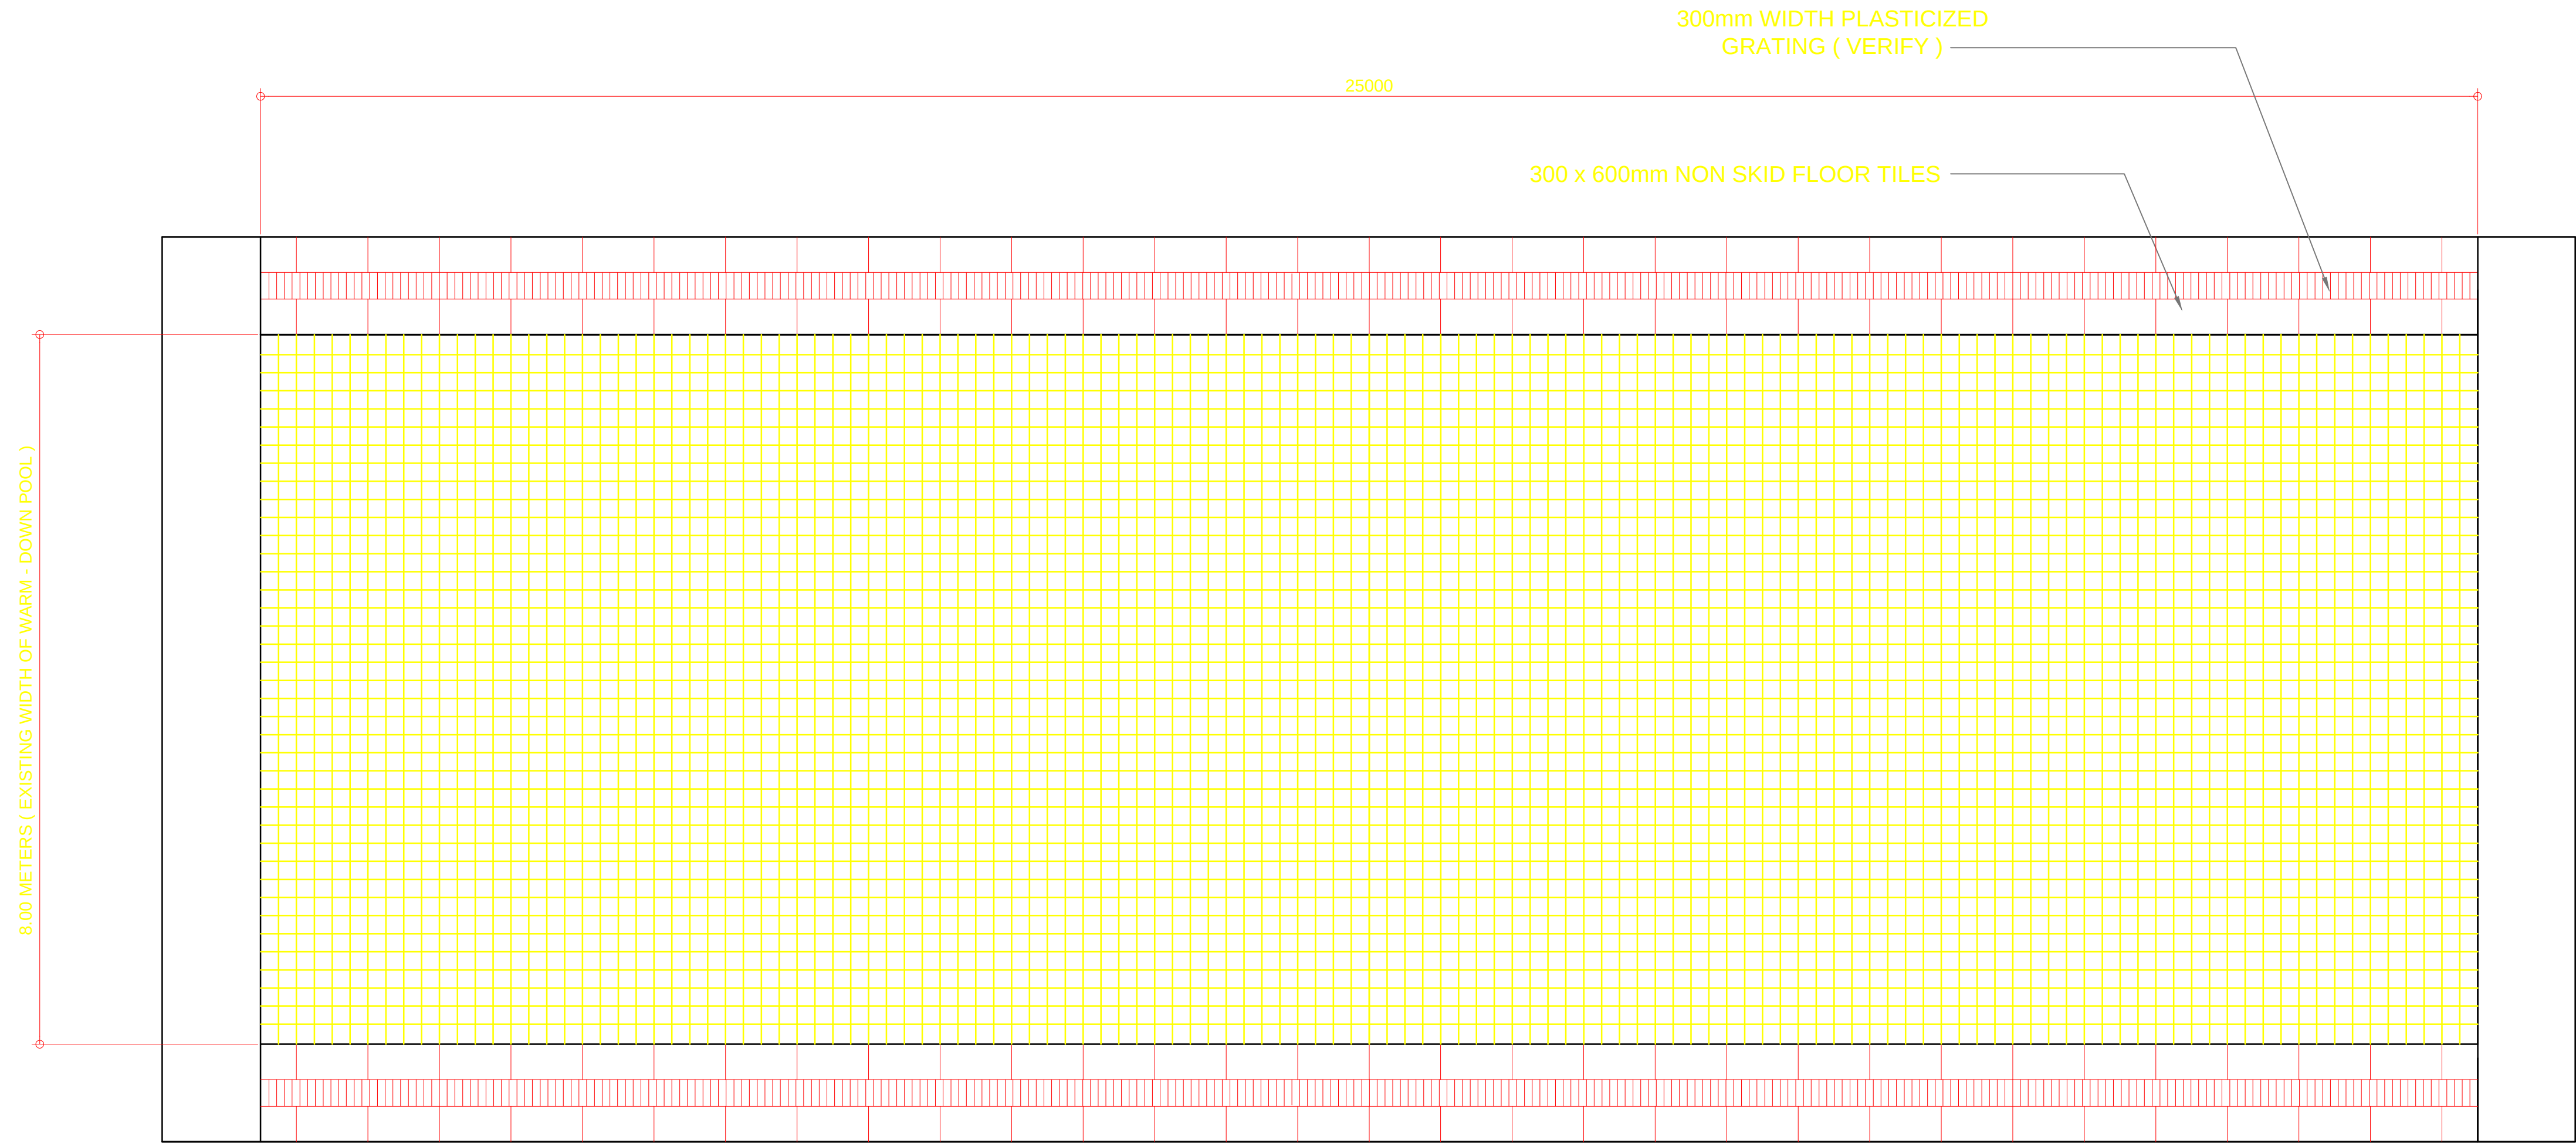


FLOOR TILE LAYOUT

SCALE 1:50 MTS.

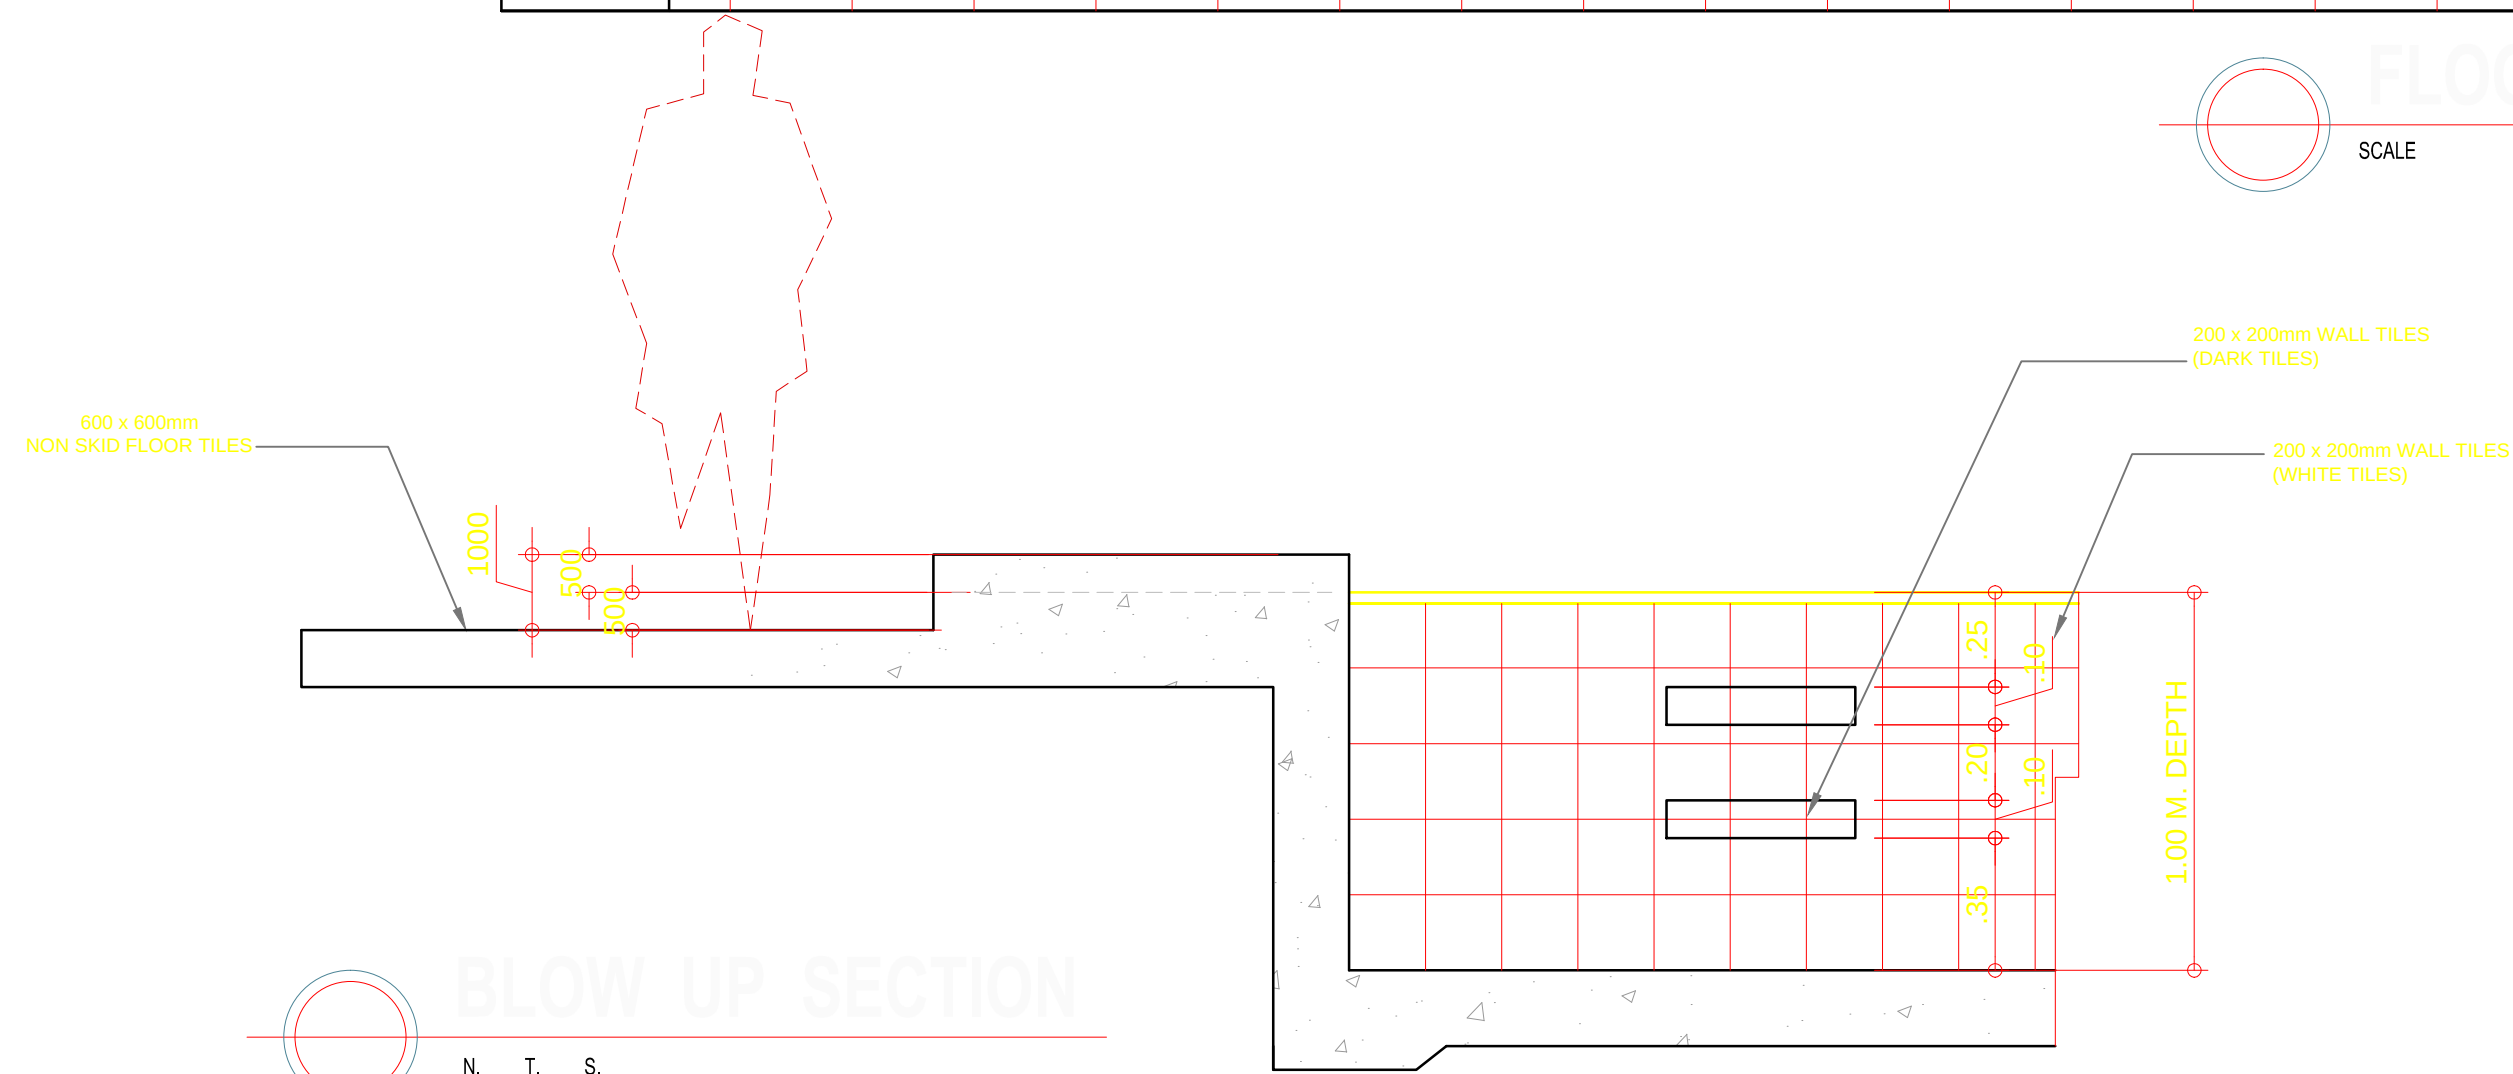

BLOW UP SECTION






N. T. S.

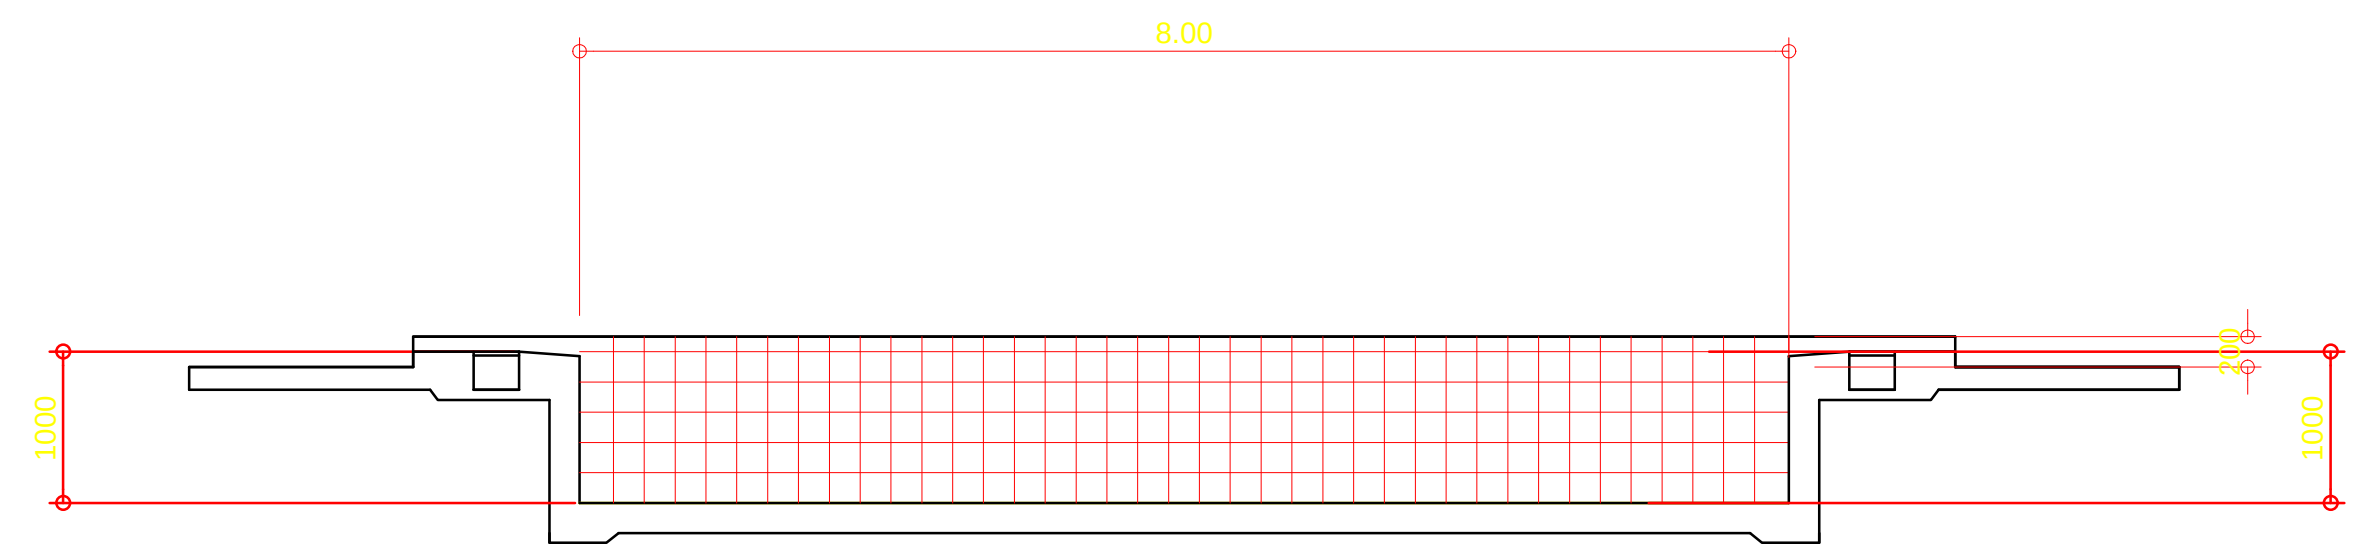


CROSS SECTION


N. T. S.


OWNER	PROJECT TITLE :	SUBMITTED BY :	RECOMMENDING APPROVAL :	APPROVED BY :	SHEET CONTENTS :	DESIGN BY :		SHEET NO :
 PHILIPPINE SPORTS COMMISSION RMSG, PABLO OCAMPO SR. ST., MALATE, MANILA	UPGRADING OF SWIMMING POOL, DIVING POOL, WARM UP POOL AND CONSTRUCTION OF NEW BLEACHERS,AND JACUZZI LOCATION: RMSG, PABLO OCAMPO SR. ST., MALATE, MANILA	ENGR. PEDRO I. PINEDA JR. HEAD - ENGINEERING UNIT	DIR. MERLITA R. IBAY DEPUTY EXECUTIVE DIRECTOR	HON. WILLIAM I. RAMIREZ CHAIRMAN	AS SHOWN	DRAWN BY :		A 21
						CHECKED BY :		
						DATE :		
						APPROVED BY :		

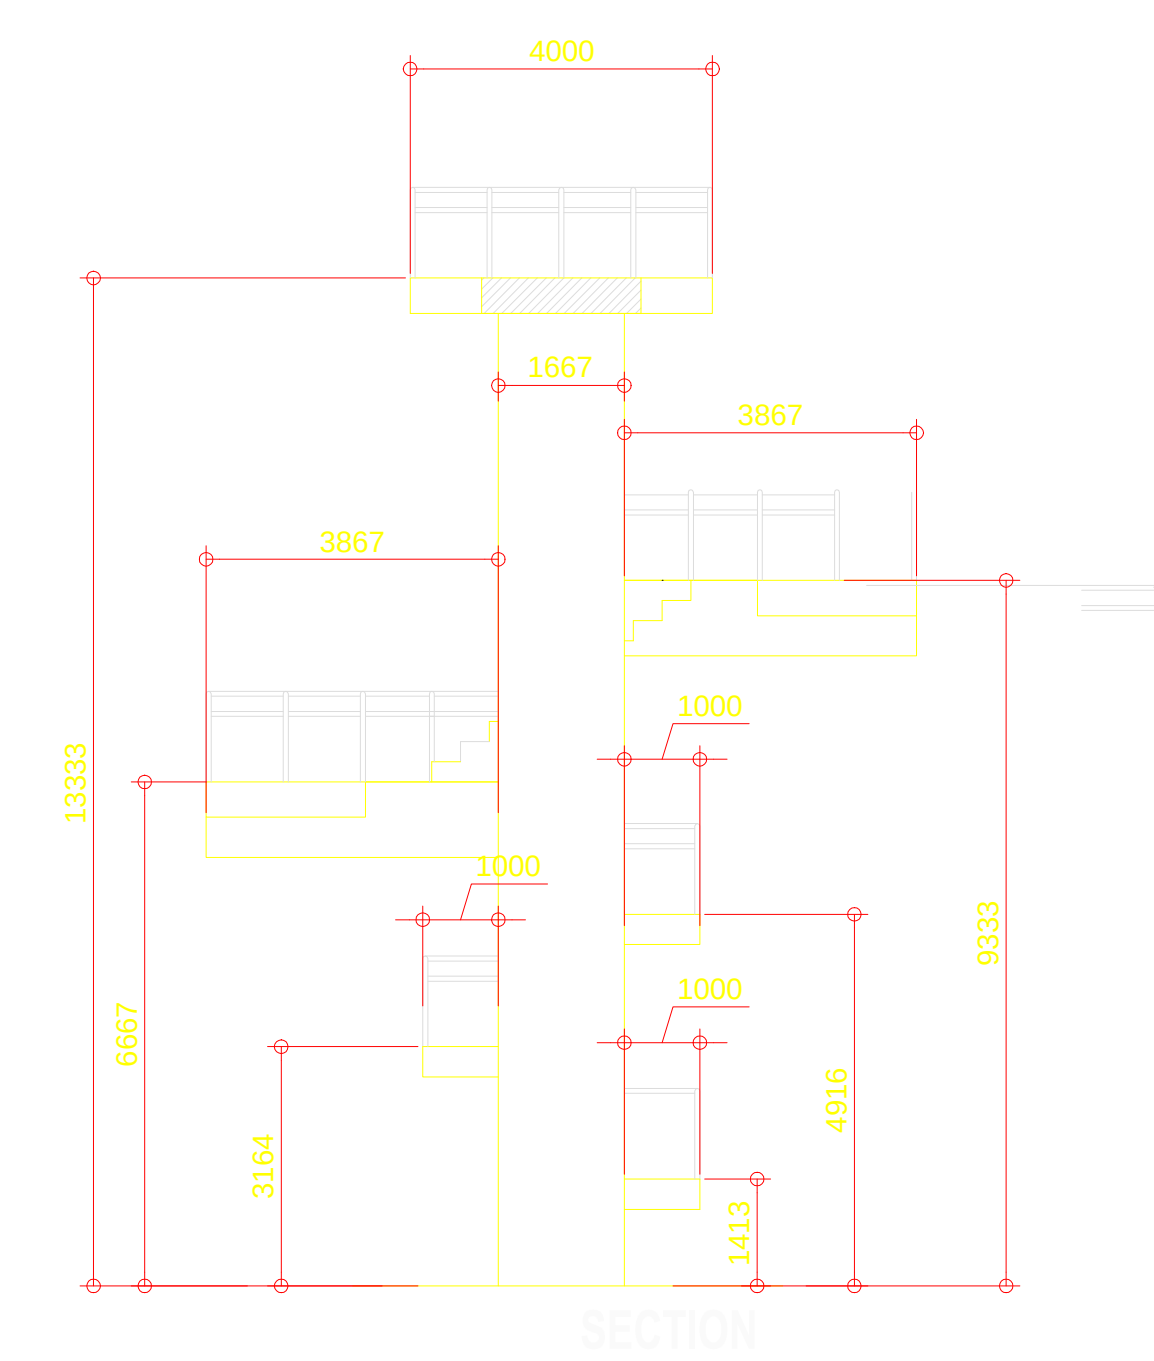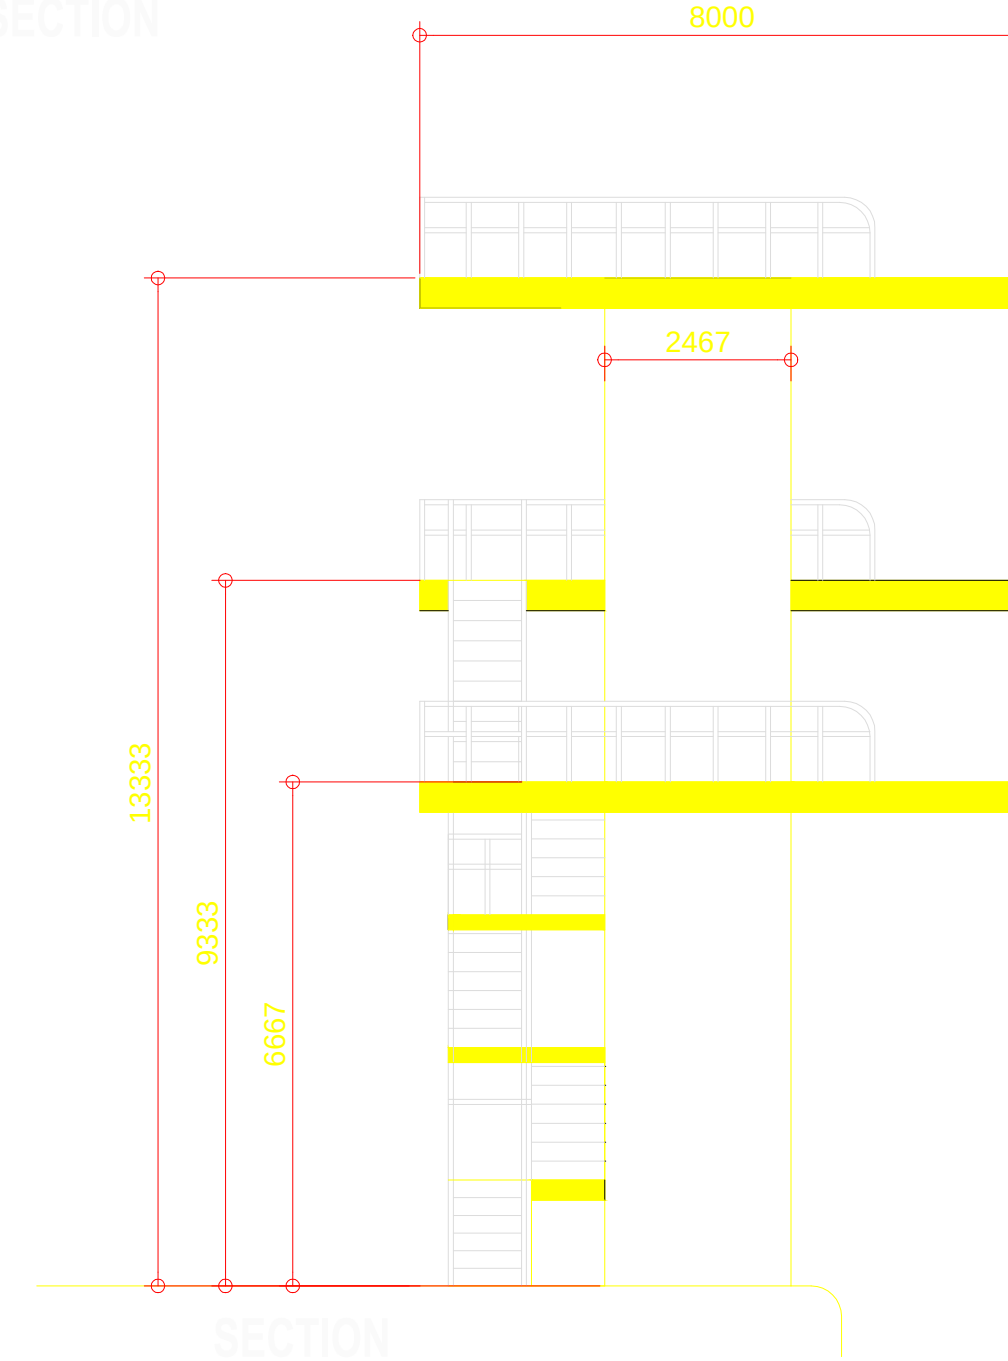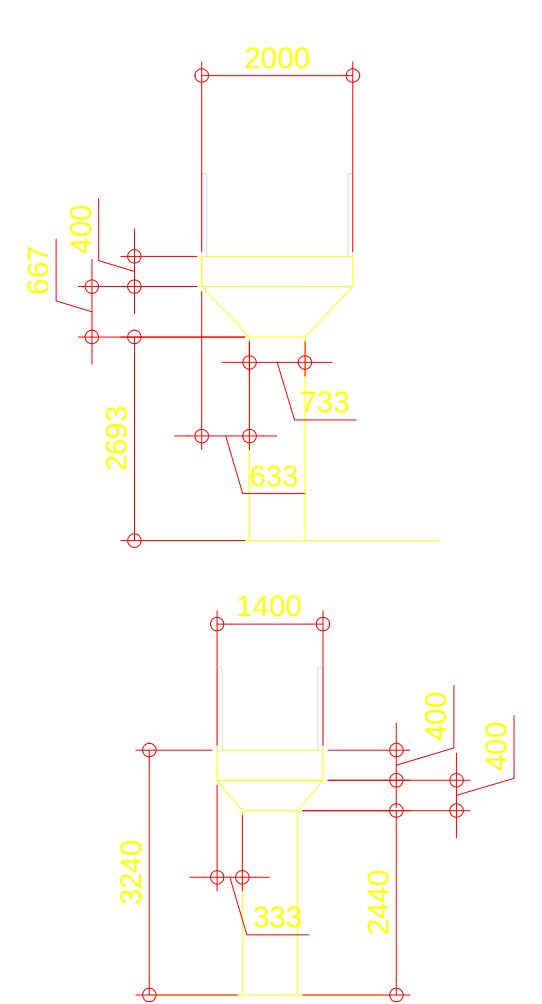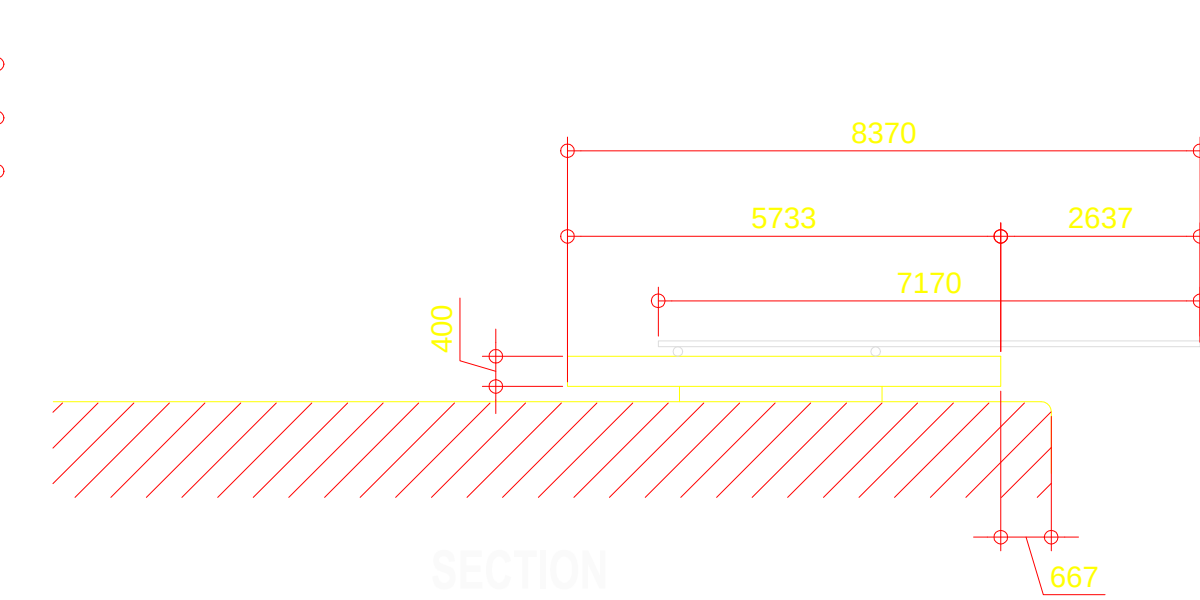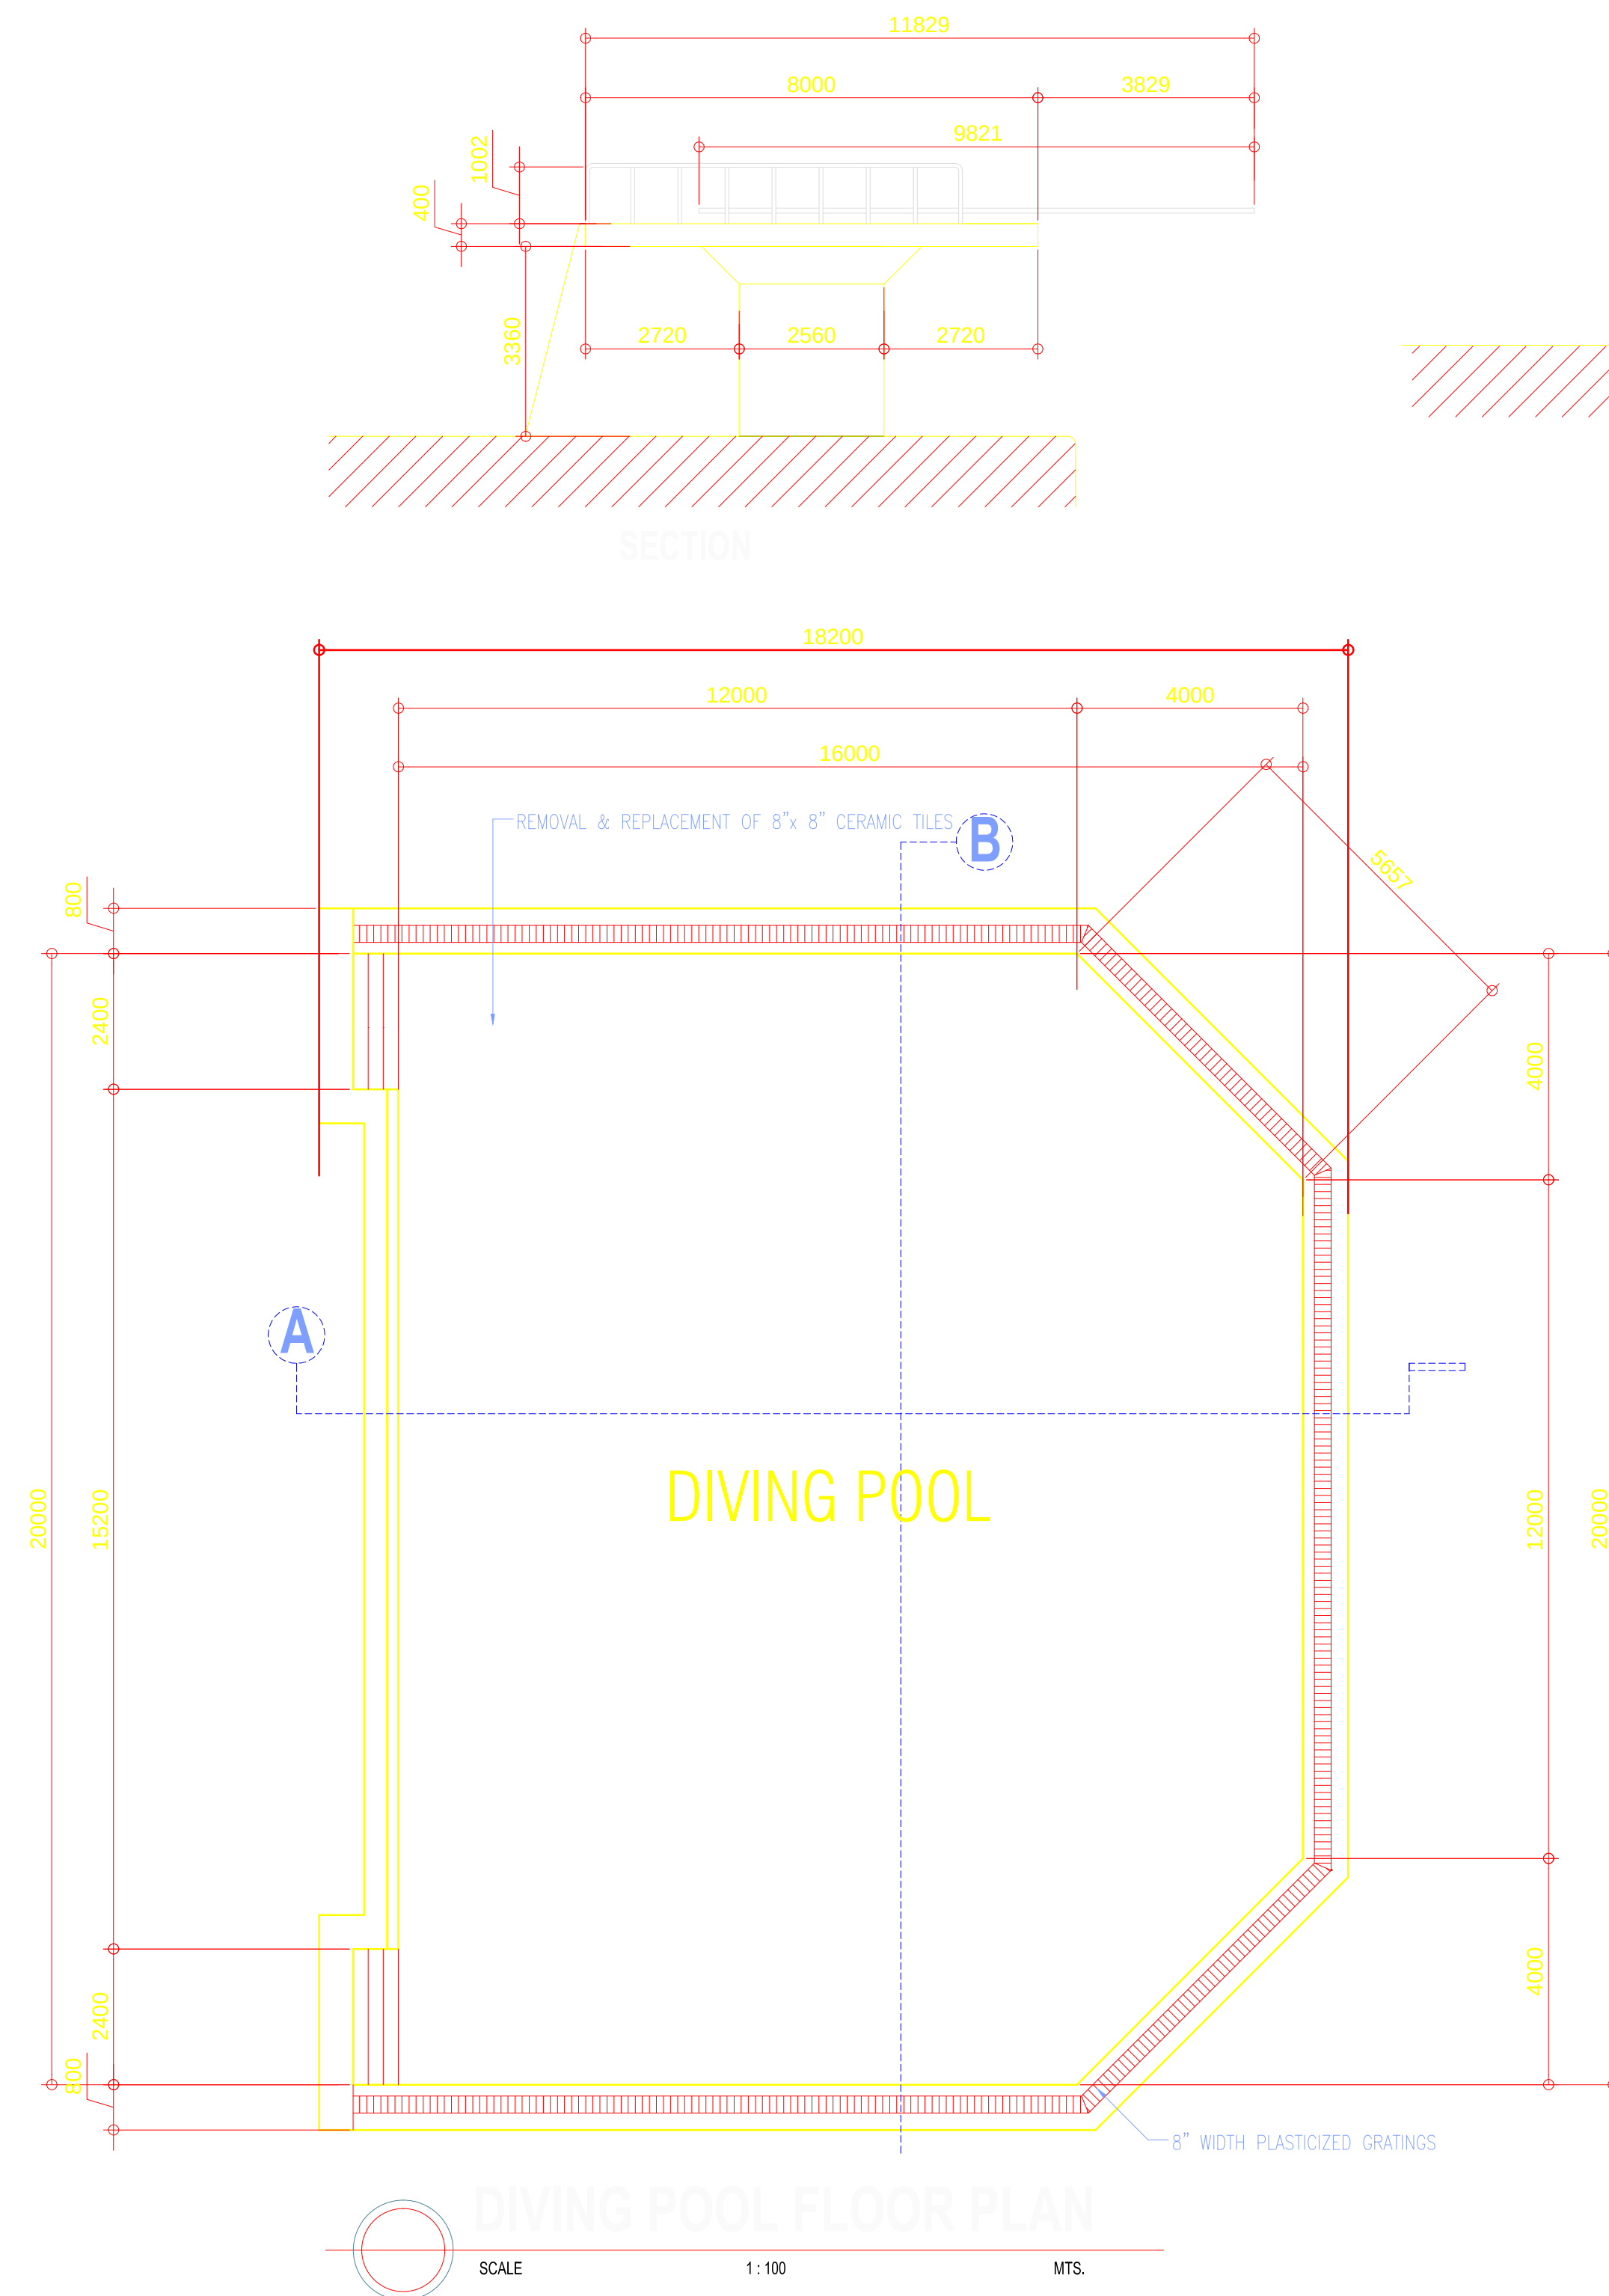


OWNER	PROJECT TITLE :	SUBMITTED BY :	RECOMMENDING APPROVAL :	APPROVED BY :	SHEET CONTENTS :	DESIGN BY :		SHEET NO :
 PHILIPPINE SPORTS COMMISSION RMSC, PABLO OCAMPO SR. ST., MALATE, MANILA	UPGRADING OF SWIMMING POOL, DIVING POOL, WARM UP POOL AND CONSTRUCTION OF NEW BLEACHERS, AND JACUZZI LOCATION: RMSC, PABLO OCAMPO SR. ST., MALATE, MANILA	ENGR. PEDRO I. PINEDA JR. HEAD - ENGINEERING UNIT	DIR. MERLITA R. IBAY DEPUTY EXECUTIVE DIRECTOR	HON. WILLIAM I. RAMIREZ CHAIRMAN	AS SHOWN	DRAWN BY :		A 22
						CHECKED BY :		
						DATE :		
						APPROVED BY :		

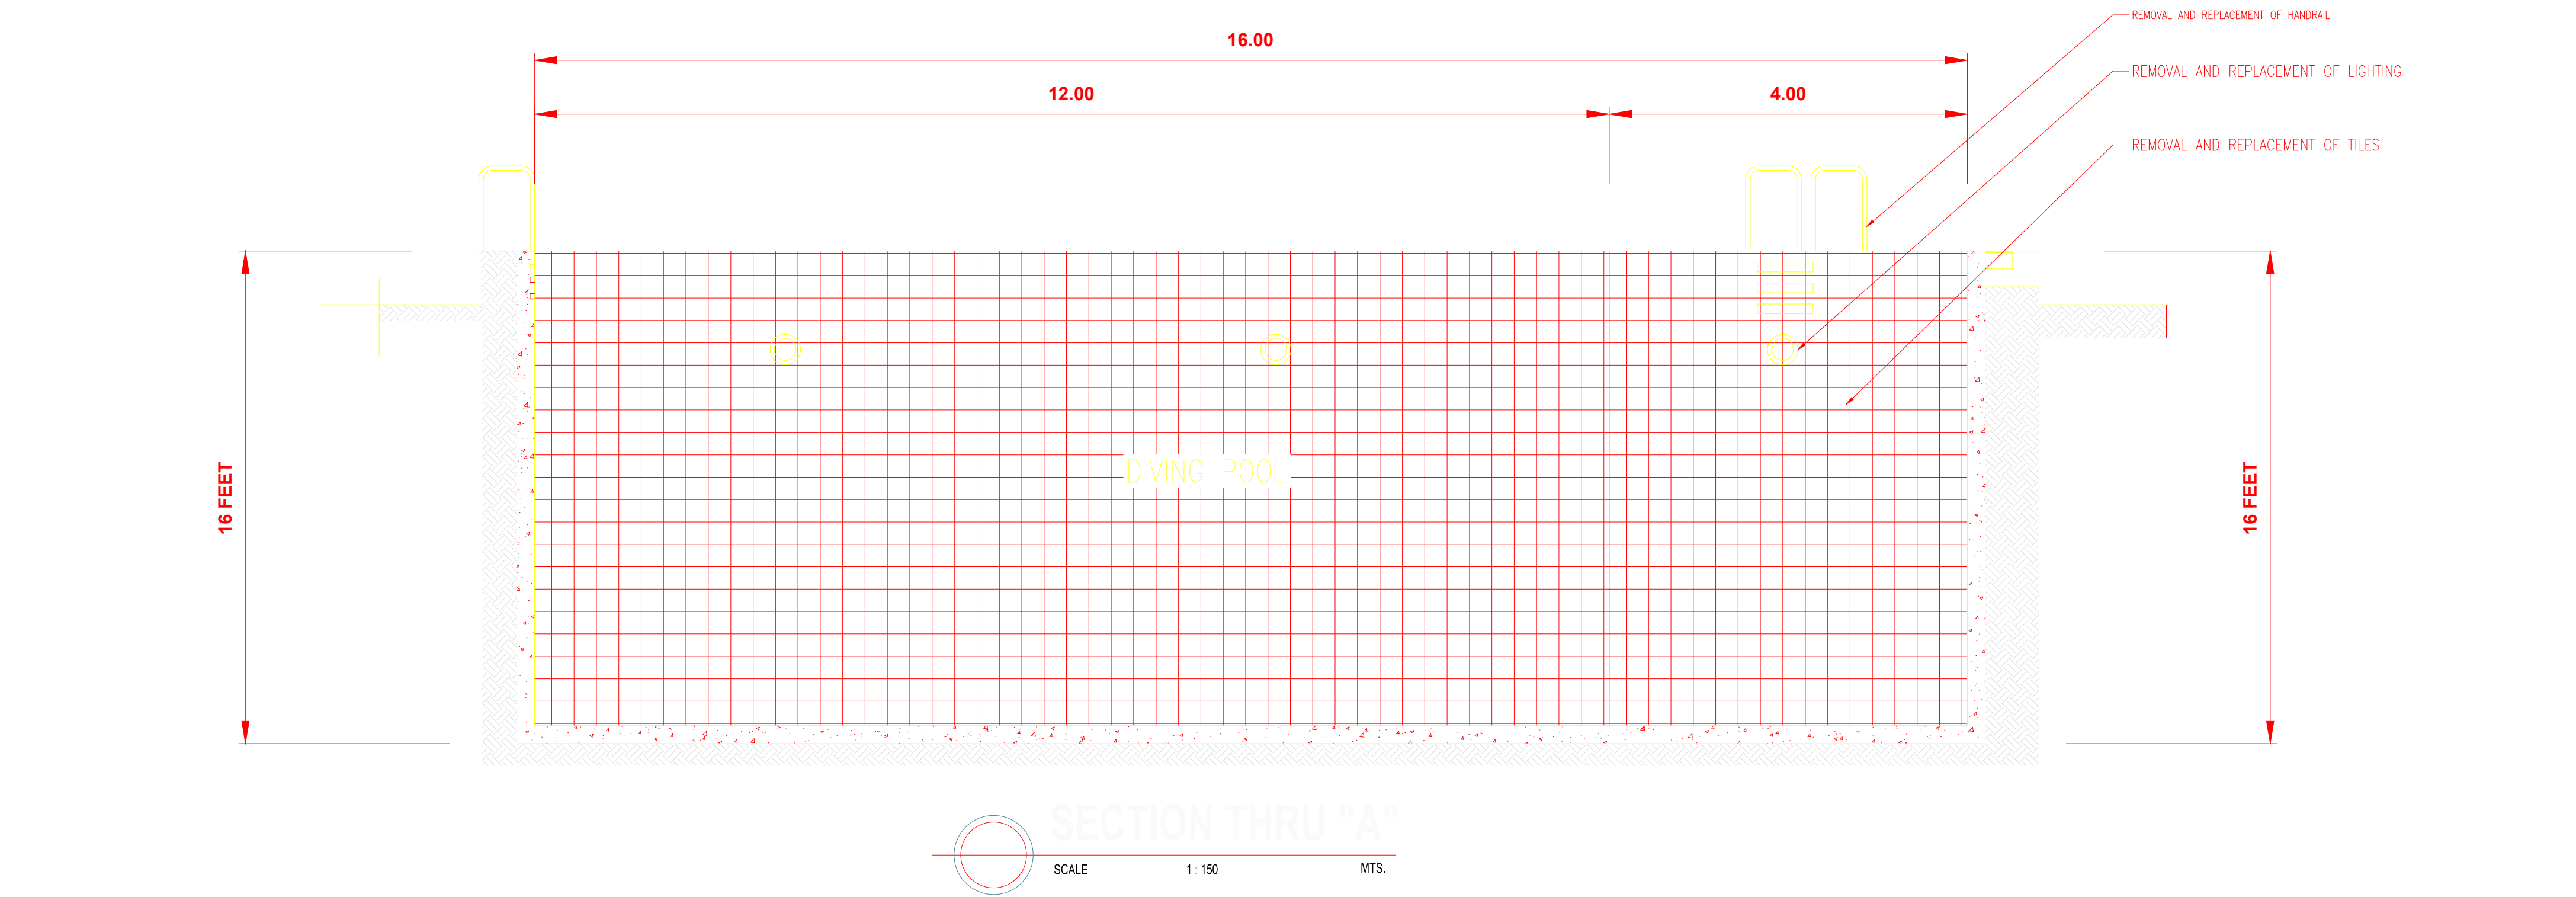

 
OWNER	PROJECT TITLE :	SUBMITTED BY :	RECOMMENDING APPROVAL :	APPROVED BY :	SHEET CONTENTS :	DESIGN BY :		SHEET NO :
 PHILIPPINE SPORTS COMMISSION RMSC, PABLO OCAMPO SR. ST., MALATE, MANILA	UPGRADING OF SWIMMING POOL, DIVING POOL, WARM UP POOL AND CONSTRUCTION OF NEW BLEACHERS,AND JACUZZI LOCATION: RMSC, PABLO OCAMPO SR. ST., MALATE, MANILA	ENGR. PEDRO I. PINEDA JR. HEAD - ENGINEERING UNIT	DIR. MERLITA R. IBAY DEPUTY EXECUTIVE DIRECTOR	HON. WILLIAM I. RAMIREZ CHAIRMAN	AS SHOWN	DRAWN BY :		A 23
						CHECKED BY :		
						DATE :		
						APPROVED BY :		

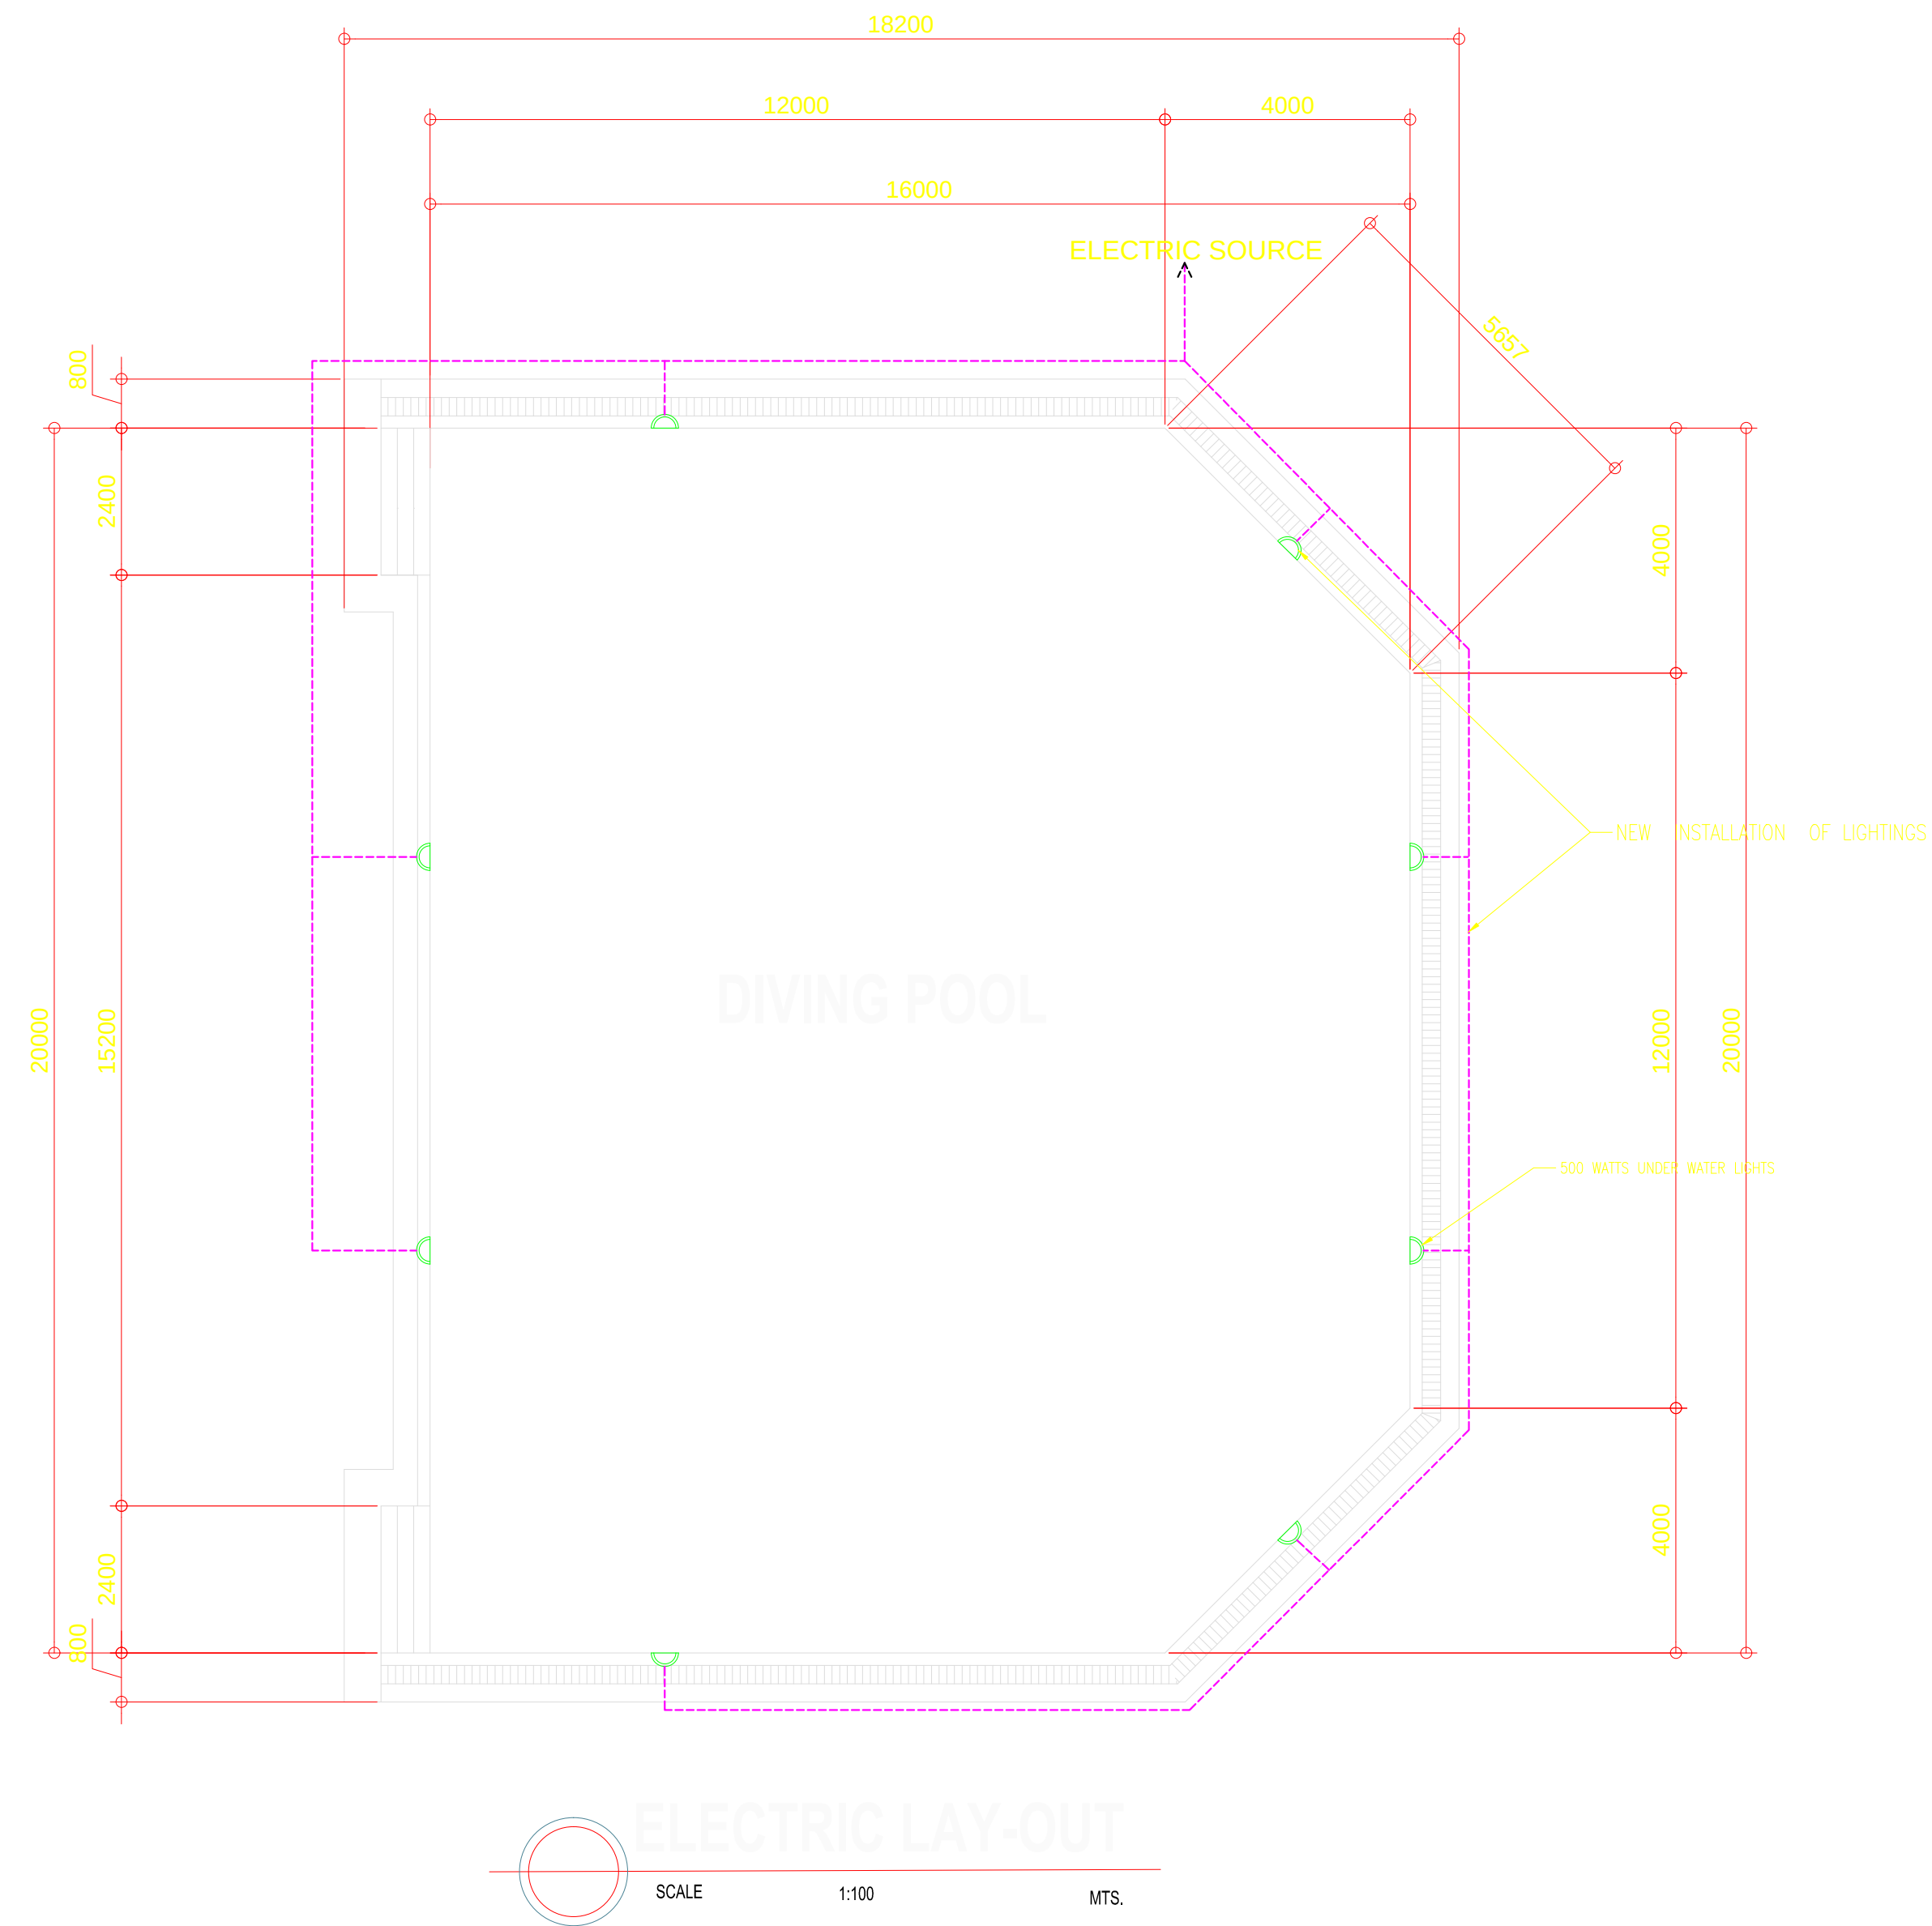

OWNER	PROJECT TITLE :	SUBMITTED BY :	RECOMMENDING APPROVAL :	APPROVED BY :	SHEET CONTENTS :	DESIGN BY :		SHEET NO :
 PHILIPPINE SPORTS COMMISSION RMSG, PABLO OCAMPO SR. ST., MALATE, MANILA	UPGRADING OF SWIMMING POOL, DIVING POOL, WARM UP POOL AND CONSTRUCTION OF NEW BLEACHERS,AND JACUZZI LOCATION: RMSG, PABLO OCAMPO SR. ST., MALATE, MANILA	ENGR. PEDRO I. PINEDA JR. HEAD - ENGINEERING UNIT	DIR. MERLITA R. IBAY DEPUTY EXECUTIVE DIRECTOR	HON. WILLIAM I. RAMIREZ CHAIRMAN	AS SHOWN	DRAWN BY :		E 1
						CHECKED BY :		
						DATE :		
						APPROVED BY :		

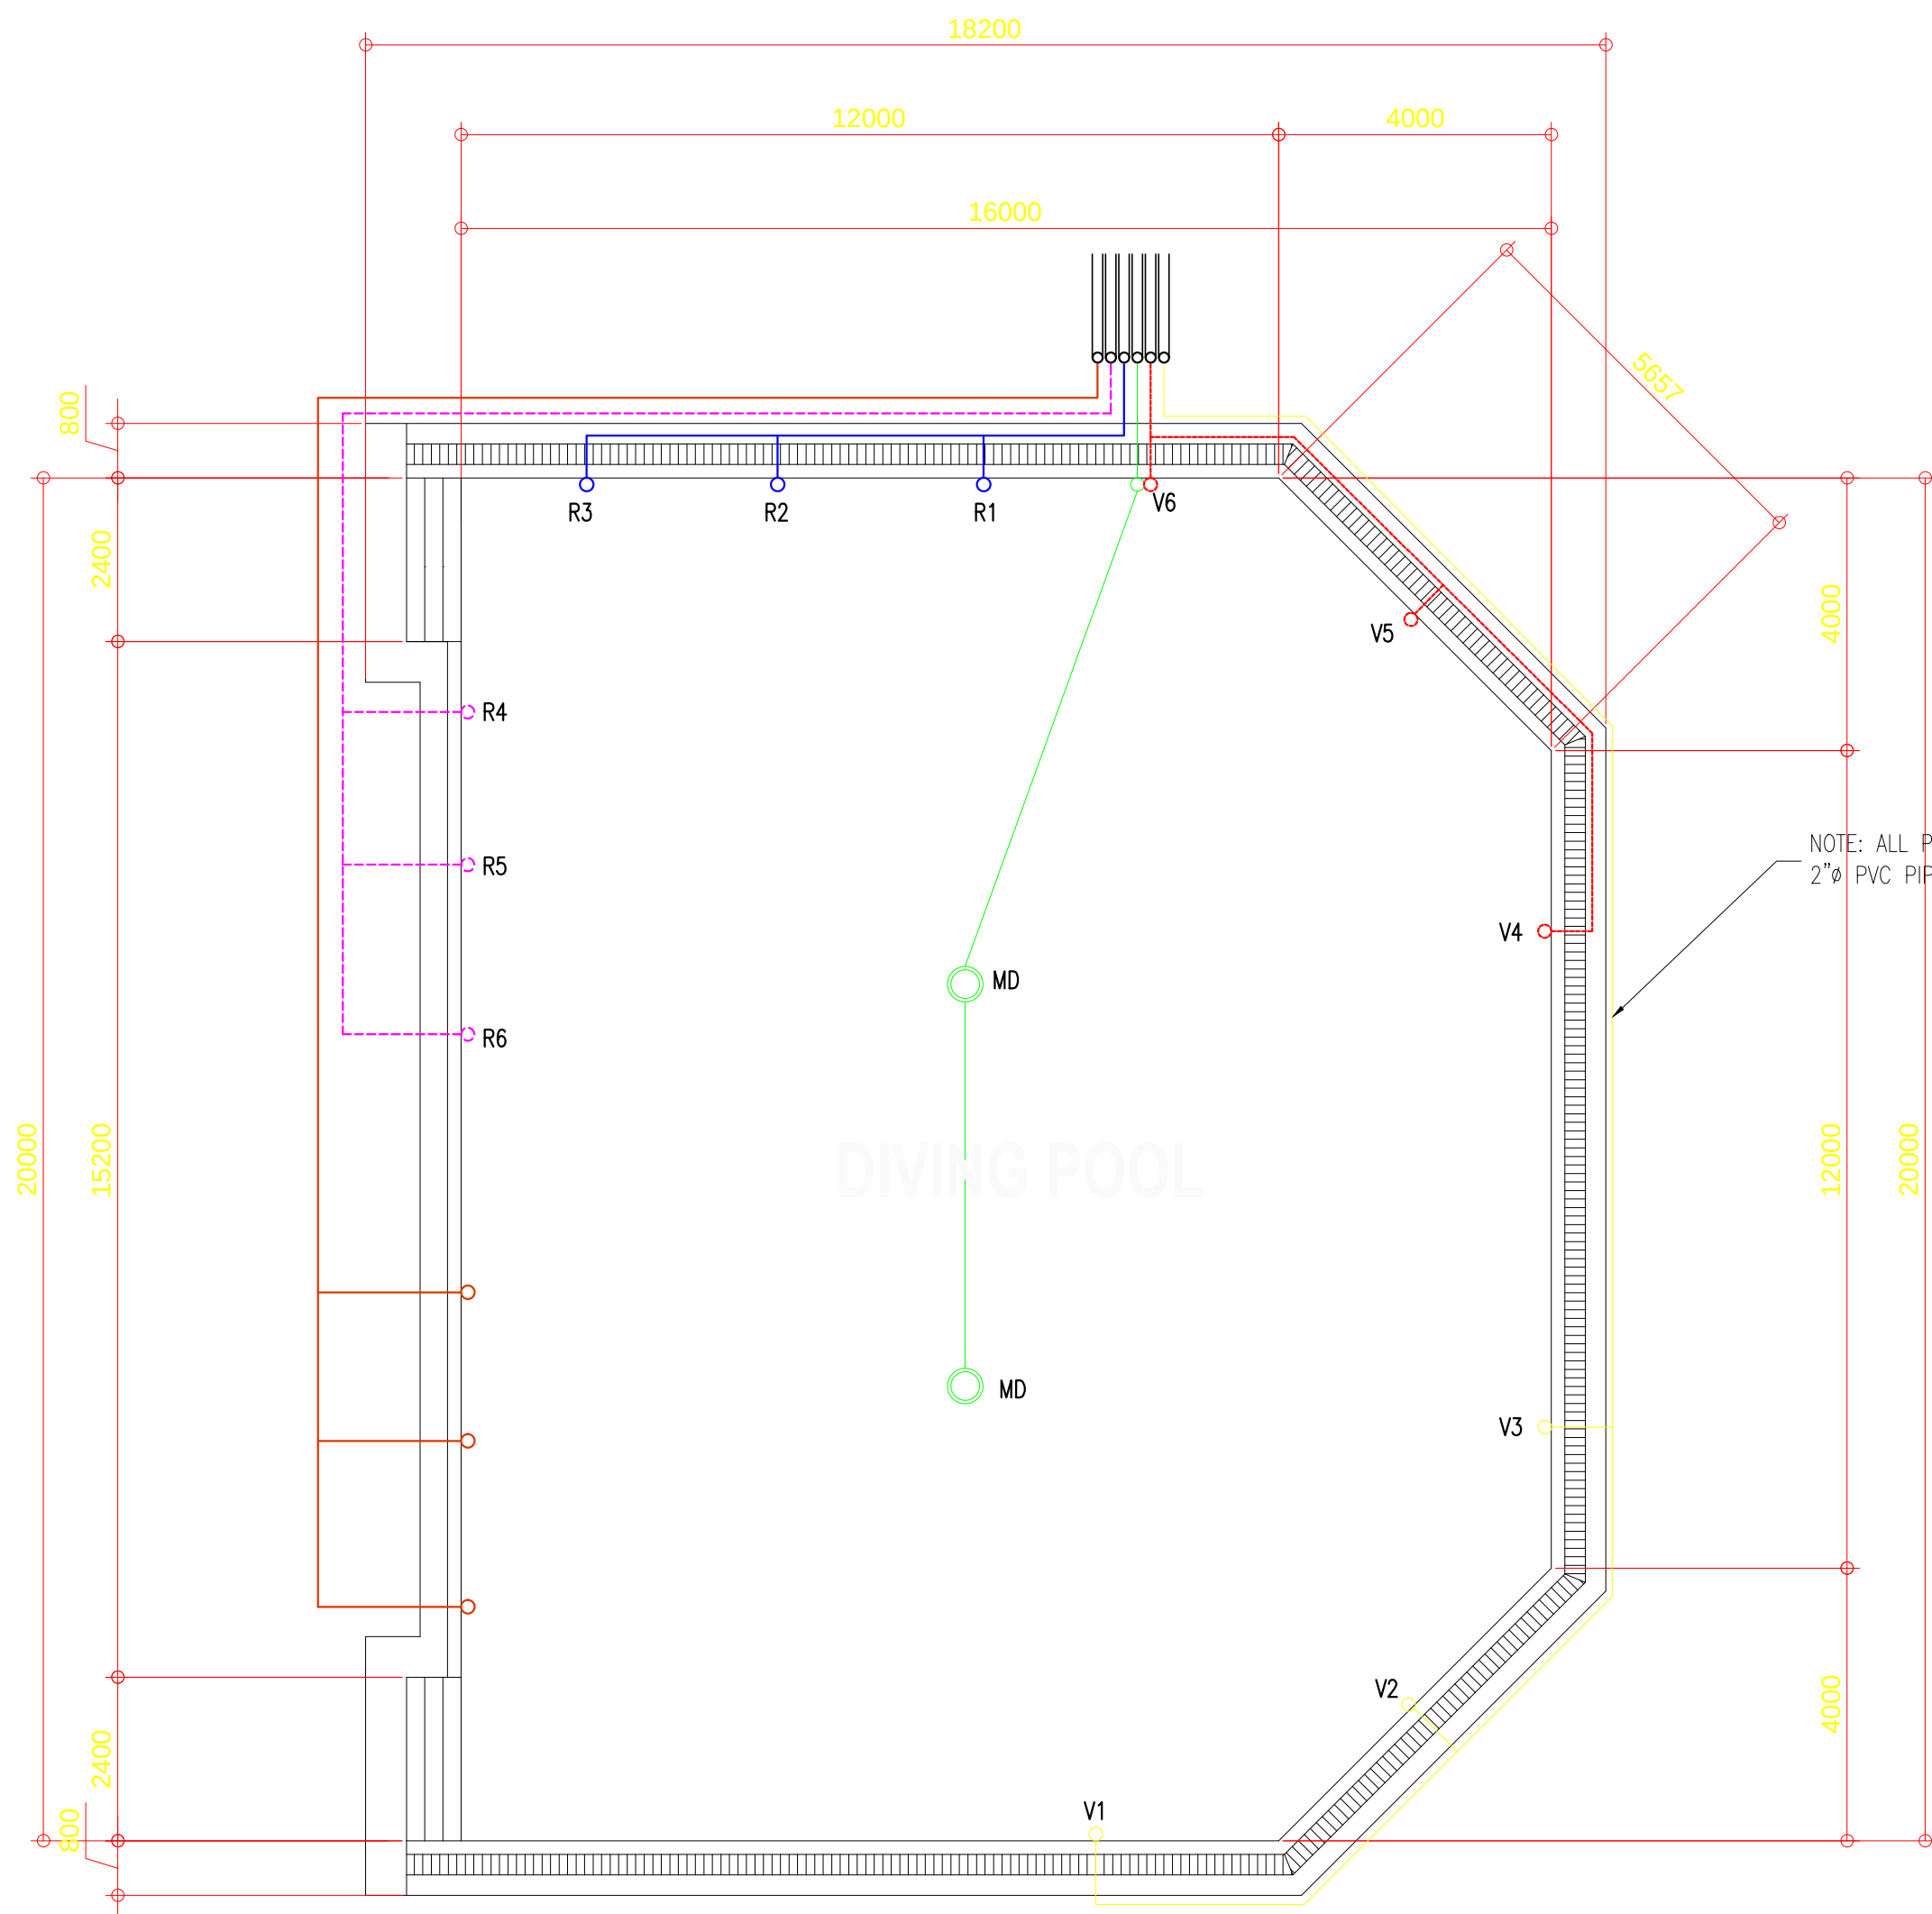

PIPING LAY-OUT
SCALE 1:100 MTS.

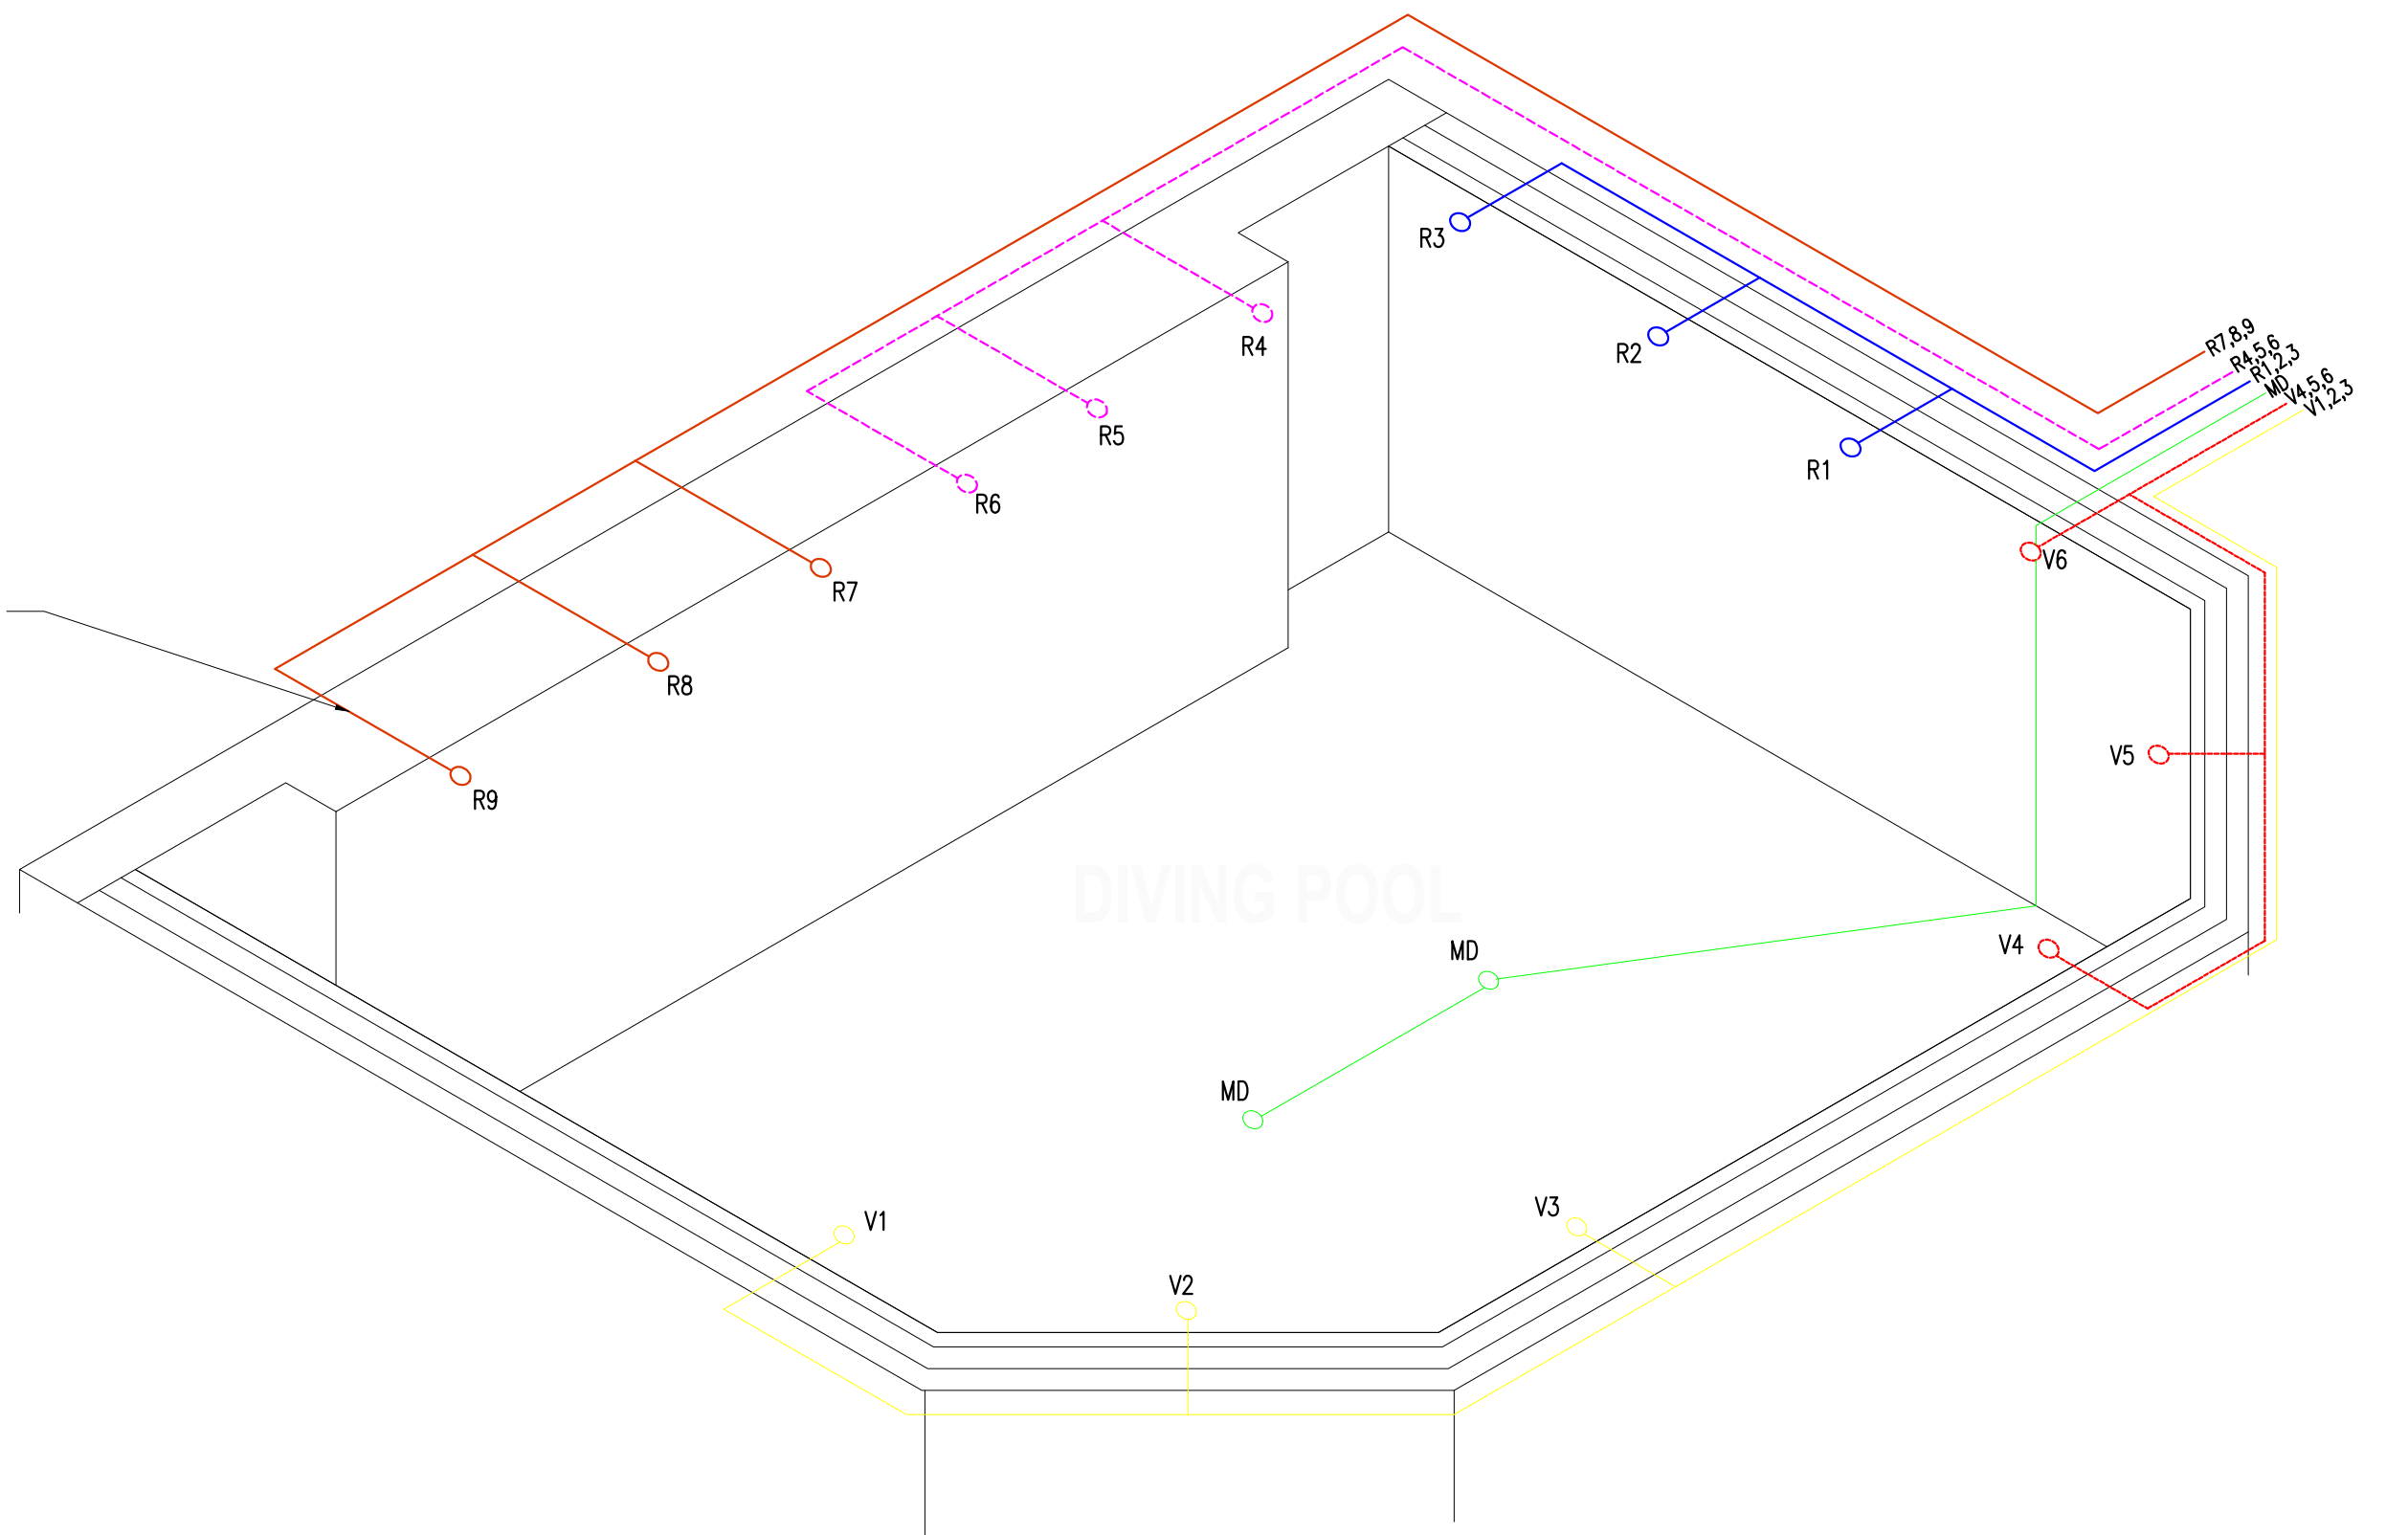

ISOMETRIC PIPING LAY-OUT
SCALE 1:100 MTS.

OWNER	PROJECT TITLE :	SUBMITTED BY :	RECOMMENDING APPROVAL :	APPROVED BY :	SHEET CONTENTS :	DESIGN BY :		SHEET NO :
 PHILIPPINE SPORTS COMMISSION RMSG, PABLO OCAMPO SR. ST., MALATE, MANILA	UPGRADING OF SWIMMING POOL, DIVING POOL, WARM UP POOL AND CONSTRUCTION OF NEW BLEACHERS,AND JACUZZI LOCATION: RMSG, PABLO OCAMPO SR. ST., MALATE, MANILA	ENGR. PEDRO I. PINEDA JR. HEAD - ENGINEERING UNIT	DIR. MERLITA R. IBAY DEPUTY EXECUTIVE DIRECTOR	HON. WILLIAM I. RAMIREZ CHAIRMAN	AS SHOWN	DRAWN BY : CHECKED BY : DATE : APPROVED BY :		P 1